
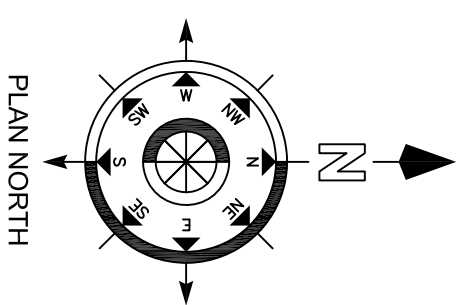


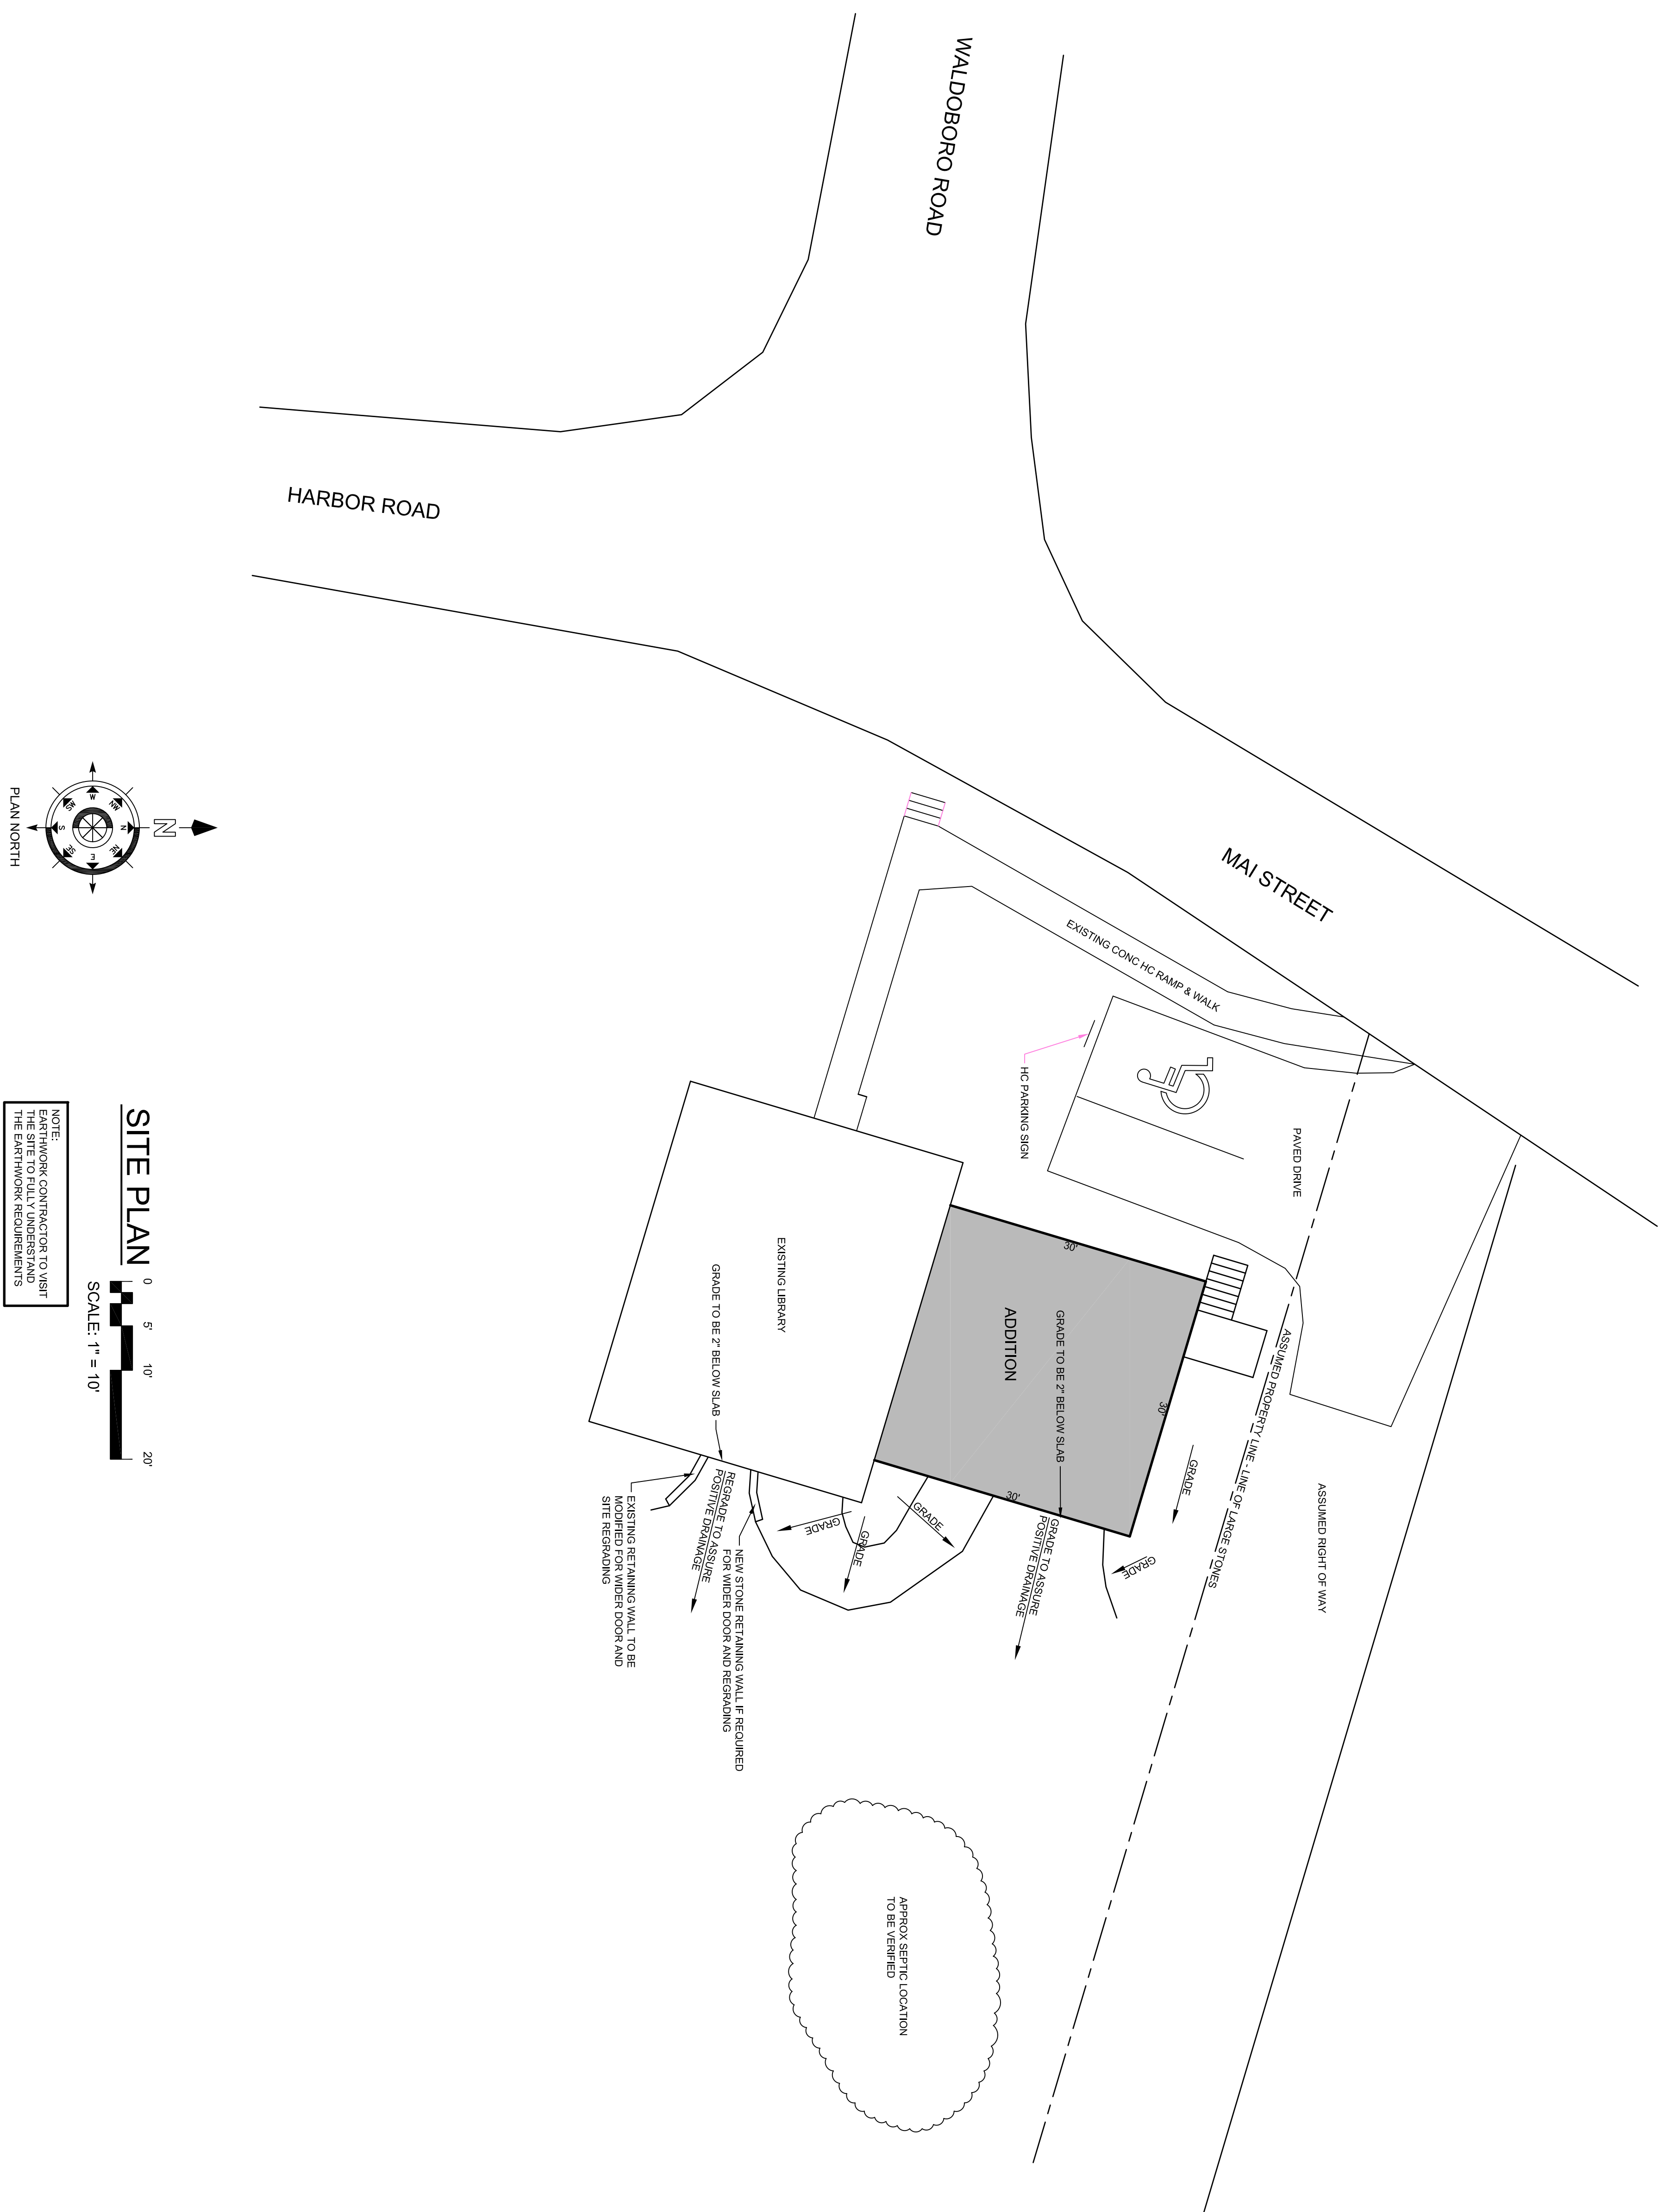

SITE PLAN

0 5 10 20


SCALE: 1" = 10'


NOTE:
EARTHWORK CONTRACTOR TO VISIT
THE SITE TO FULLY UNDERSTAND
THE EARTHWORK REQUIREMENTS

NO.	REVISIONS	DATE

PROJECT:	FRIENDSHIP LIBRARY
ADDRESS:	3 MAINE STREET FRIENDSHIP, MAINE



Chuck Campbell Architect PLLC
127 UNION ROAD
Waldoboro, Maine 04572
TEL (207)557-0448
e-mail chuck@chuckcampbellarchitect.com

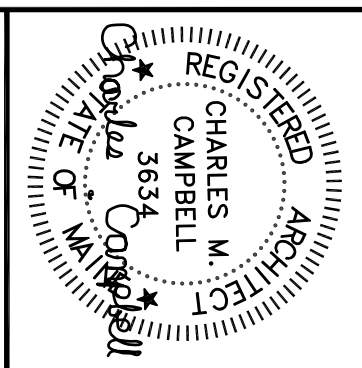


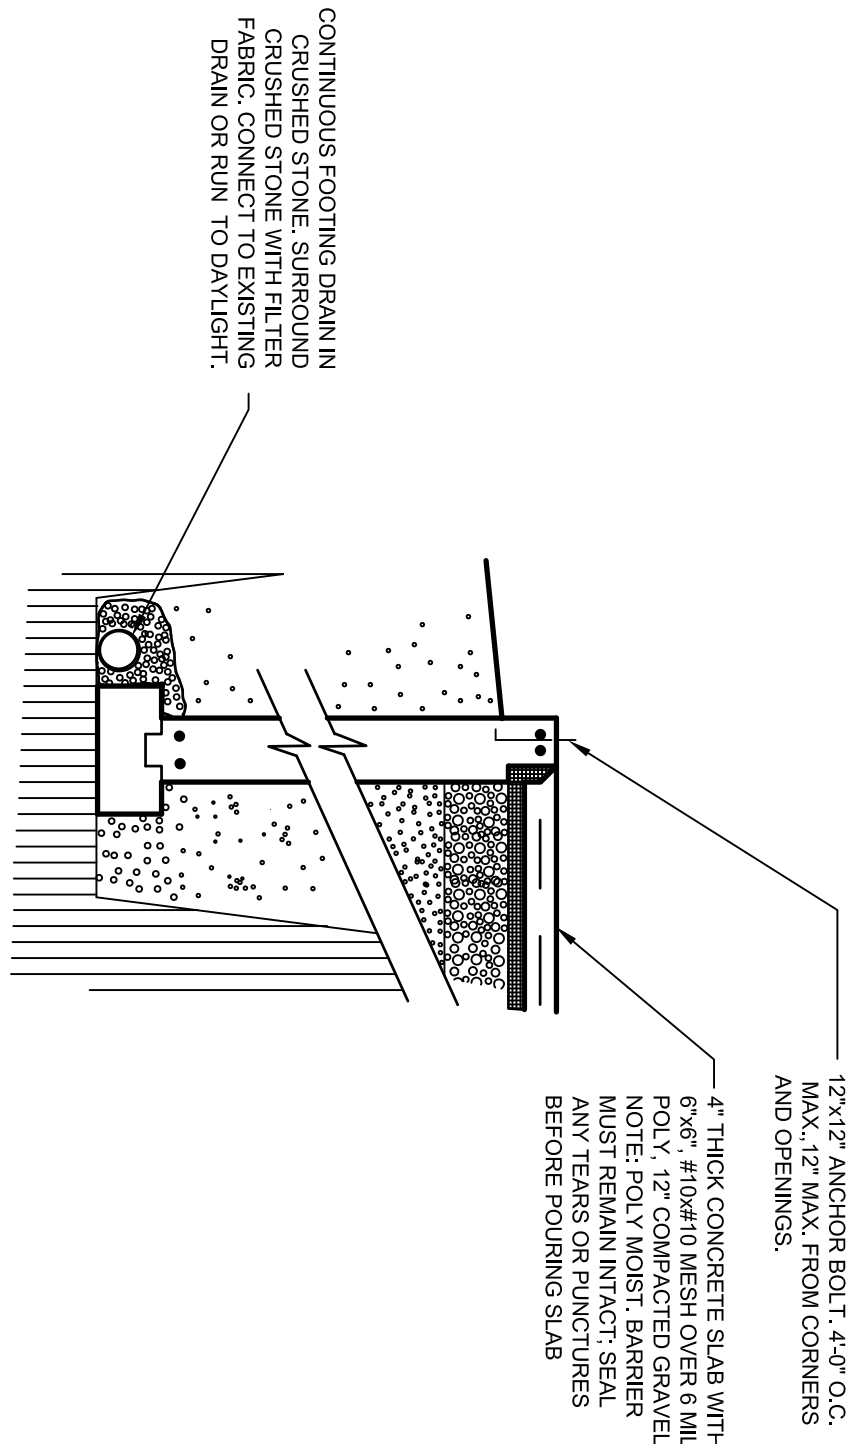


C FOUNDATION DETAIL



NOTE:
IF BEARING SOIL HAS BEEN DISTURBED OR IS HIGHLY PERMEABLE, INSTALL A LAYER OF 6 MIL. POLY UNDER THE LAYER OF CRUSHED STONE.

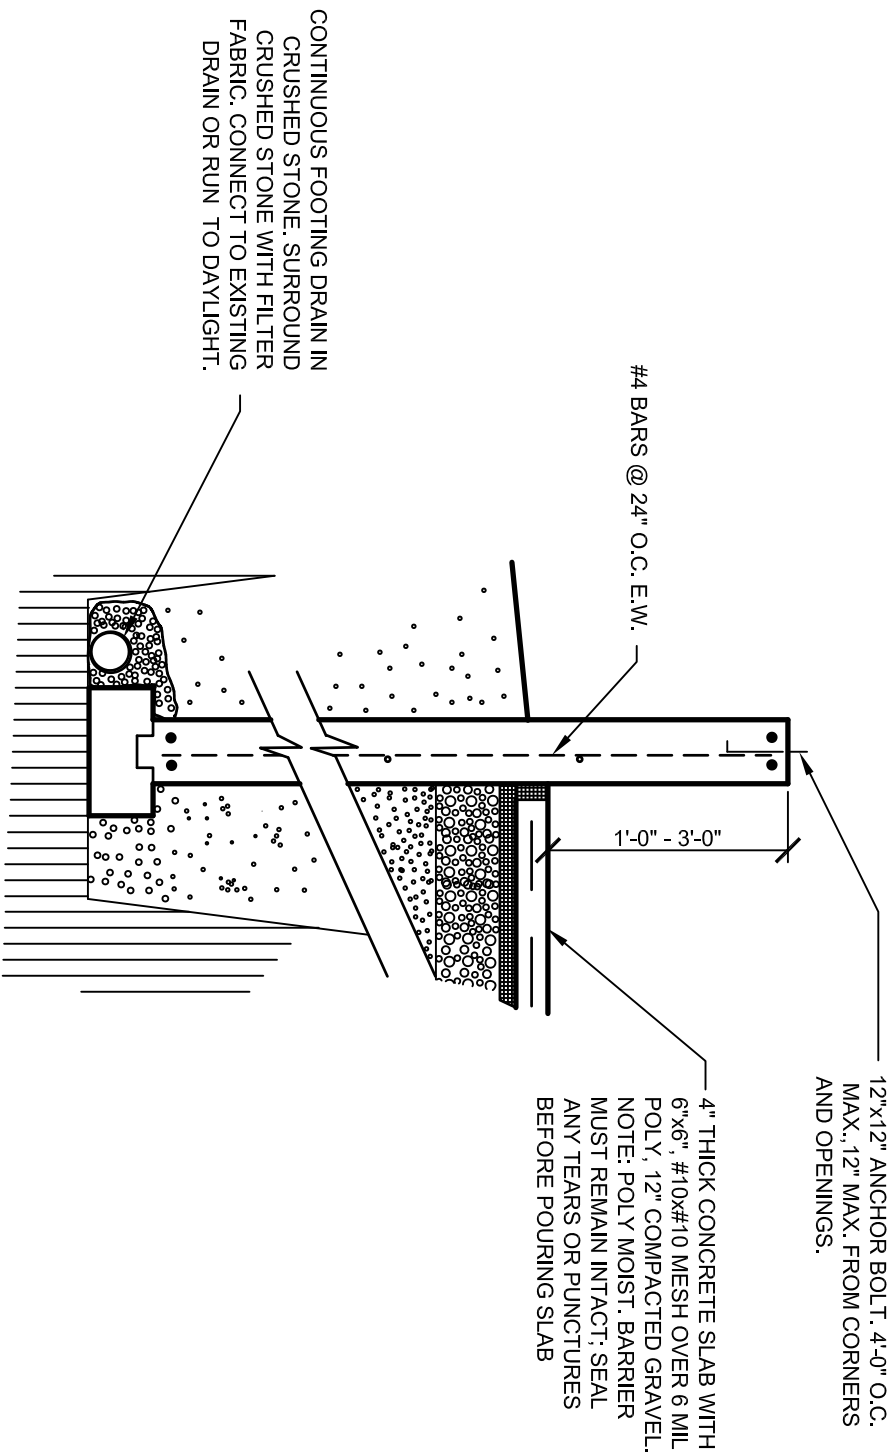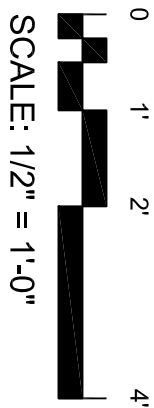



B FOUNDATION DETAIL

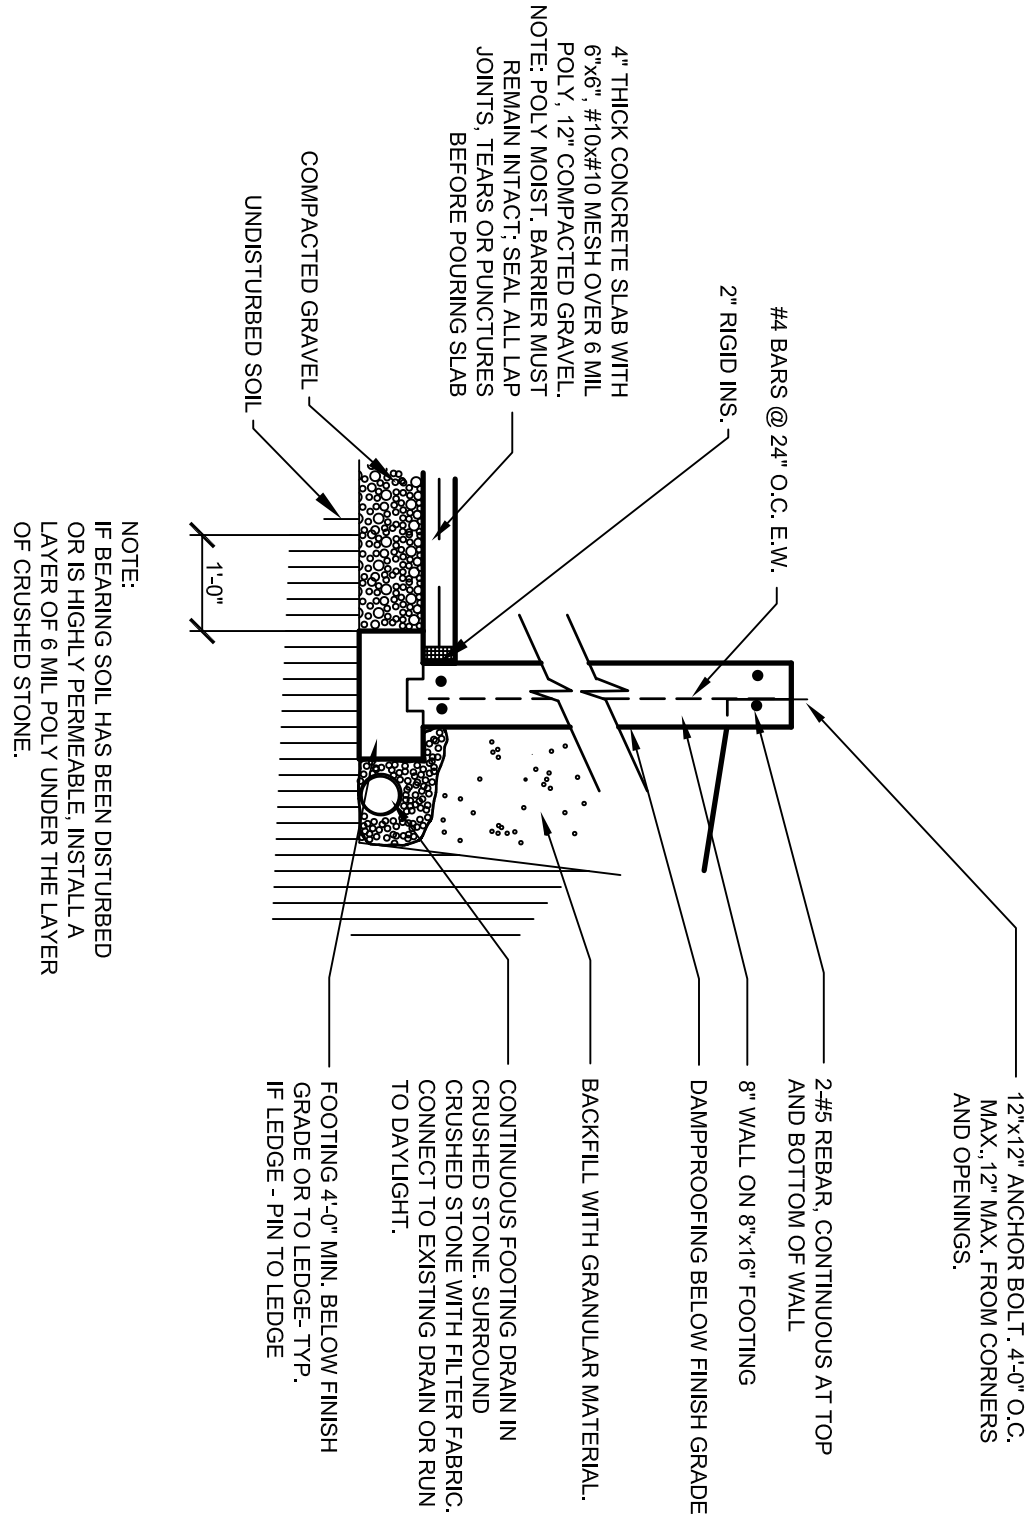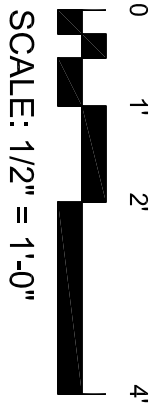



A FOUNDATION DETAIL

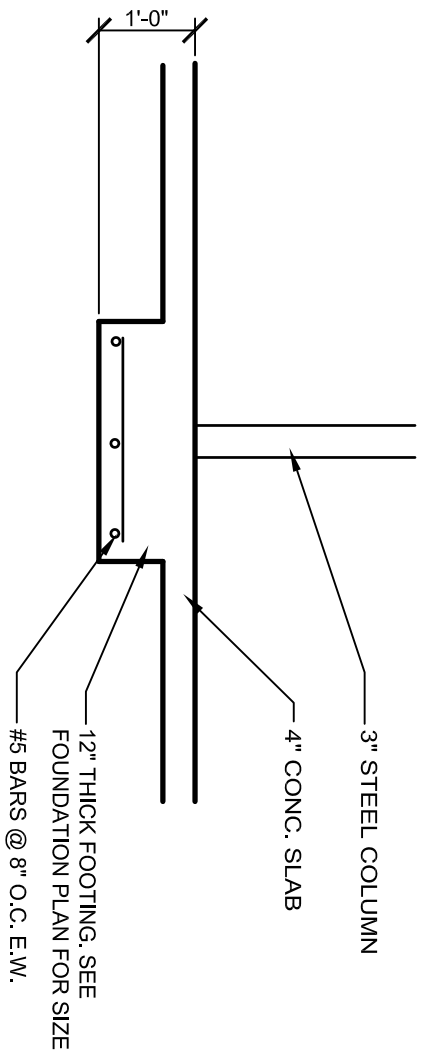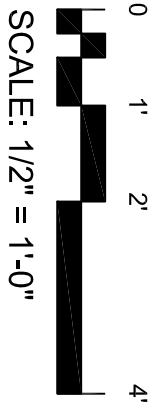



D FOOTING DETAIL

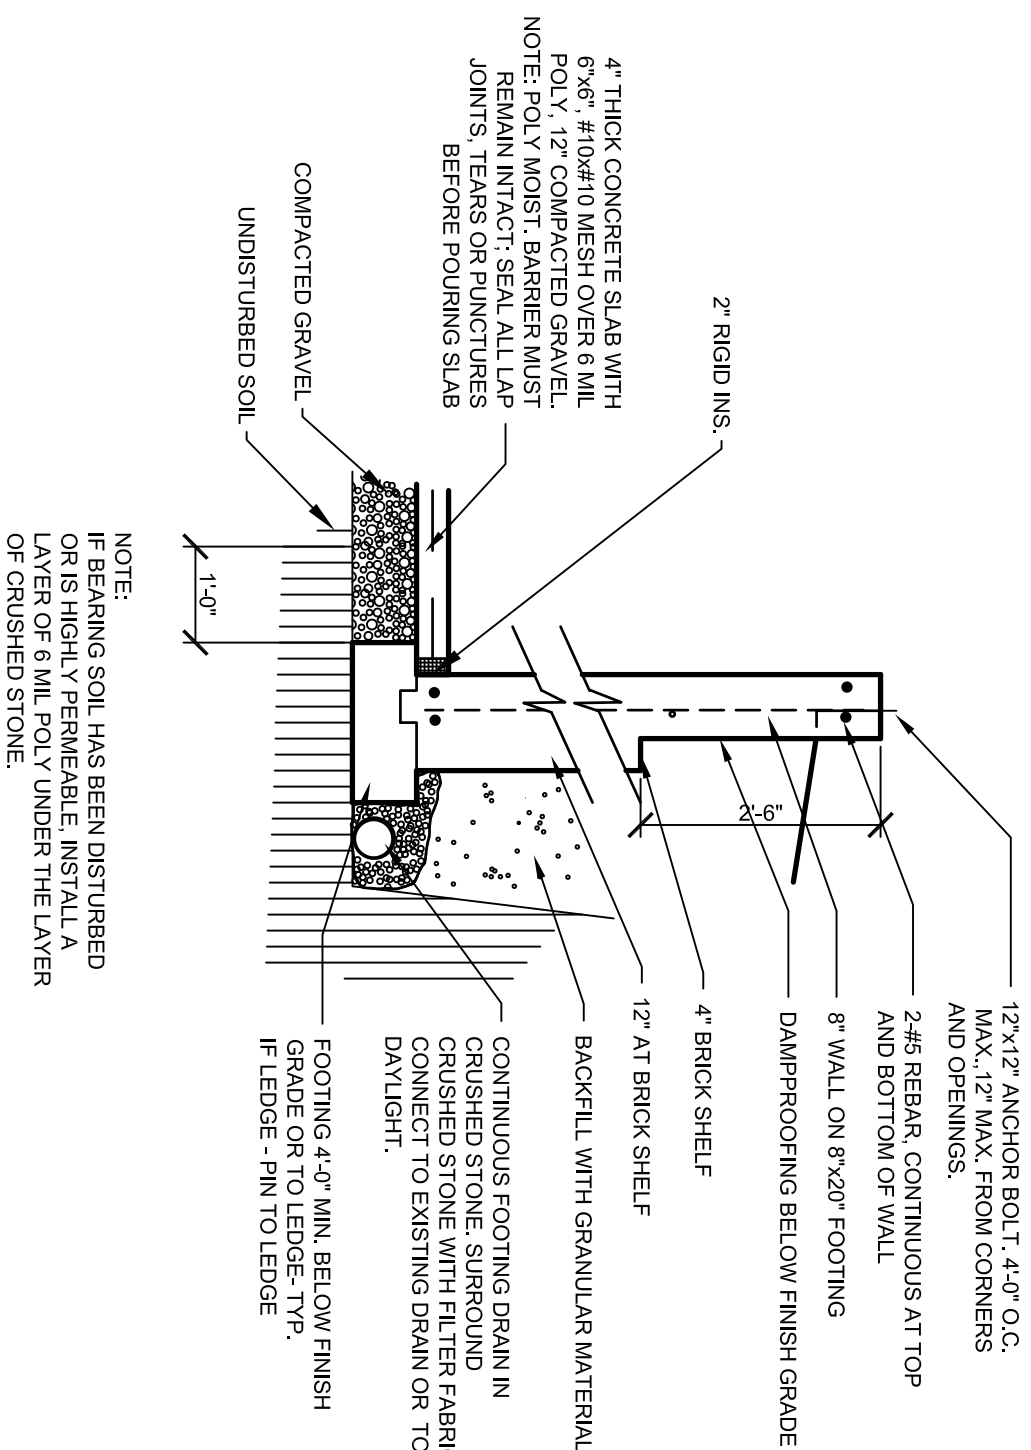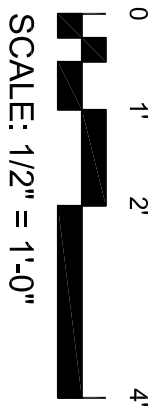


E FOUNDATION DETAIL

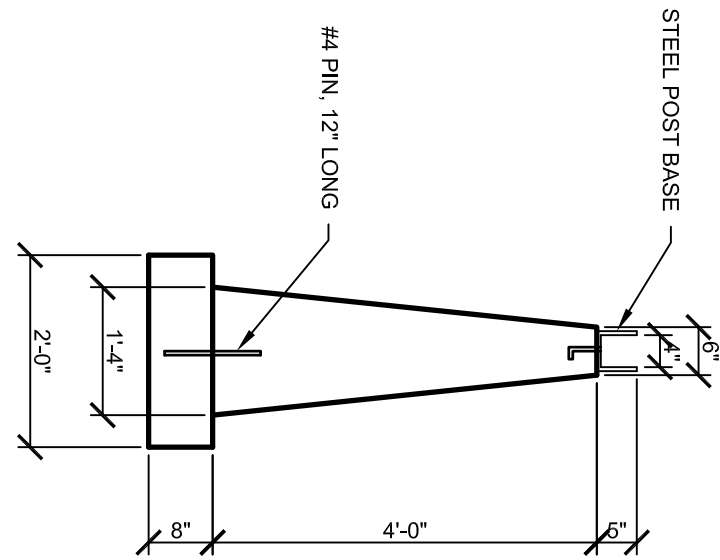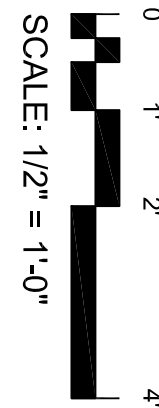

F FOUNDATION DETAIL

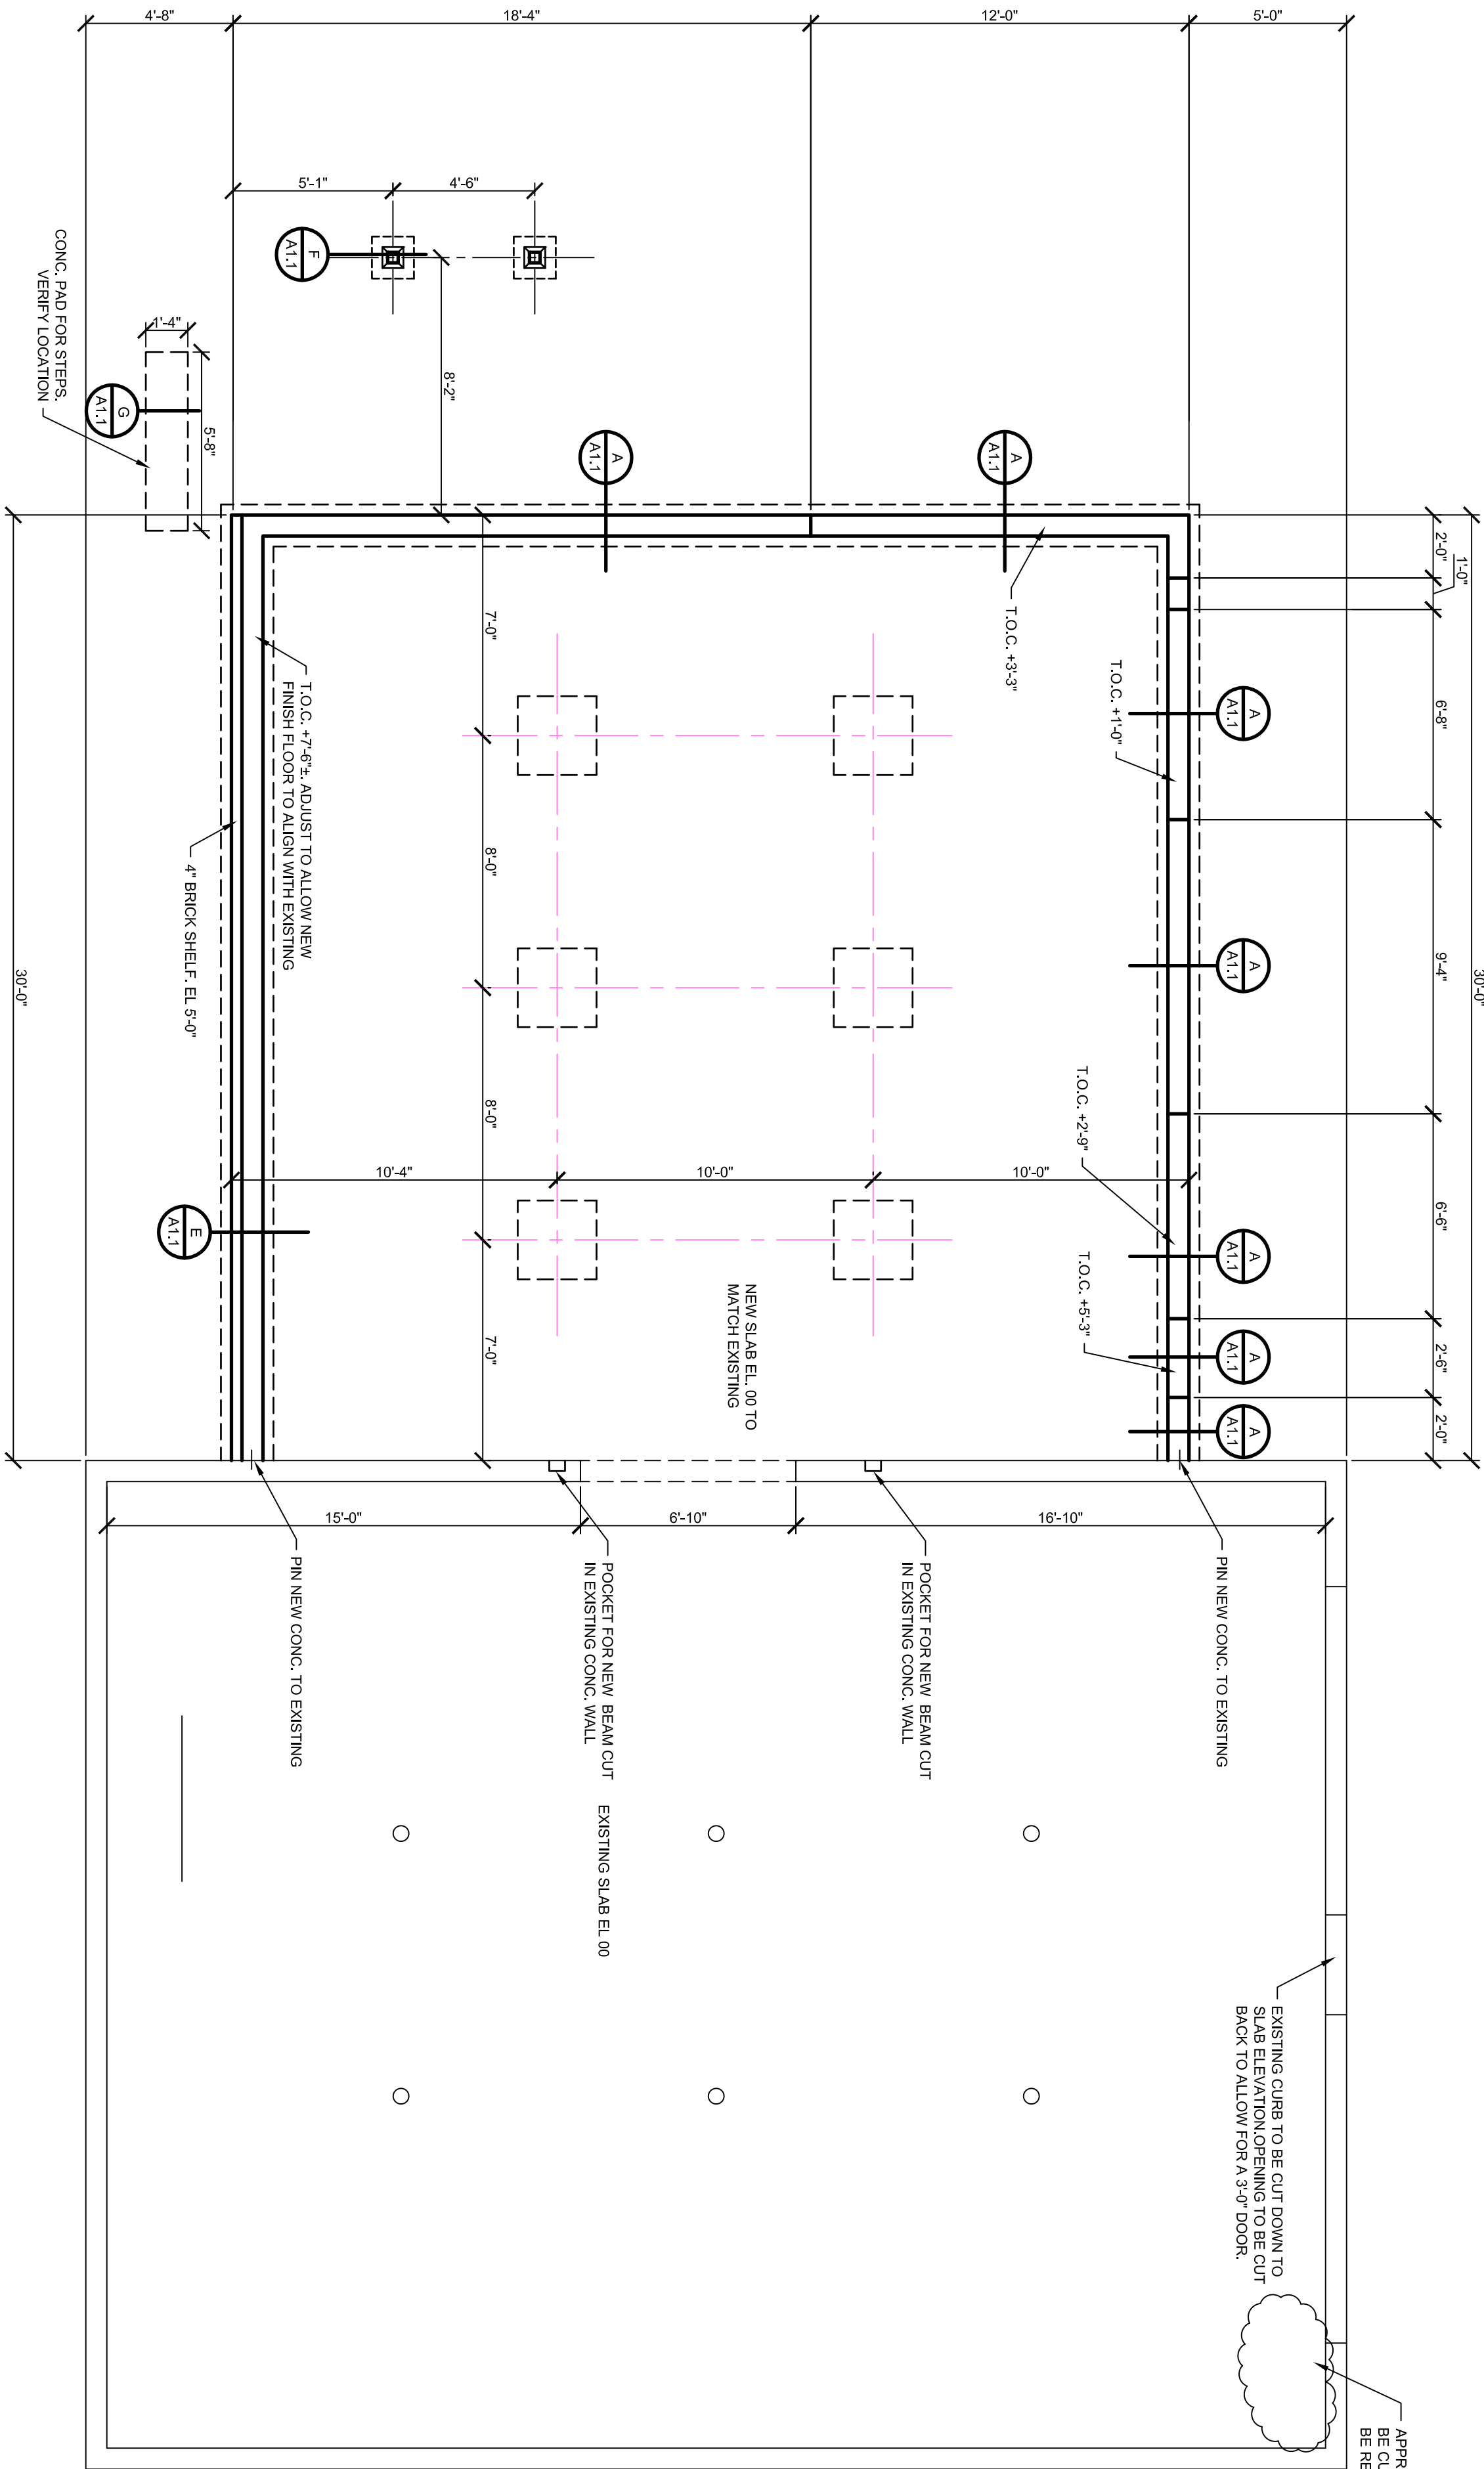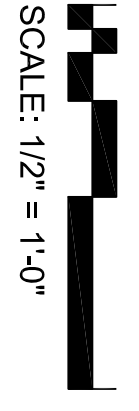

FOUNDATION PLAN

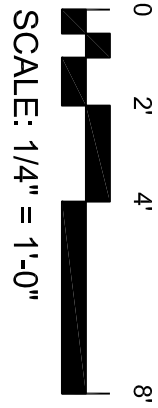

- ### FOUNDATION NOTES
1. THE CONTRACTOR SHALL VERIFY ALL CONDITIONS AND DIMENSIONS IN THE FIELD.
 2. ALL FOOTINGS SHALL BE PLACED ON LEVEL, UNDISTURBED SOIL.
 3. MINIMUM SOIL BEARING PRESSURE IS 2000 LBS. PER SQ. FT.
 4. CONCRETE SHALL BE PLACED AT A MINIMUM COMPRESSIVE STRENGTH OF 3000 PSI AT 28 DAYS.
 5. ALL SLABS SHALL BE REINFORCED WITH 2#5 REBAR. THE REINFORCEMENT SHALL BE PLACED IN THE MIDDLE OF THE SLAB.
 6. 12"x10" ANCHOR BOLTS SHALL BE EMBEDDED AT LEAST 7" INTO THE CONCRETE. BOLTS SHALL BE SPACED NOT TO EXCEED 6' ON CENTER WITH BOLTS NOT OVER 12" FROM CUT END OF SLAB.
 6. IF LEDGE IS ENCOUNTER, PIN FOOTINGS TO LEDGE.

PROJECT: **FRIENDSHIP LIBRARY**

ADDRESS: **3 MAINE STREET**

FRIENDSHIP, MAINE


Chuck Campbell Architect PLLC

127 UNION ROAD

Waldoboro, Maine 04572

TEL (207)557-0448

e-mail chuck@chuckcampbellarchitect.com

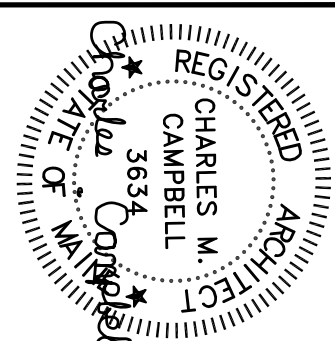

A1.1


PROJ. ID: **FRIENDSHIP**

SHEET TITLE: **FOUNDATION PLAN**

AS INDICATED

SCALE: **AUGUST 13, 2026**

NO.	REVISIONS	DATE

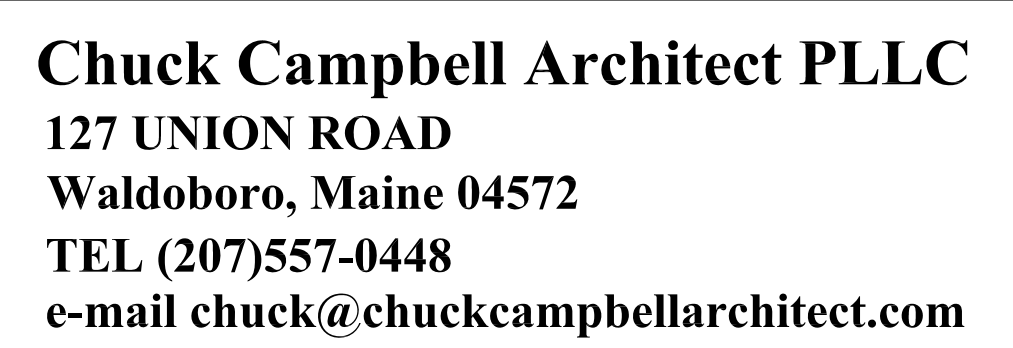


ADDRESS: **3 MAINE STREET**
FRIENDSHIP, MAINE

ADDRESS:

DATE: **AUGUST 13, 2026**



PROJ. ID. FRIENDSHIP



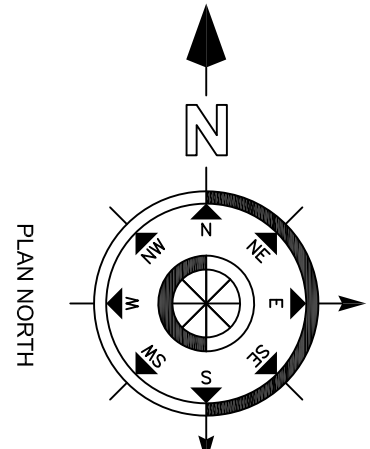


FLOOR PLAN

SCALE: 1/4" = 1'-0"

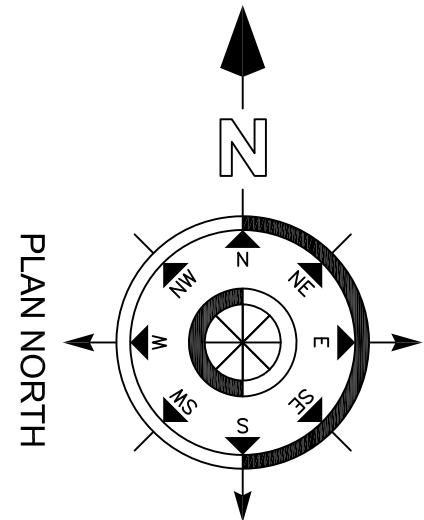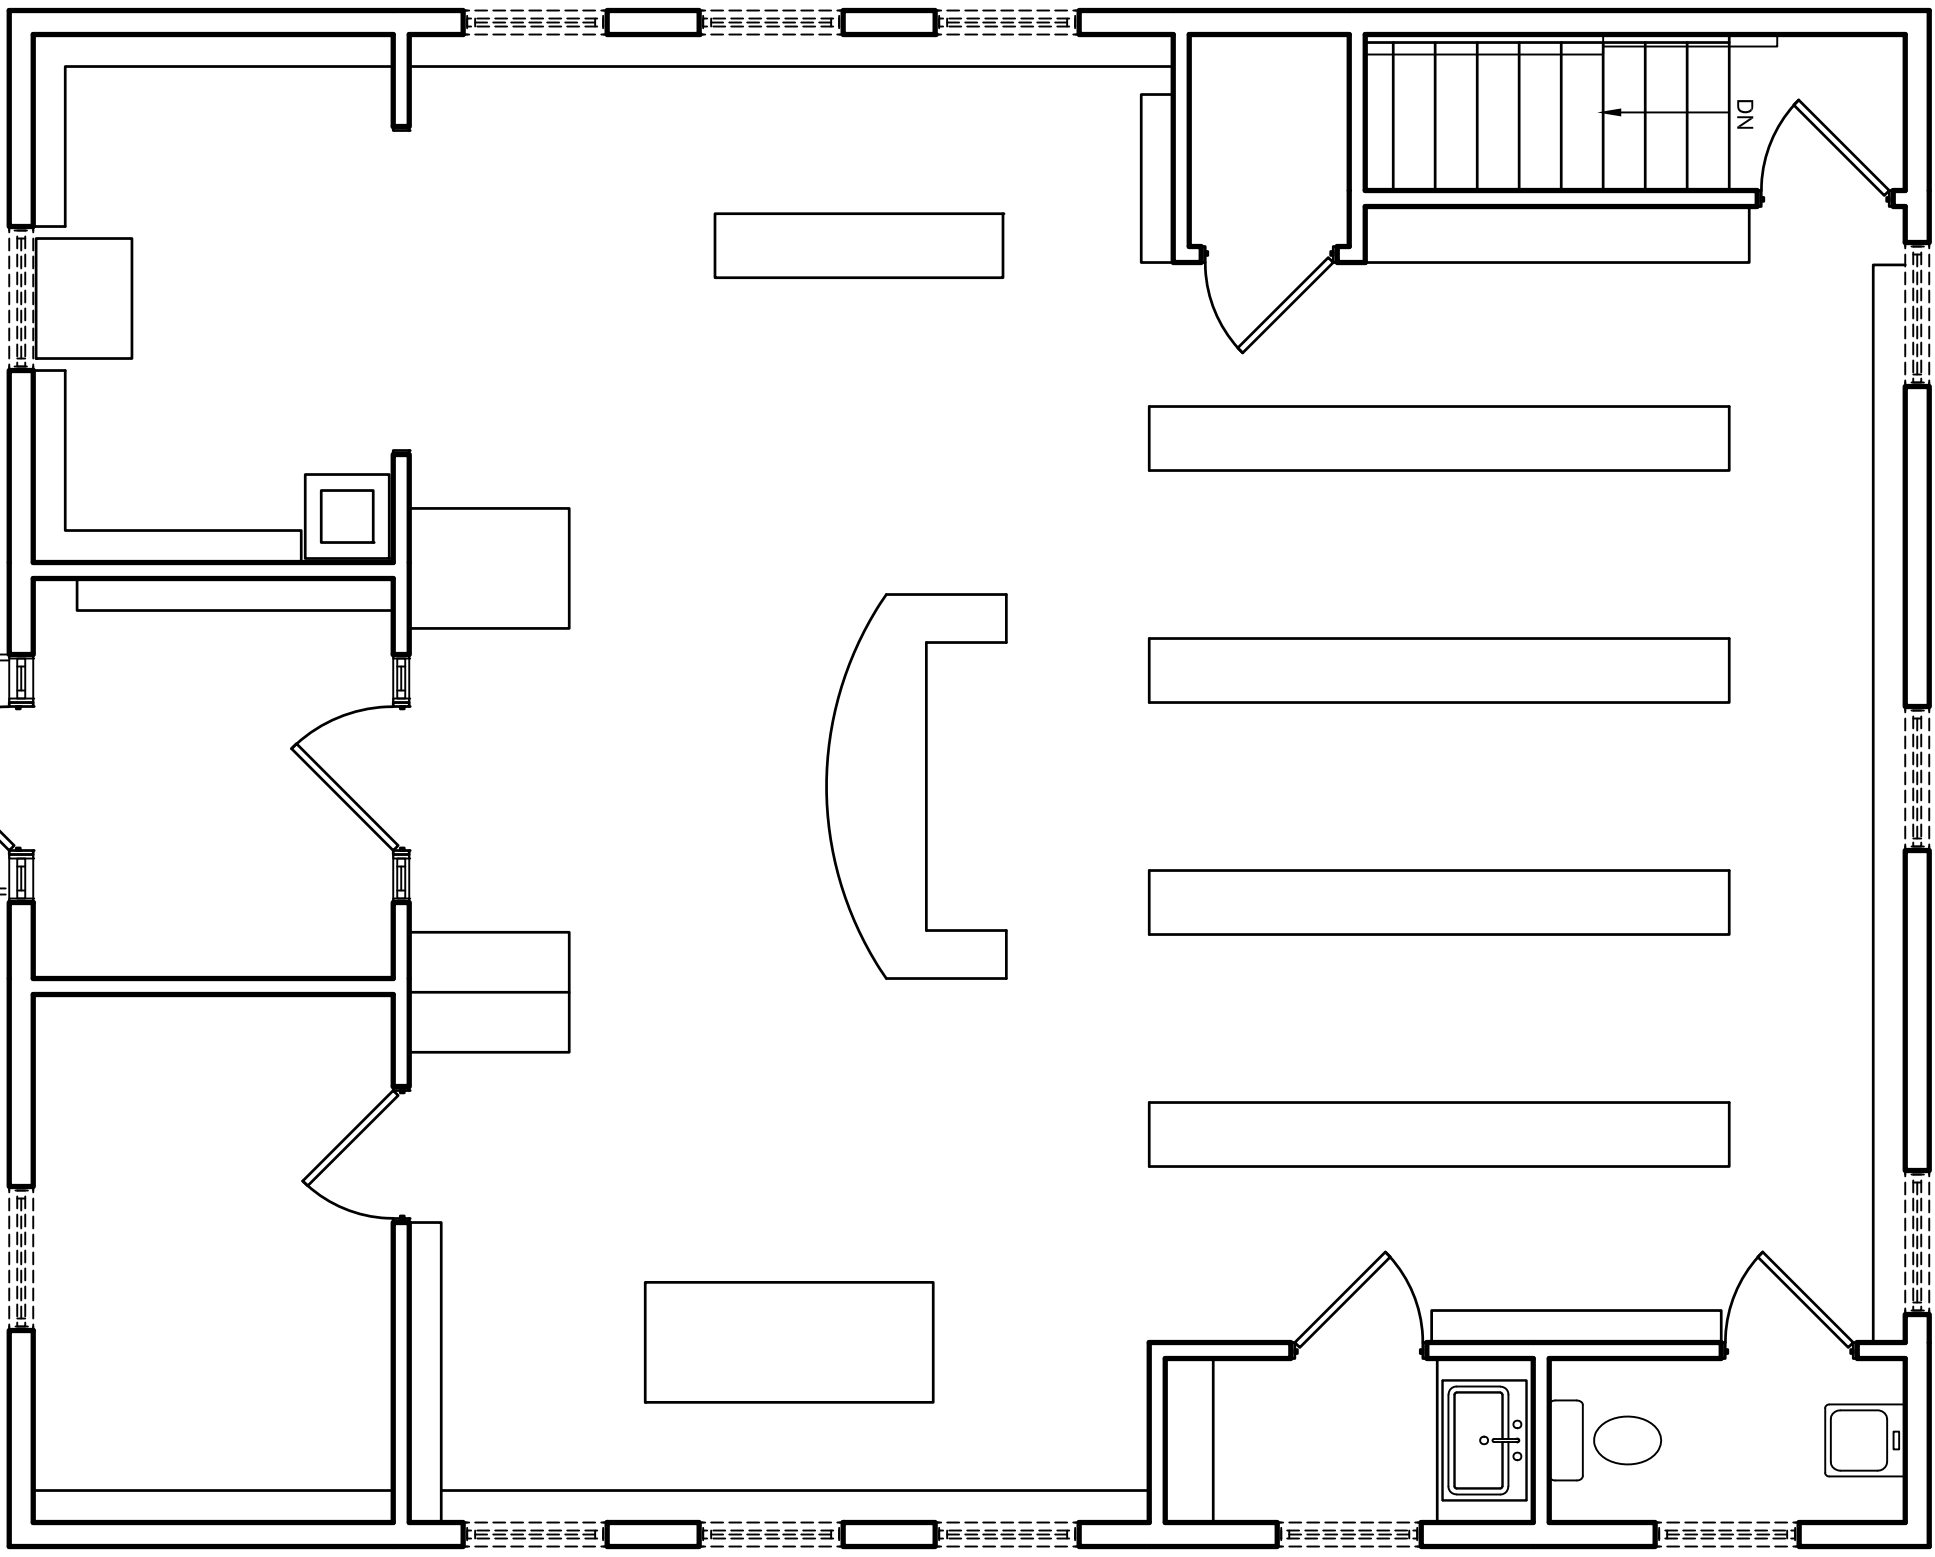

FLOOR PLAN

SCALE: 1/4" = 1'-0"

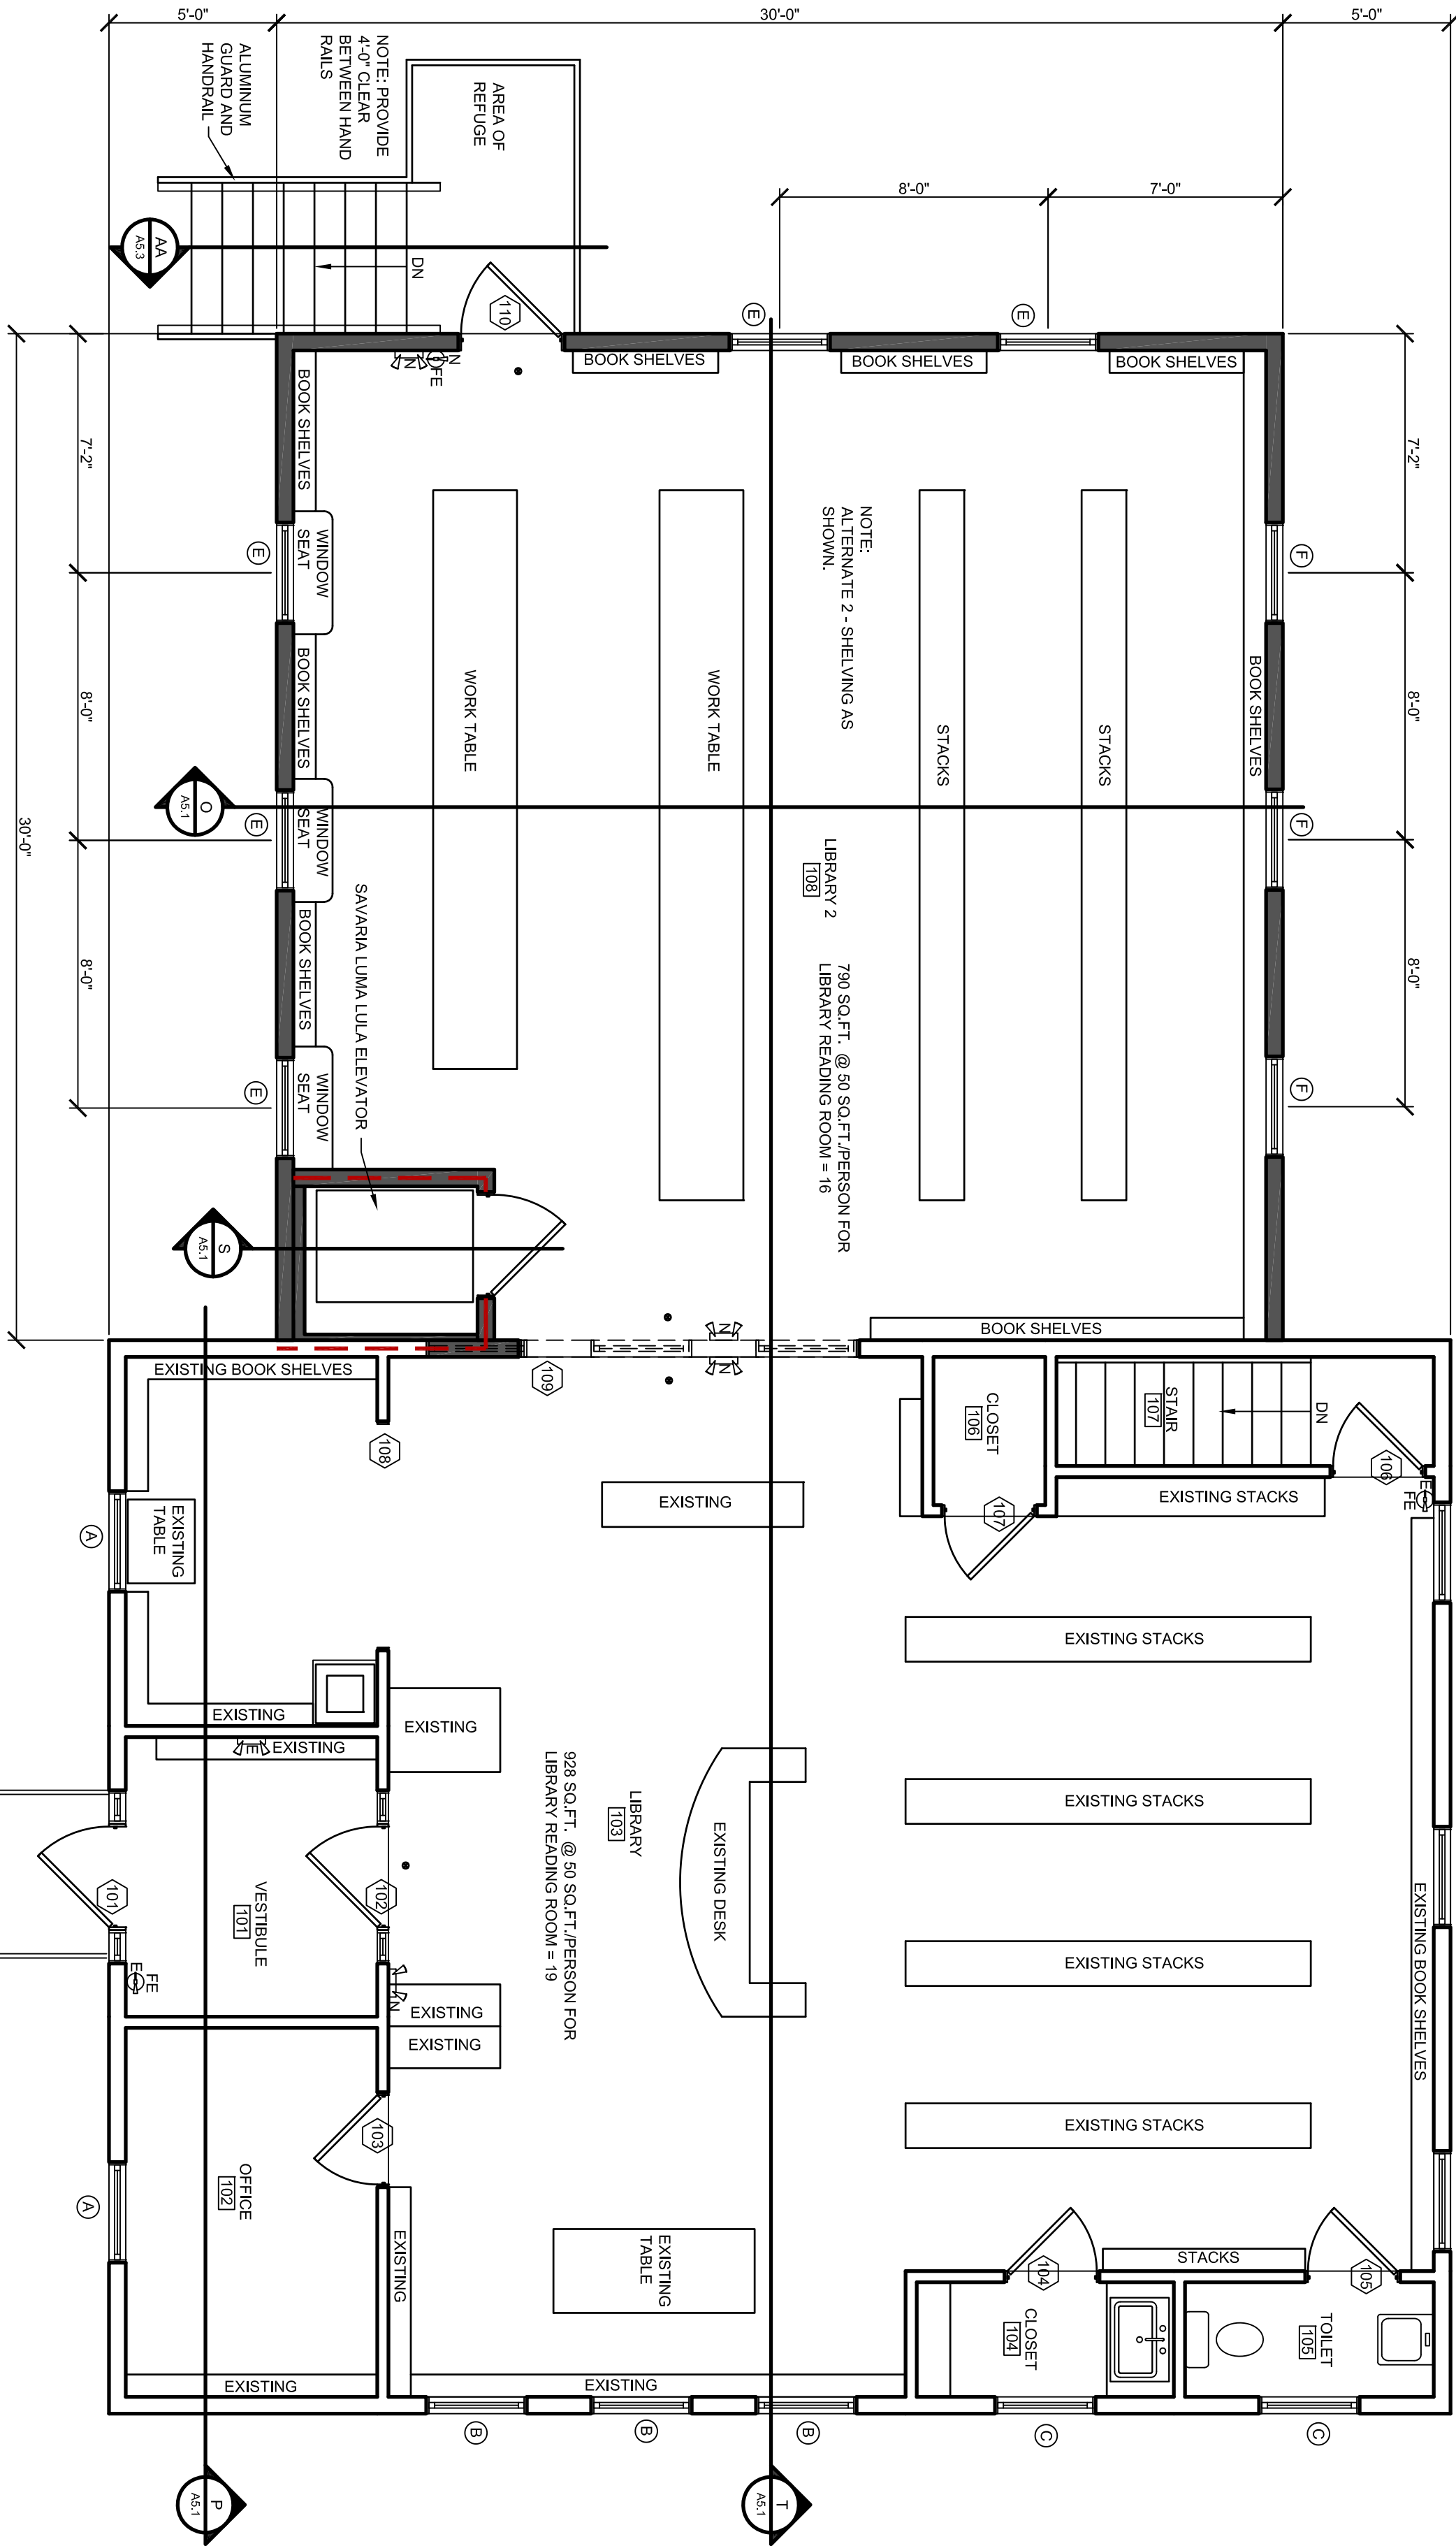



SHEET TITLE:
FLOOR PLAN
AS INDICATED
SCALE:
AUGUST 13, 2026

NO.	REVISIONS	DATE

PROJECT:
FRIENDSHIP LIBRARY
3 MAINE STREET
FRIENDSHIP, MAINE

Chuck Campbell Architect PLLC
127 UNION ROAD
Waldoboro, Maine 04572
TEL (207)557-0448
e-mail chuck@chuckcampbellarchitect.com

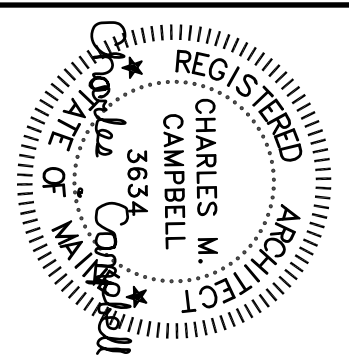

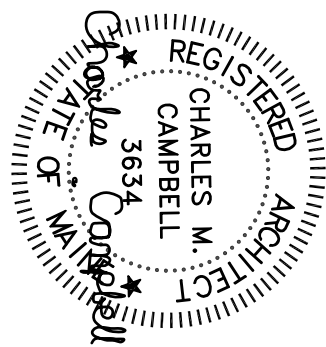

Chuck Campbell Architect PLLC
127 UNION ROAD
Waldoboro, Maine 04572
TEL (207)557-0448
e-mail chuck@chuckcampbellarchitect.com


PROJECT: **FRIENDSHIP LIBRARY**
ADDRESS: **3 MAINE STREET**
FRIENDSHIP, MAINE

NO.	REVISIONS	DATE


SHEET TITLE:	ROOF PLAN
SCALE:	AS INDICATED
DATE:	AUGUST 13, 2026

PROJ. ID: FRIENDSHIP

A1.4

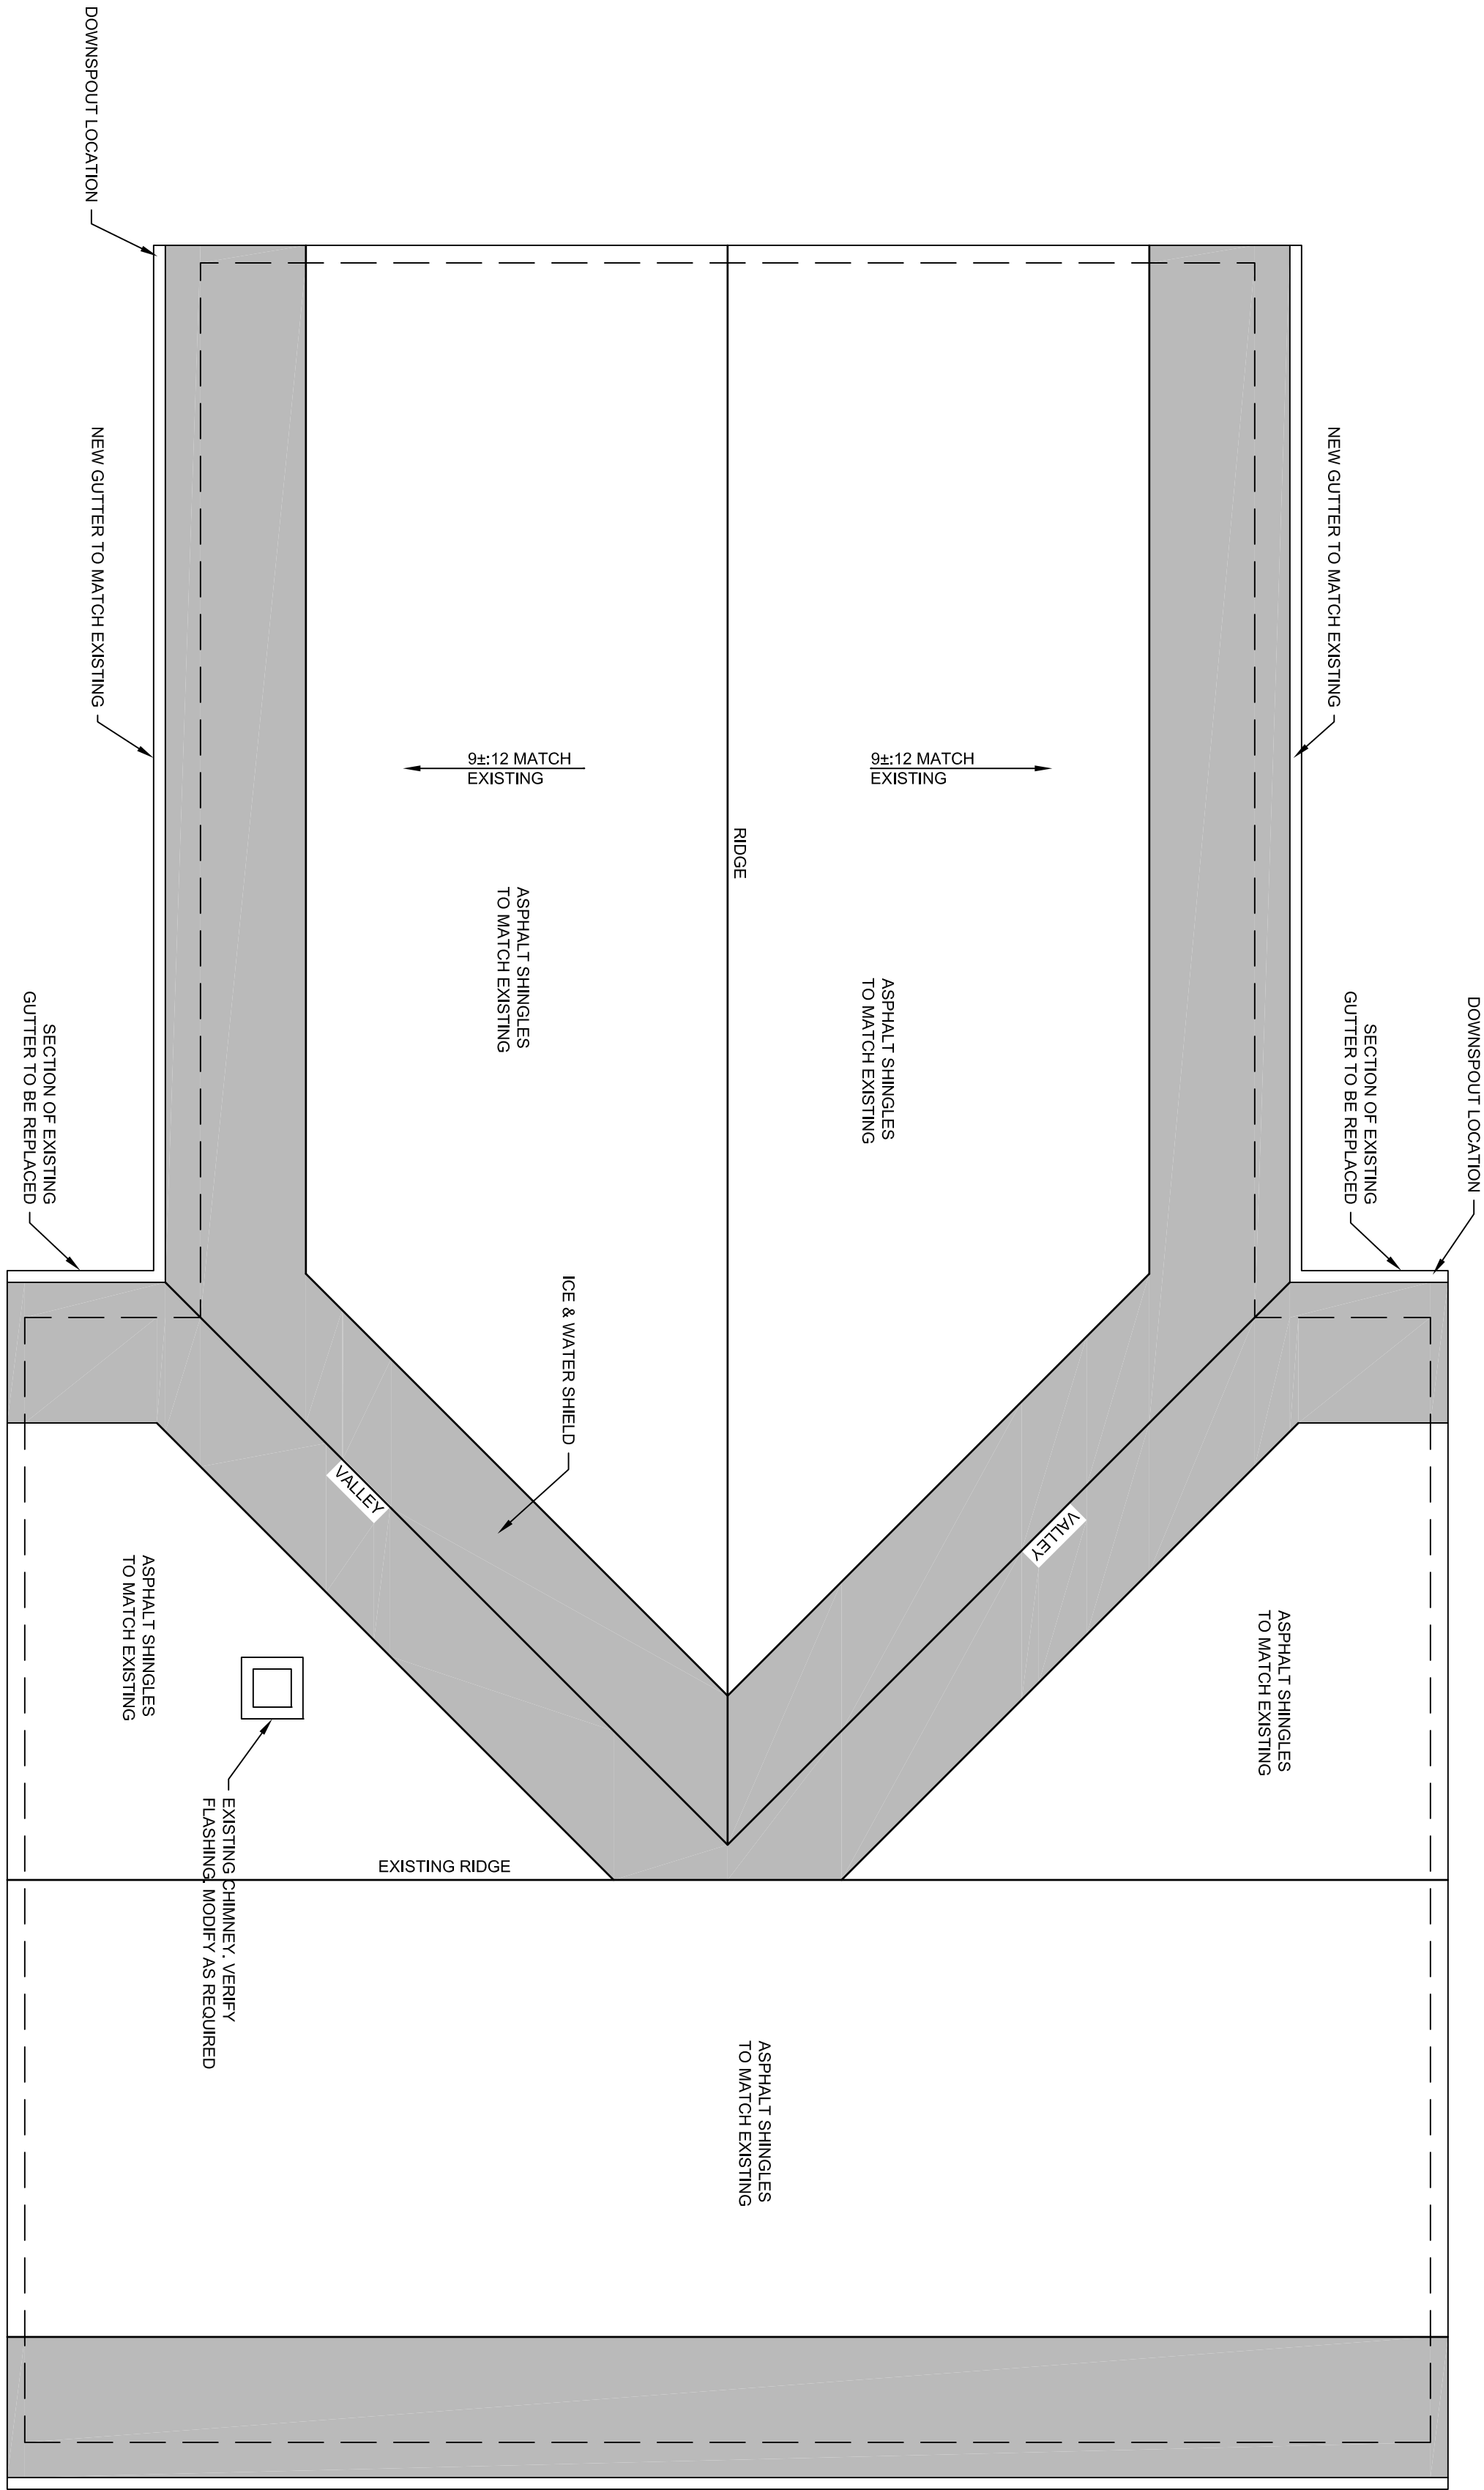


NOTE: EXISTING ROOF TO BE RESHINGLED

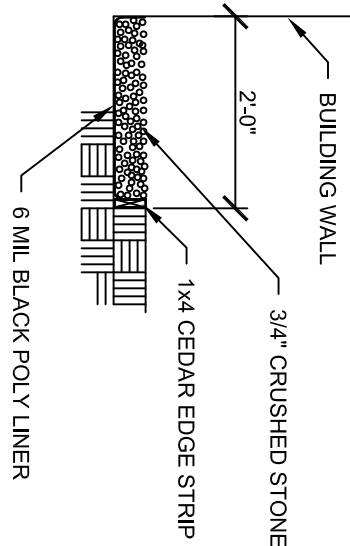

DRIP EDGE
0 1' 2' 4'
SCALE: 1/2" = 1'-0"

ROOF PLAN
0 2' 4' 8'
SCALE: 1/4" = 1'-0"

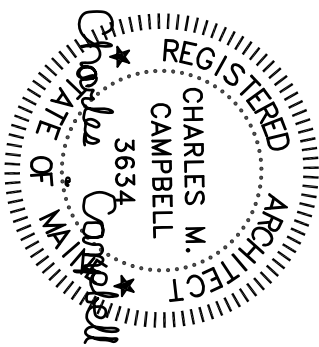

Chuck Campbell Architect PLLC
127 UNION ROAD
Waldoboro, Maine 04572
TEL (207)557-0448
e-mail chuck@chuckcampbellarchitect.com

PROJECT:	FRIENDSHIP LIBRARY
ADDRESS:	3 MAINE STREET FRIENDSHIP, MAINE


NO.	REVISIONS	DATE

PROJ. ID: FRIENDSHIP	SHEET TITLE:
	SCHEDULES
	AS INDICATED
	SCALE:
	DATE: AUGUST 13, 2026

WINDOW SCHEDULE					
LTR.	SIZE	TYPE	GRILLES	INTERIOR	MANUFACTURER / STOCK NO.
A	3'-0"-½ x 5'-0"-½	VERIFY EXISTING	GRILLES AS INDICATED ON ELEVATIONS	TRIM TO MATCH EXISTING	ANDERSEN TW210410 400 SERIES
B	3'-0"-½ x 3'-4"-½	VERIFY EXISTING	GRILLES AS INDICATED ON ELEVATIONS	TRIM TO MATCH EXISTING	ANDERSEN TW21032 400 SERIES
C	3'-0"-½ x 2'-0"-½	VERIFY EXISTING	GRILLES AS INDICATED ON ELEVATIONS	TRIM TO MATCH EXISTING	ANDERSEN A31 400 SERIES
D					
E	3'-0" x 5'-0"	CLAD D.H.	GRILLES AS INDICATED ON ELEVATIONS	TRIM TO MATCH EXISTING	ANDERSEN TW210410 400 SERIES
F	3'-0" x 3'-4"	CLAD D.H.	GRILLES AS INDICATED ON ELEVATIONS	TRIM TO MATCH EXISTING	ANDERSEN TW21032 400 SERIES

DOOR SCHEDULE					
NO.	SIZE	TYPE	HARDWARE	FRAME	REMARKS
B01	3'-0" x 6'-8"	INS. FIBERGLASS - HALF GLASS	LATCH, LOCK, LEVER HANDLE, CLOSER, PANIC DEVICE	WOOD	
B02	3'-0" x 6'-8"	20 MIN. RATED DOOR	LATCH, LOCK, LEVER HANDLE, CLOSER	WOOD	
B03	6'-0" x 6'-8"	INS. FIBERGLASS - FULL GLASS	LATCH, LOCK, LEVER HANDLE, CLOSER, PANIC DEVICE	WOOD	
B04	6'-0" x 6'-8"	SOLID CORE BIRCH - DOUBLE EGRESS	LATCH, LEVER HANDLE, CLOSER, PANIC DEVICE	WOOD	
B05	3'-0" x 6'-8"	SOLID CORE BIRCH	LATCH, PRIVACY LOCK, LEVER HANDLE,	WOOD	
		SOLID CORE BIRCH	LATCH, LOCK, LEVER HANDLE,	WOOD	
101	3'-0" x 6'-8"	EXISTING	EXISTING		
102	3'-0" x 6'-8"	EXISTING	EXISTING		
103	2'-6" x 6'-8"	EXISTING	EXISTING		
104	2'-8" x 6'-8"	EXISTING	EXISTING		
105	2'-8" x 6'-8"	EXISTING	EXISTING		
106	2'-8" x 6'-8"	EXISTING	EXISTING		
107	2'-8" x 6'-8"	EXISTING	EXISTING		
108	6'-8" x 6'-8"	EXISTING CASE OPENING		WOOD	
109	10'-0" x 6'-8"	EXISTING CASE OPENING		WOOD	
110	3'-0" x 6'-8"	INS. FIBERGLASS - HALF GLASS	LATCH, LOCK, LEVER HANDLE, CLOSER, PANIC DEVICE	WOOD	


ROOM FINISH SCHEDULE						
NO.	ROOM	FLOOR	BASE	WALLS	CEILING	REMARKS
B01	BASEMENT	LAMINATE	1x4 PINE	PAINTED GYP. BOARD		ALL TRIM TO BE REPAINTED/STAINED
B02	FURNACE	LAMINATING CONCRETE	NONE	PAINTED GYP. BOARD	PAINTED GYP. BOARD	ALL TRIM TO BE REPAINTED/STAINED
B03	TOILET	LAMINATE	1x4 PINE	PAINTED MR GYP. BOARD		ALL TRIM TO BE REPAINTED/STAINED
B04	BASEMENT 2	LAMINATE	1x4 PINE	PAINTED GYP. BOARD		ALL TRIM TO BE REPAINTED/STAINED
101	VESTIBULE	EXISTING CARPET	EXISTING	REPAINT EXISTING	REPAINT EXISTING	ALL TRIM TO BE REPAINTED/STAINED
102	OFFICE	EXISTING CARPET	EXISTING	REPAINT EXISTING	REPAINT EXISTING	ALL TRIM TO BE REPAINTED/STAINED
103	LIBRARY	EXISTING CARPET	EXISTING	REPAINT EXISTING	REPAINT EXISTING	ALL TRIM TO BE REPAINTED/STAINED
104	CLOSET	EXISTING CARPET	EXISTING	REPAINT EXISTING	REPAINT EXISTING	ALL TRIM TO BE REPAINTED/STAINED
105	TOILET	EXISTING	EXISTING	REPAINT EXISTING	REPAINT EXISTING	ALL TRIM TO BE REPAINTED/STAINED
106	CLOSET	EXISTING CARPET	EXISTING	REPAINT EXISTING	REPAINT EXISTING	ALL TRIM TO BE REPAINTED/STAINED
107	STAIR	EXISTING CARPET AND WOOD TREADS AND RISERS	EXISTING	REPAINT EXISTING	REPAINT EXISTING	ALL TRIM TO BE REPAINTED/STAINED
108	LIBRARY 2		1x4 PINE	PAINTED GYP. BOARD	PAINTED GYP. BOARD	ALL TRIM TO BE PAINTED/STAINED

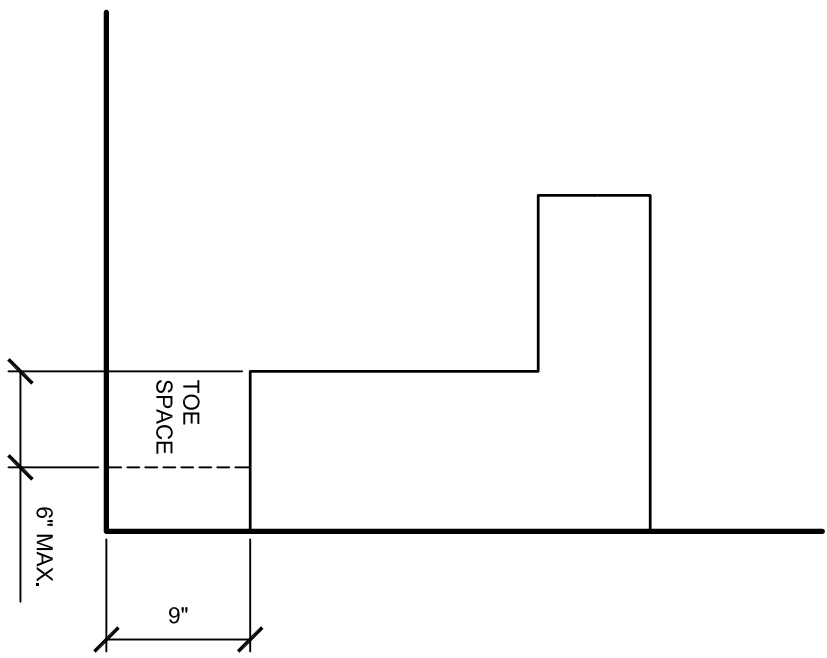

1
2.5" K
A3.1

TOE CLEARANCE


N.T.S.

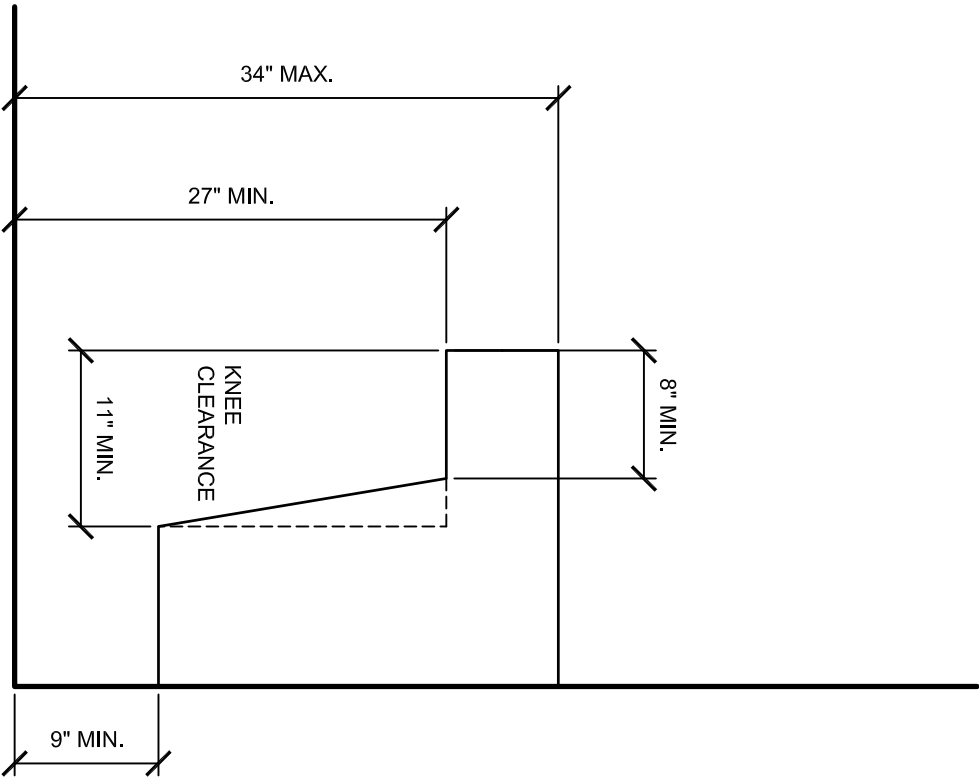

K
A3.1

KNEE CLEARANCE

N.T.S.

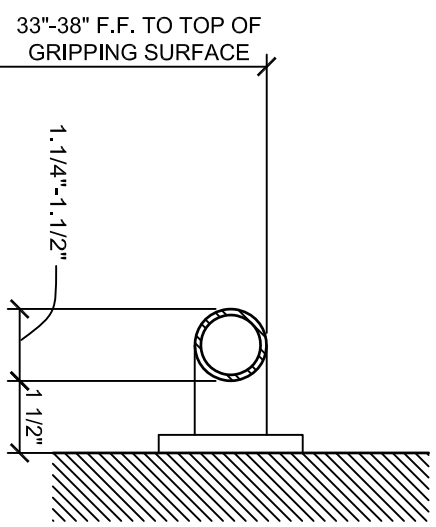

H
A3.1


GRAB BAR

SCALE: 3" = 1'-0"

M
A3.1

ROOM SIGN



N.T.S.

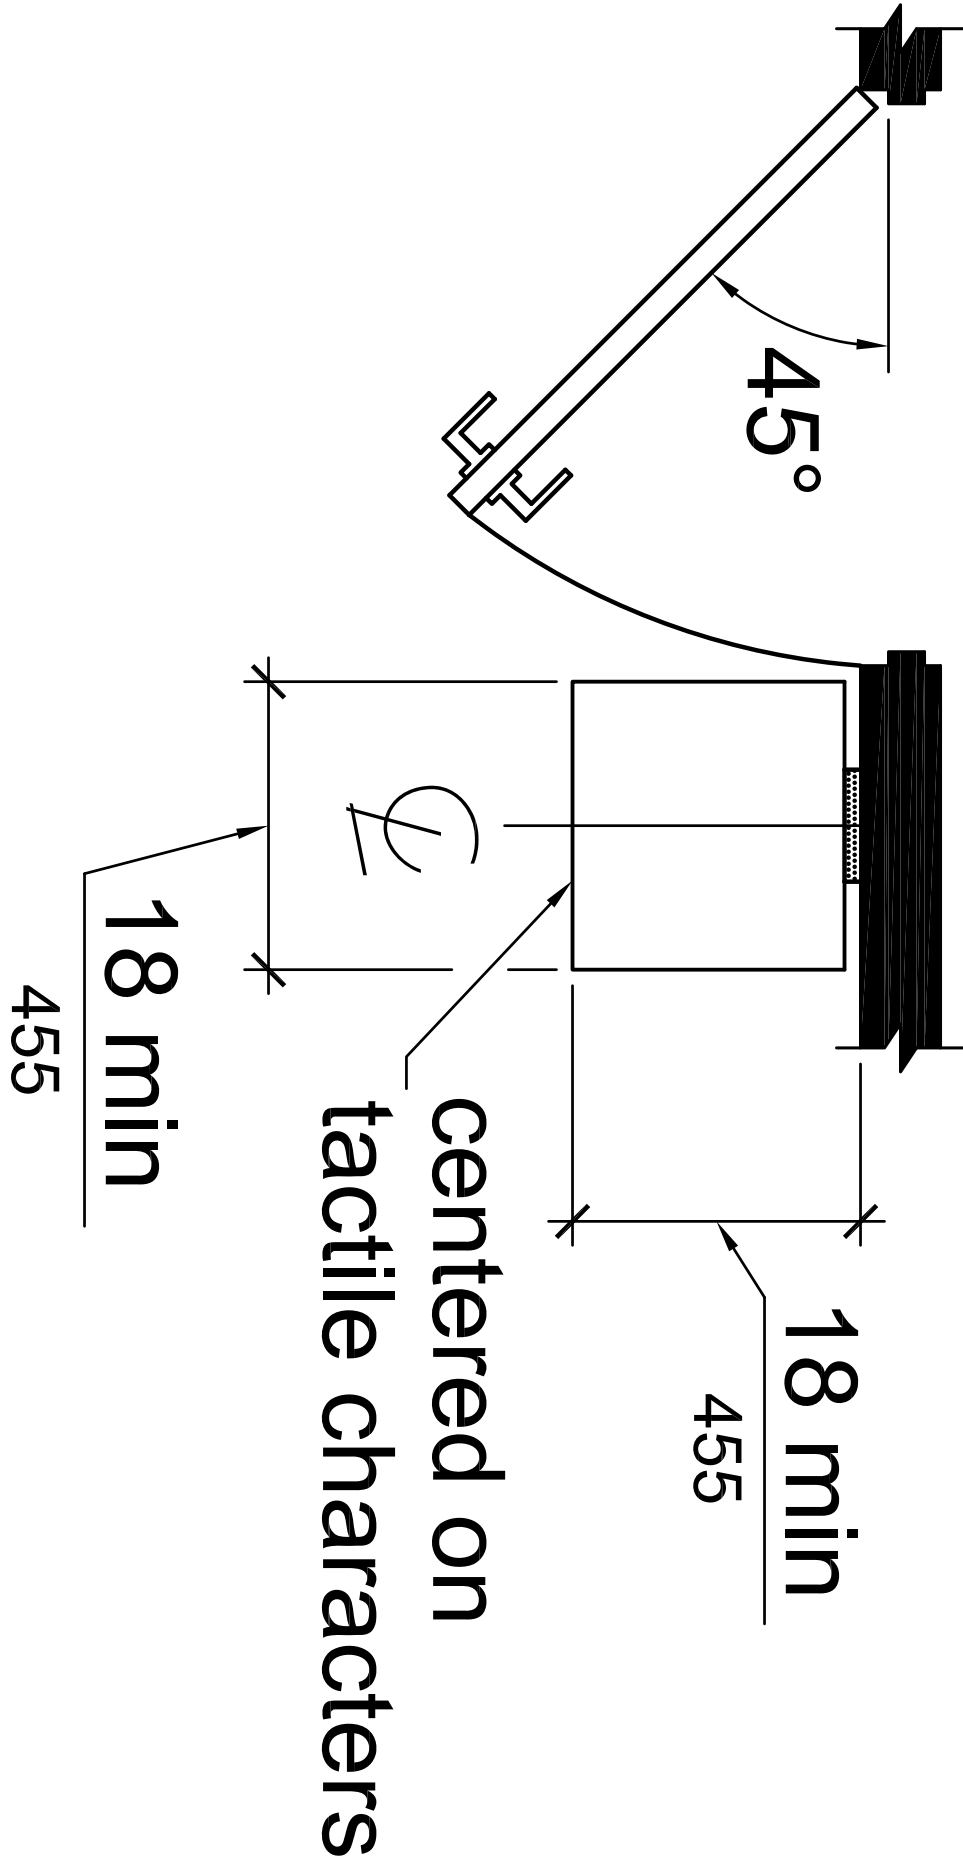

L
A3.1





ROOM SIGN

N.T.S.

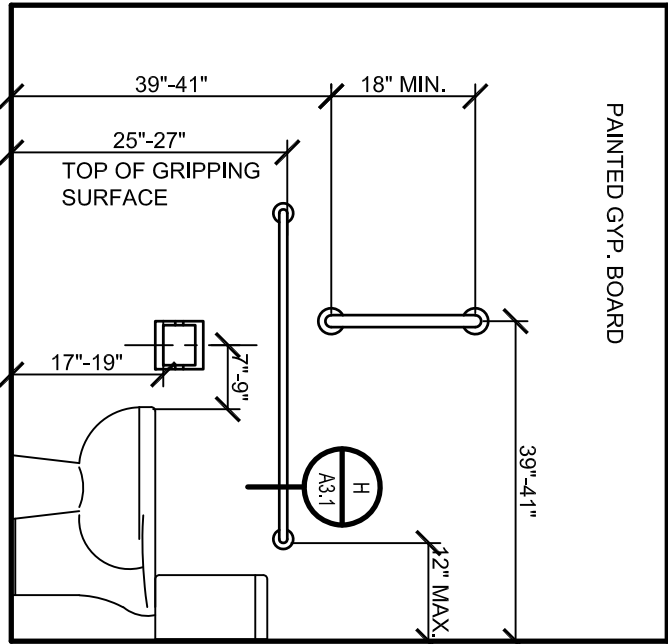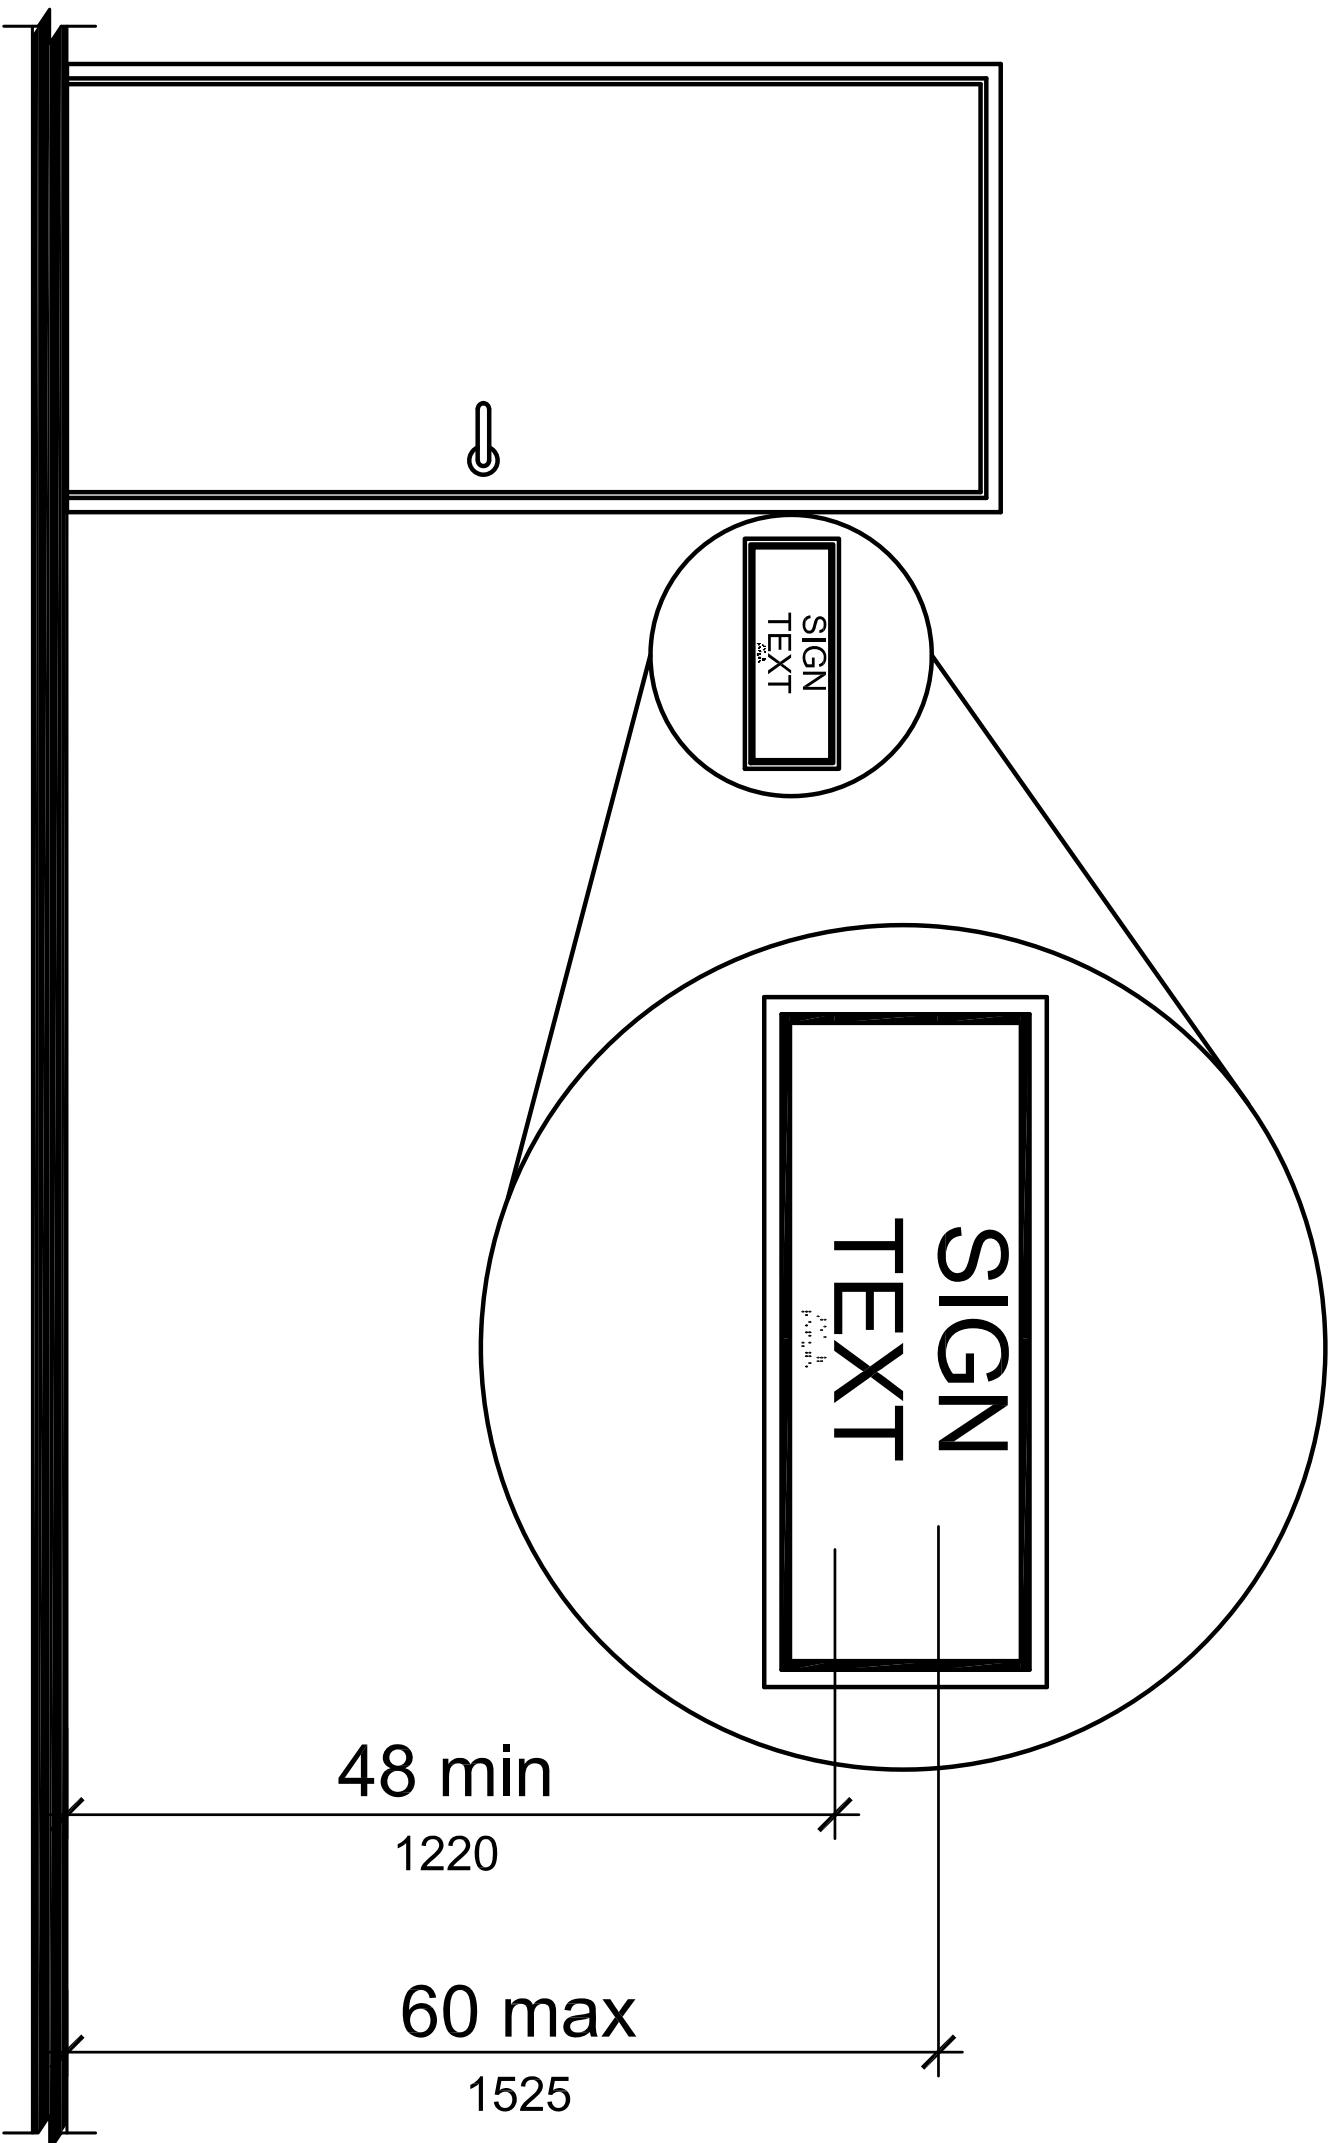


TOILET B03

 SCALE: 1/2" = 1'-0"

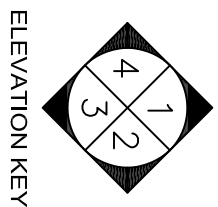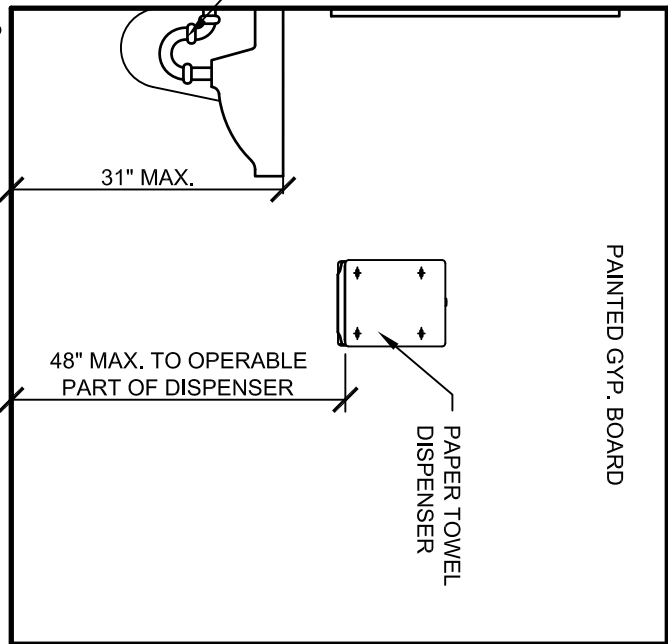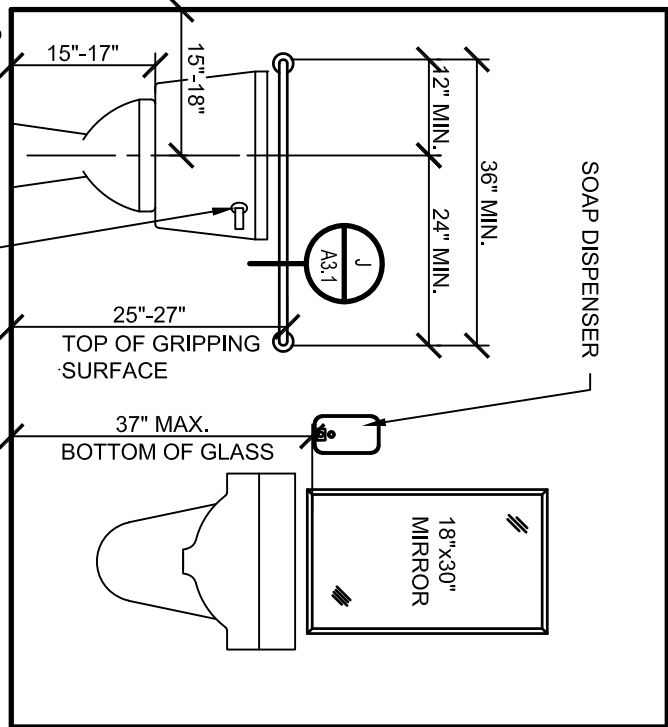

ELEVATION KEY

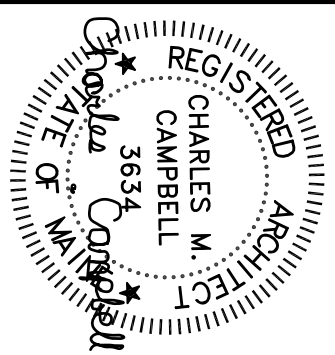

Chuck Campbell Architect PLLC
127 UNION ROAD
Waldoboro, Maine 04572
TEL (207)557-0448
e-mail chuck@chuckcampbellarchitect.com




PROJECT:
FRIENDSHIP LIBRARY
3 MAINE STREET
FRIENDSHIP, MAINE

NO.	REVISIONS	DATE

SHEET TITLE:
INTERIOR ELEVATIONS
SCALE: AS INDICATED
DATE: AUGUST 13, 2026

PROJ. ID: FRIENDSHIP

A3.2

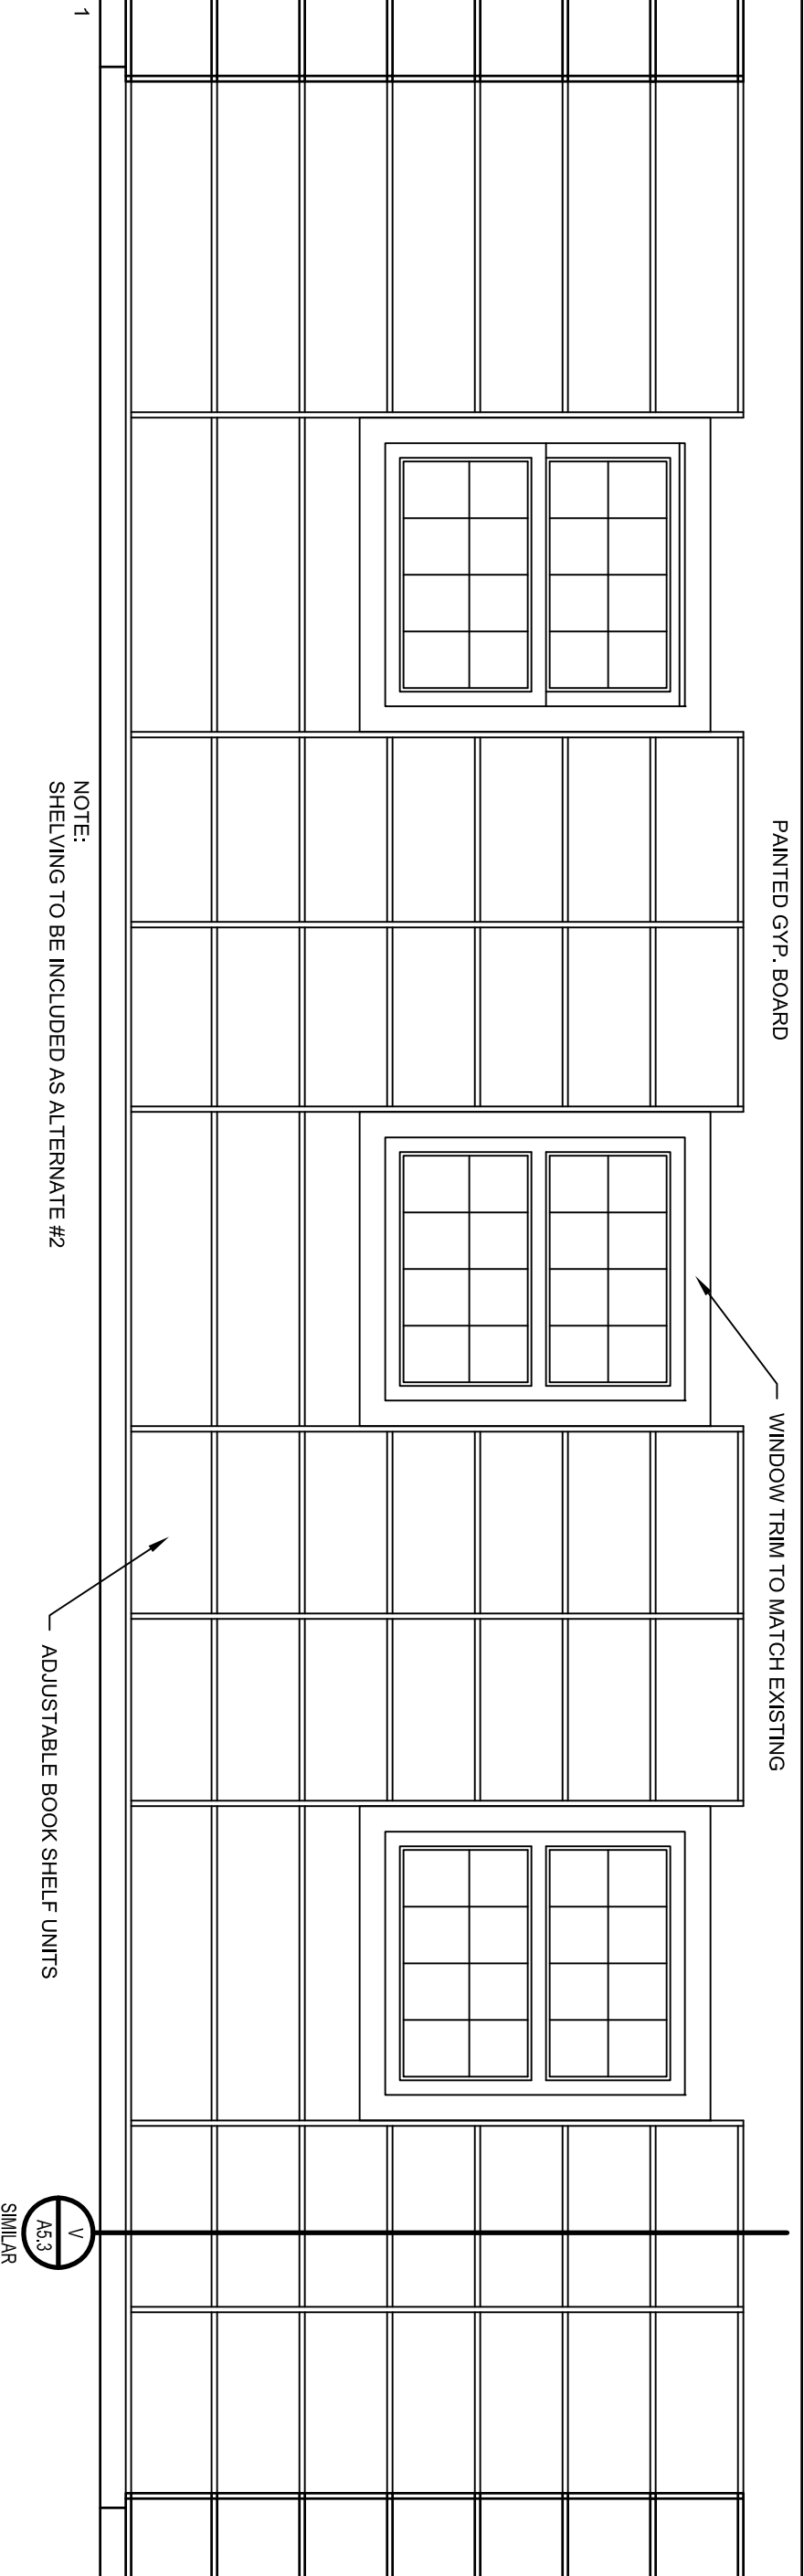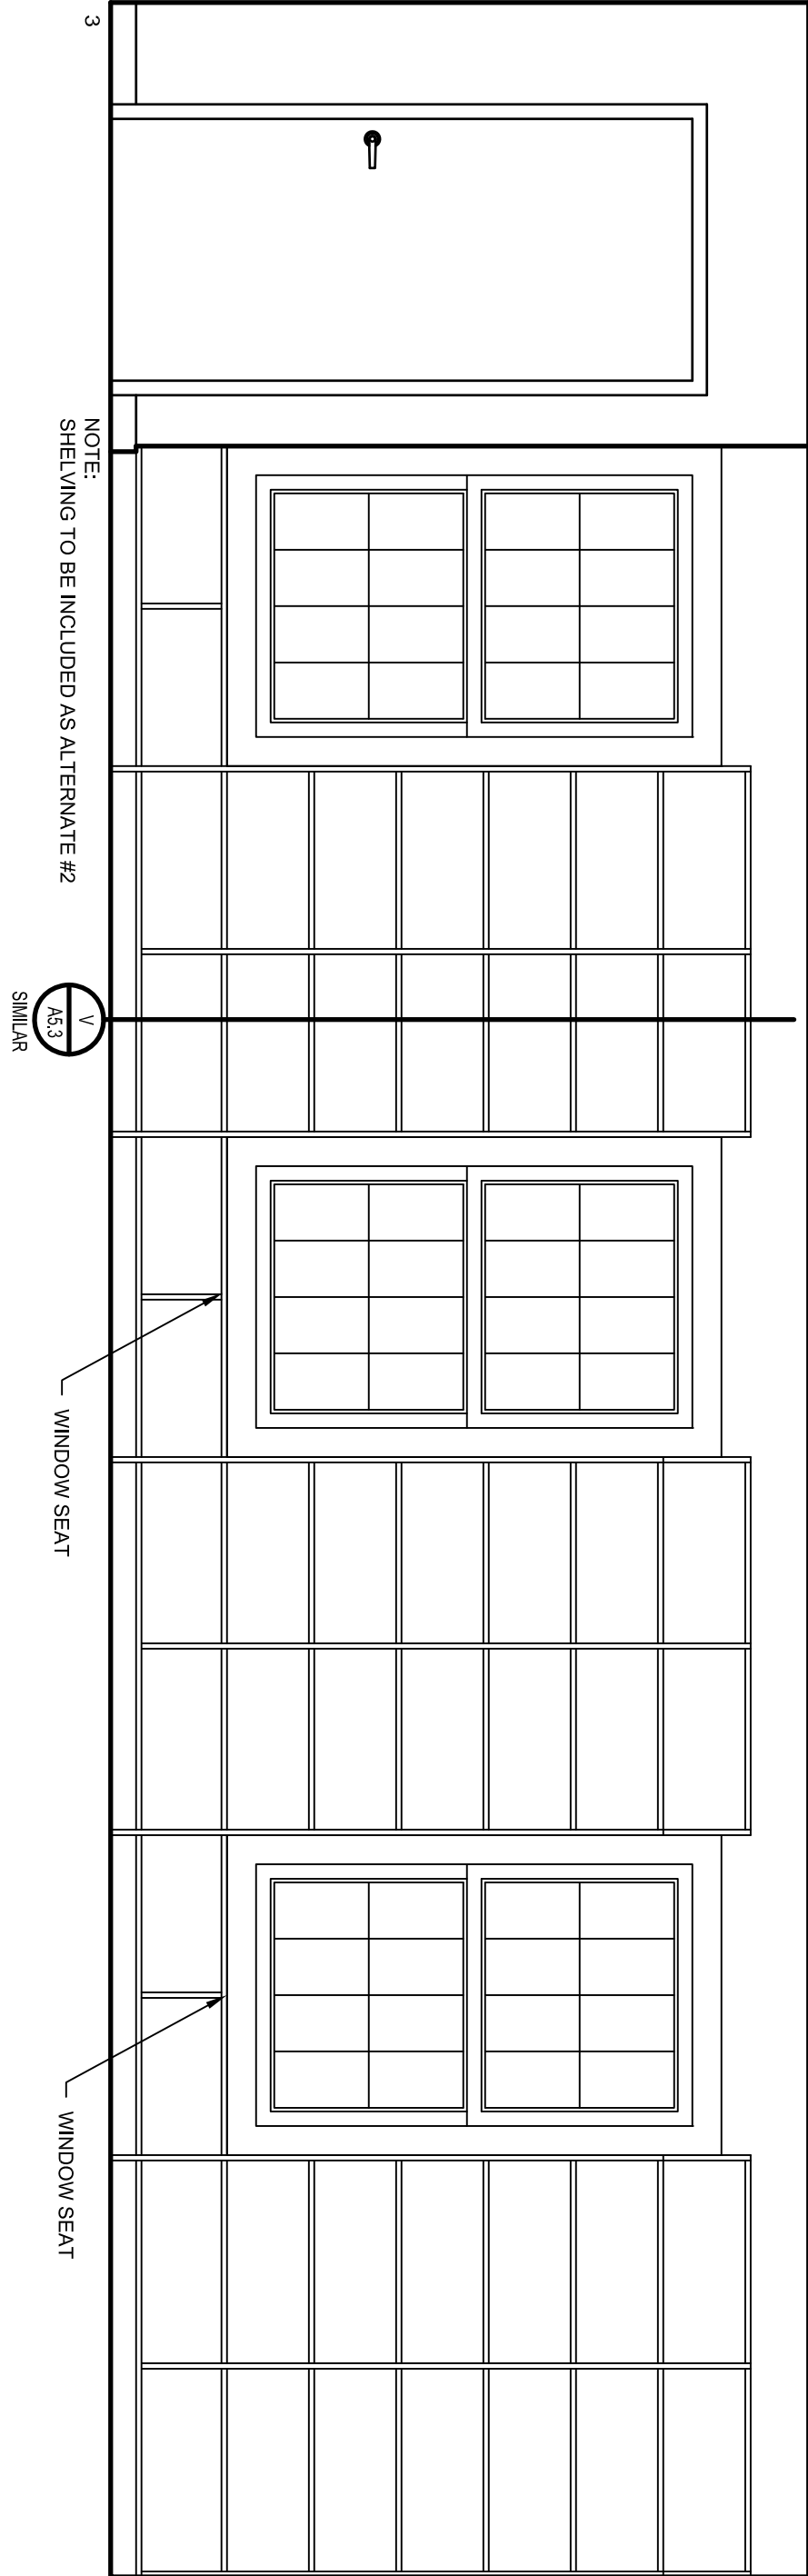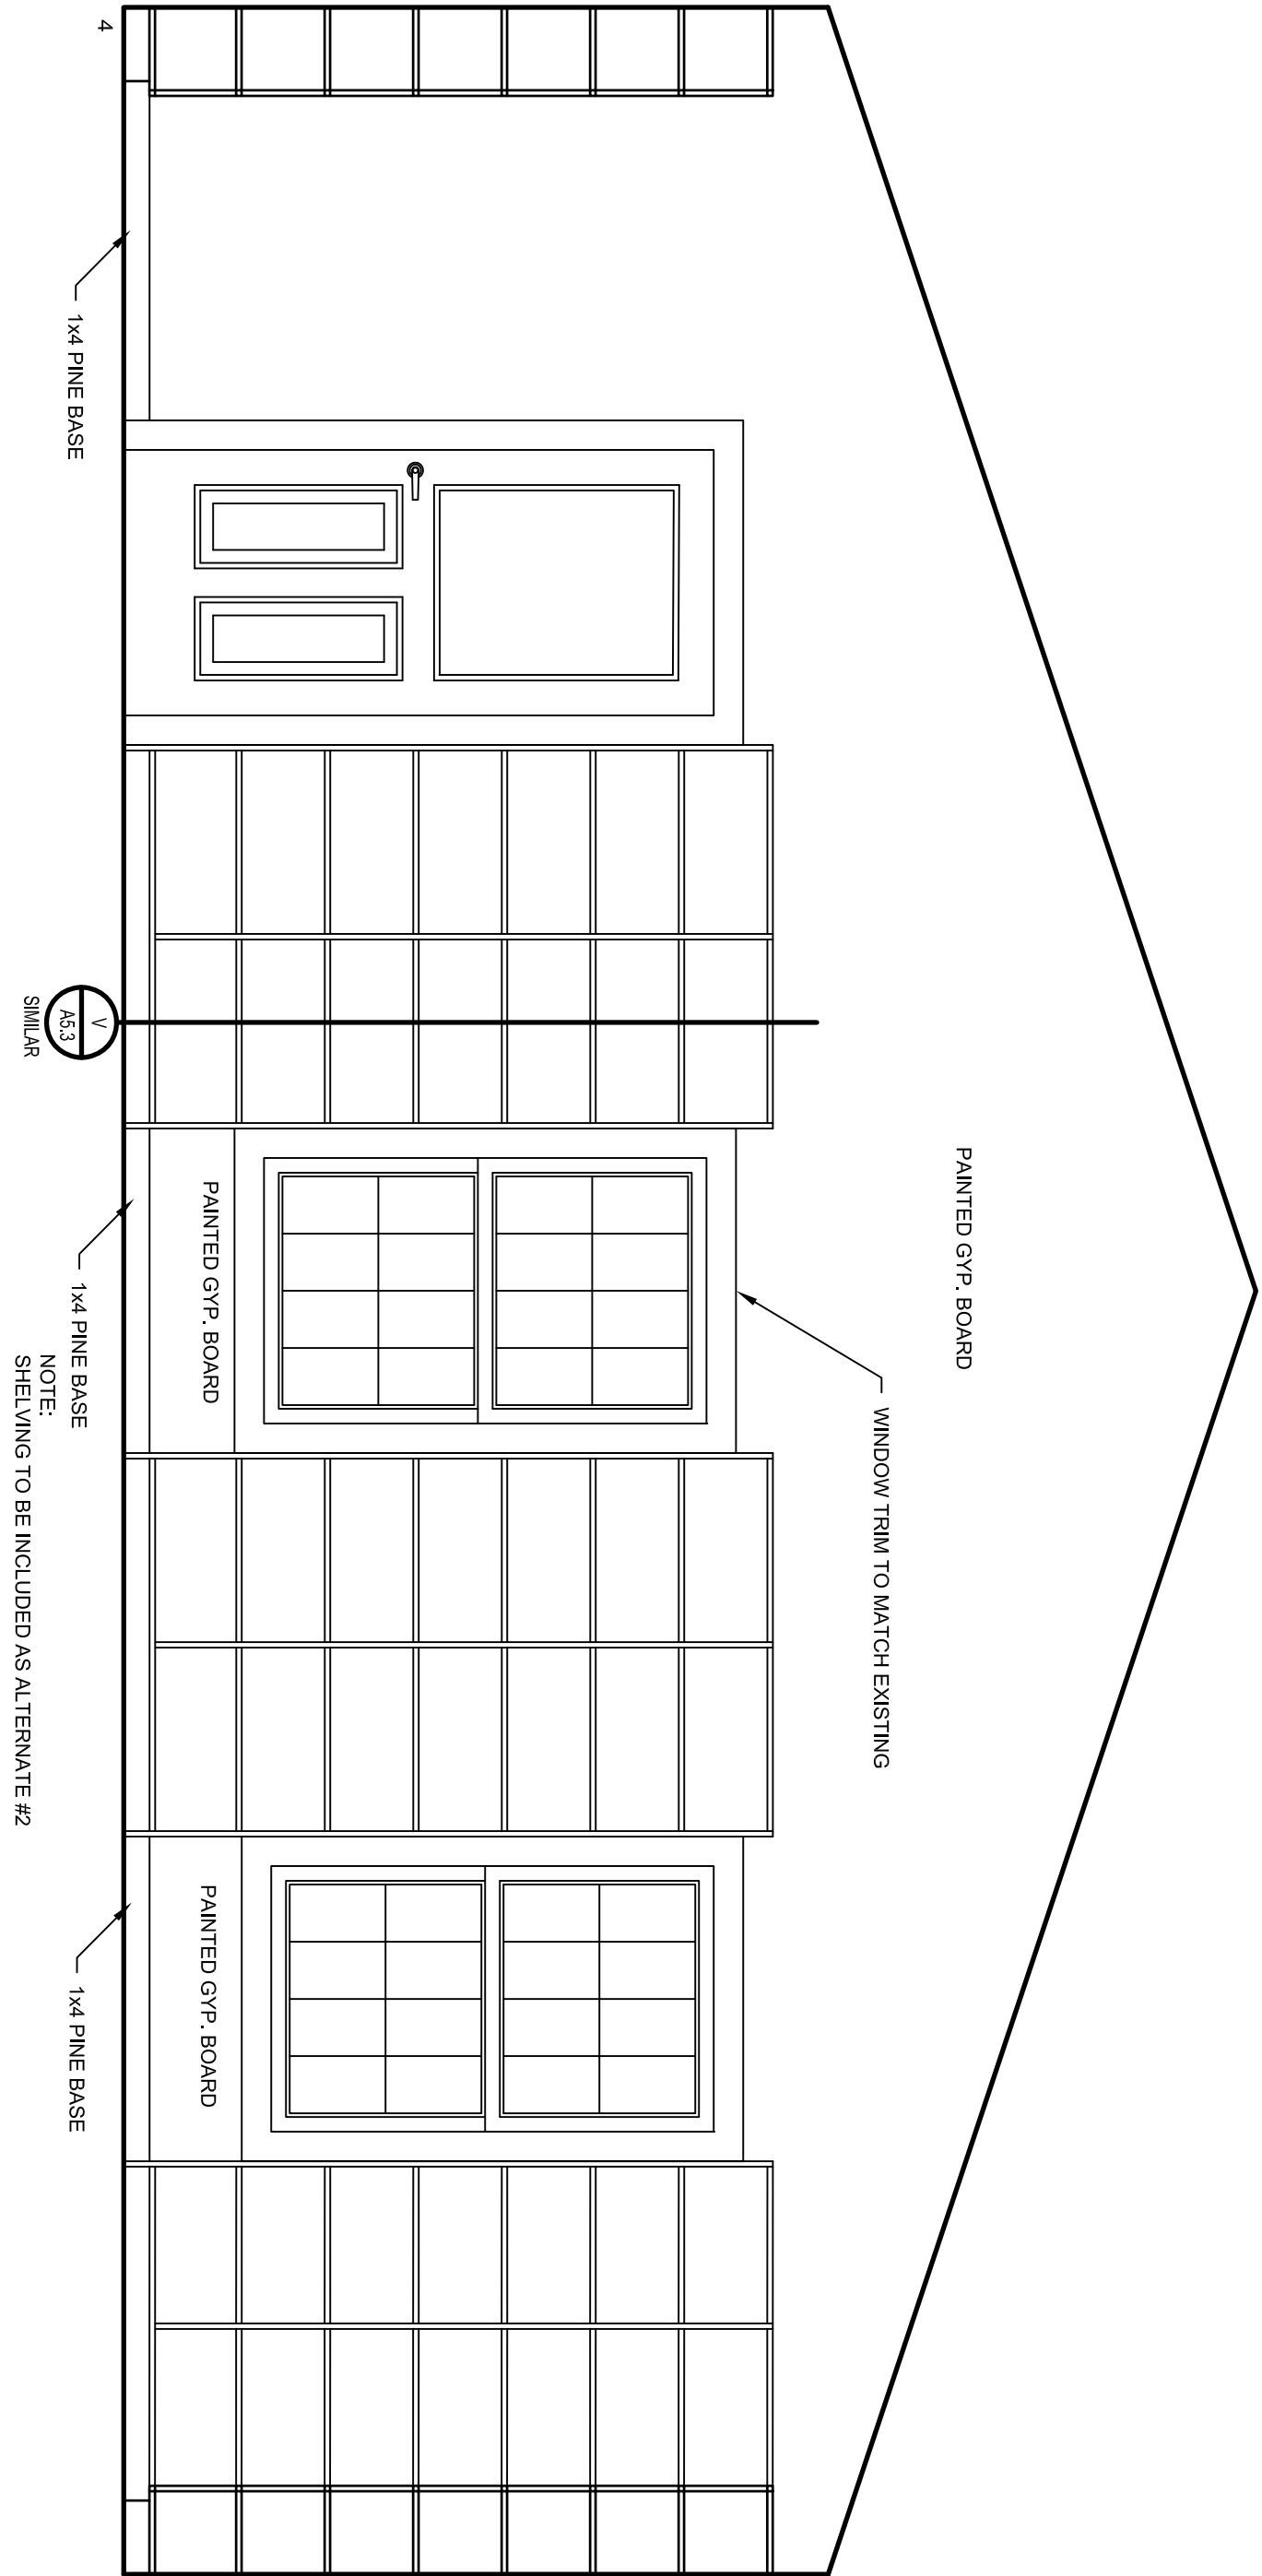

LIBRARY 2 ELEVATIONS
SCALE: 1/2" = 1'-0"
ELEVATION KEY

PAINTED GYP. BOARD

PAINTED GYP. BOARD

PAINTED GYP. BOARD

PAINTED GYP. BOARD

PAINTED GYP. BOARD

OPENING TO EXISTING LIBRARY

NOTE:
SHELVING TO BE INCLUDED AS ALTERNATE #2

NOTE:
SHELVING TO BE INCLUDED AS ALTERNATE #2


WINDOW SEAT

WINDOW SEAT

PAINTED GYP. BOARD

WINDOW TRIM TO MATCH EXISTING

ADJUSTABLE BOOK SHELF UNITS

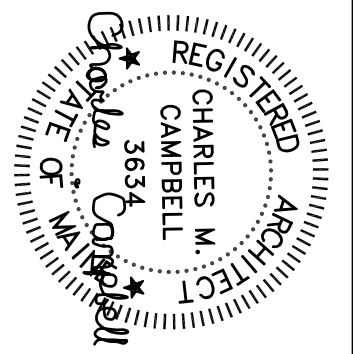

Chuck Campbell Architect PLLC
127 UNION ROAD
Waldoboro, Maine 04572
TEL (207)557-0448
e-mail chuck@chuckcampbellarchitect.com

PROJECT:
FRIENDSHIP LIBRARY


ADDRESS:
**3 MAINE STREET
FRIENDSHIP, MAINE**

NO.	REVISIONS	DATE


SHEET TITLE: EXISTING ELEVATIONS	
SCALE: AS INDICATED	
DATE: AUGUST 13, 2026	

PROJ. ID.: FRIENDSHIP


A4.1

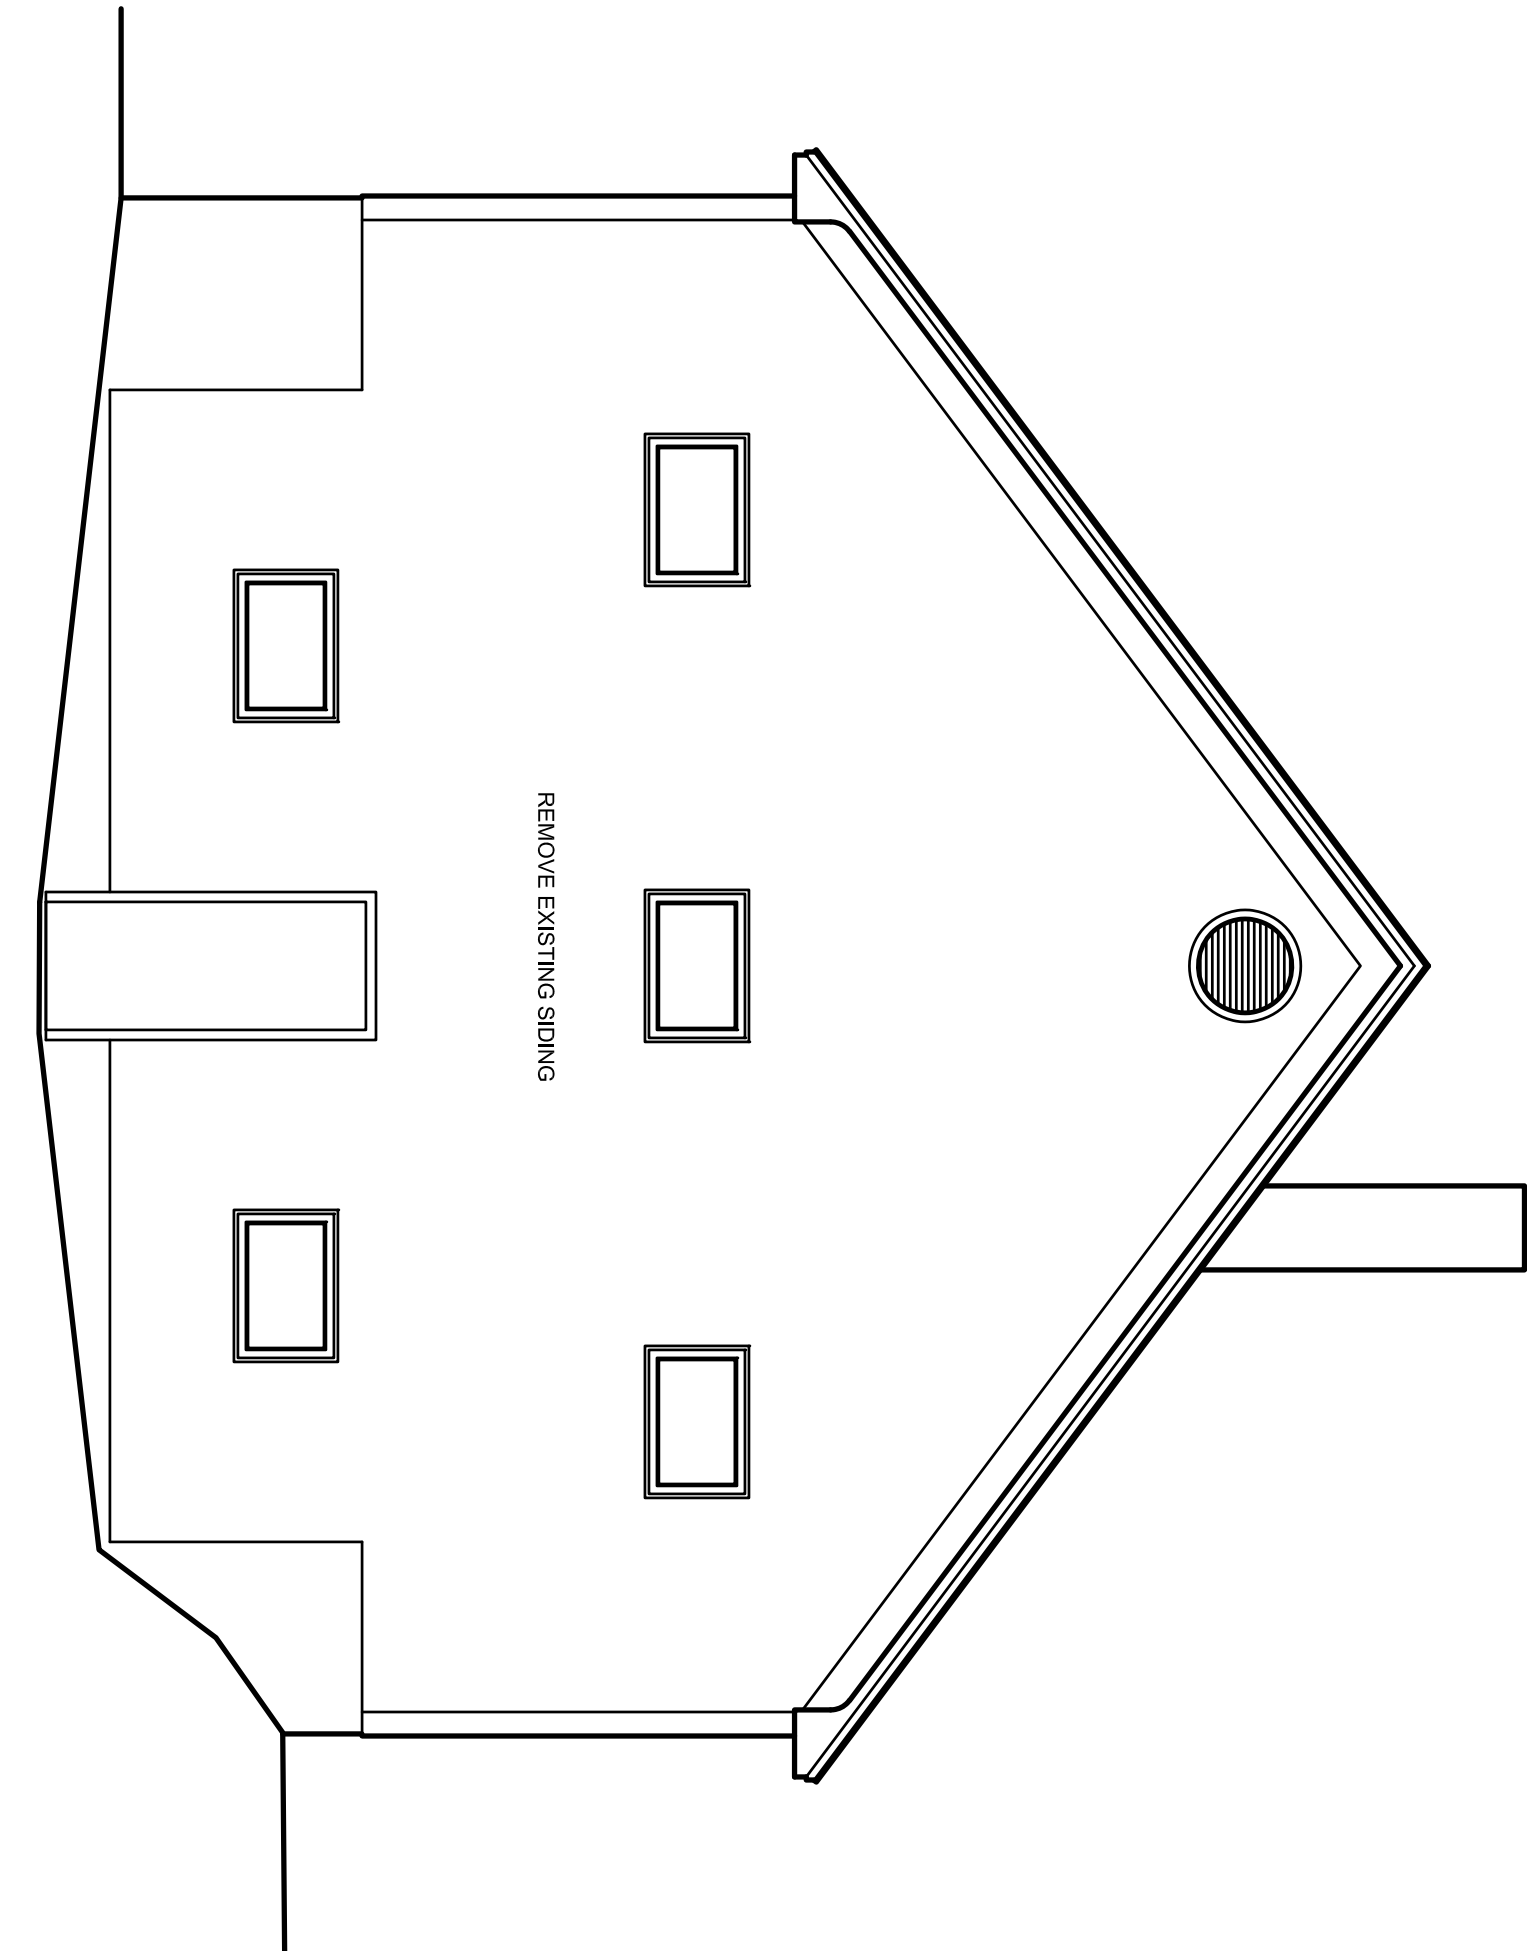


EAST ELEVATION

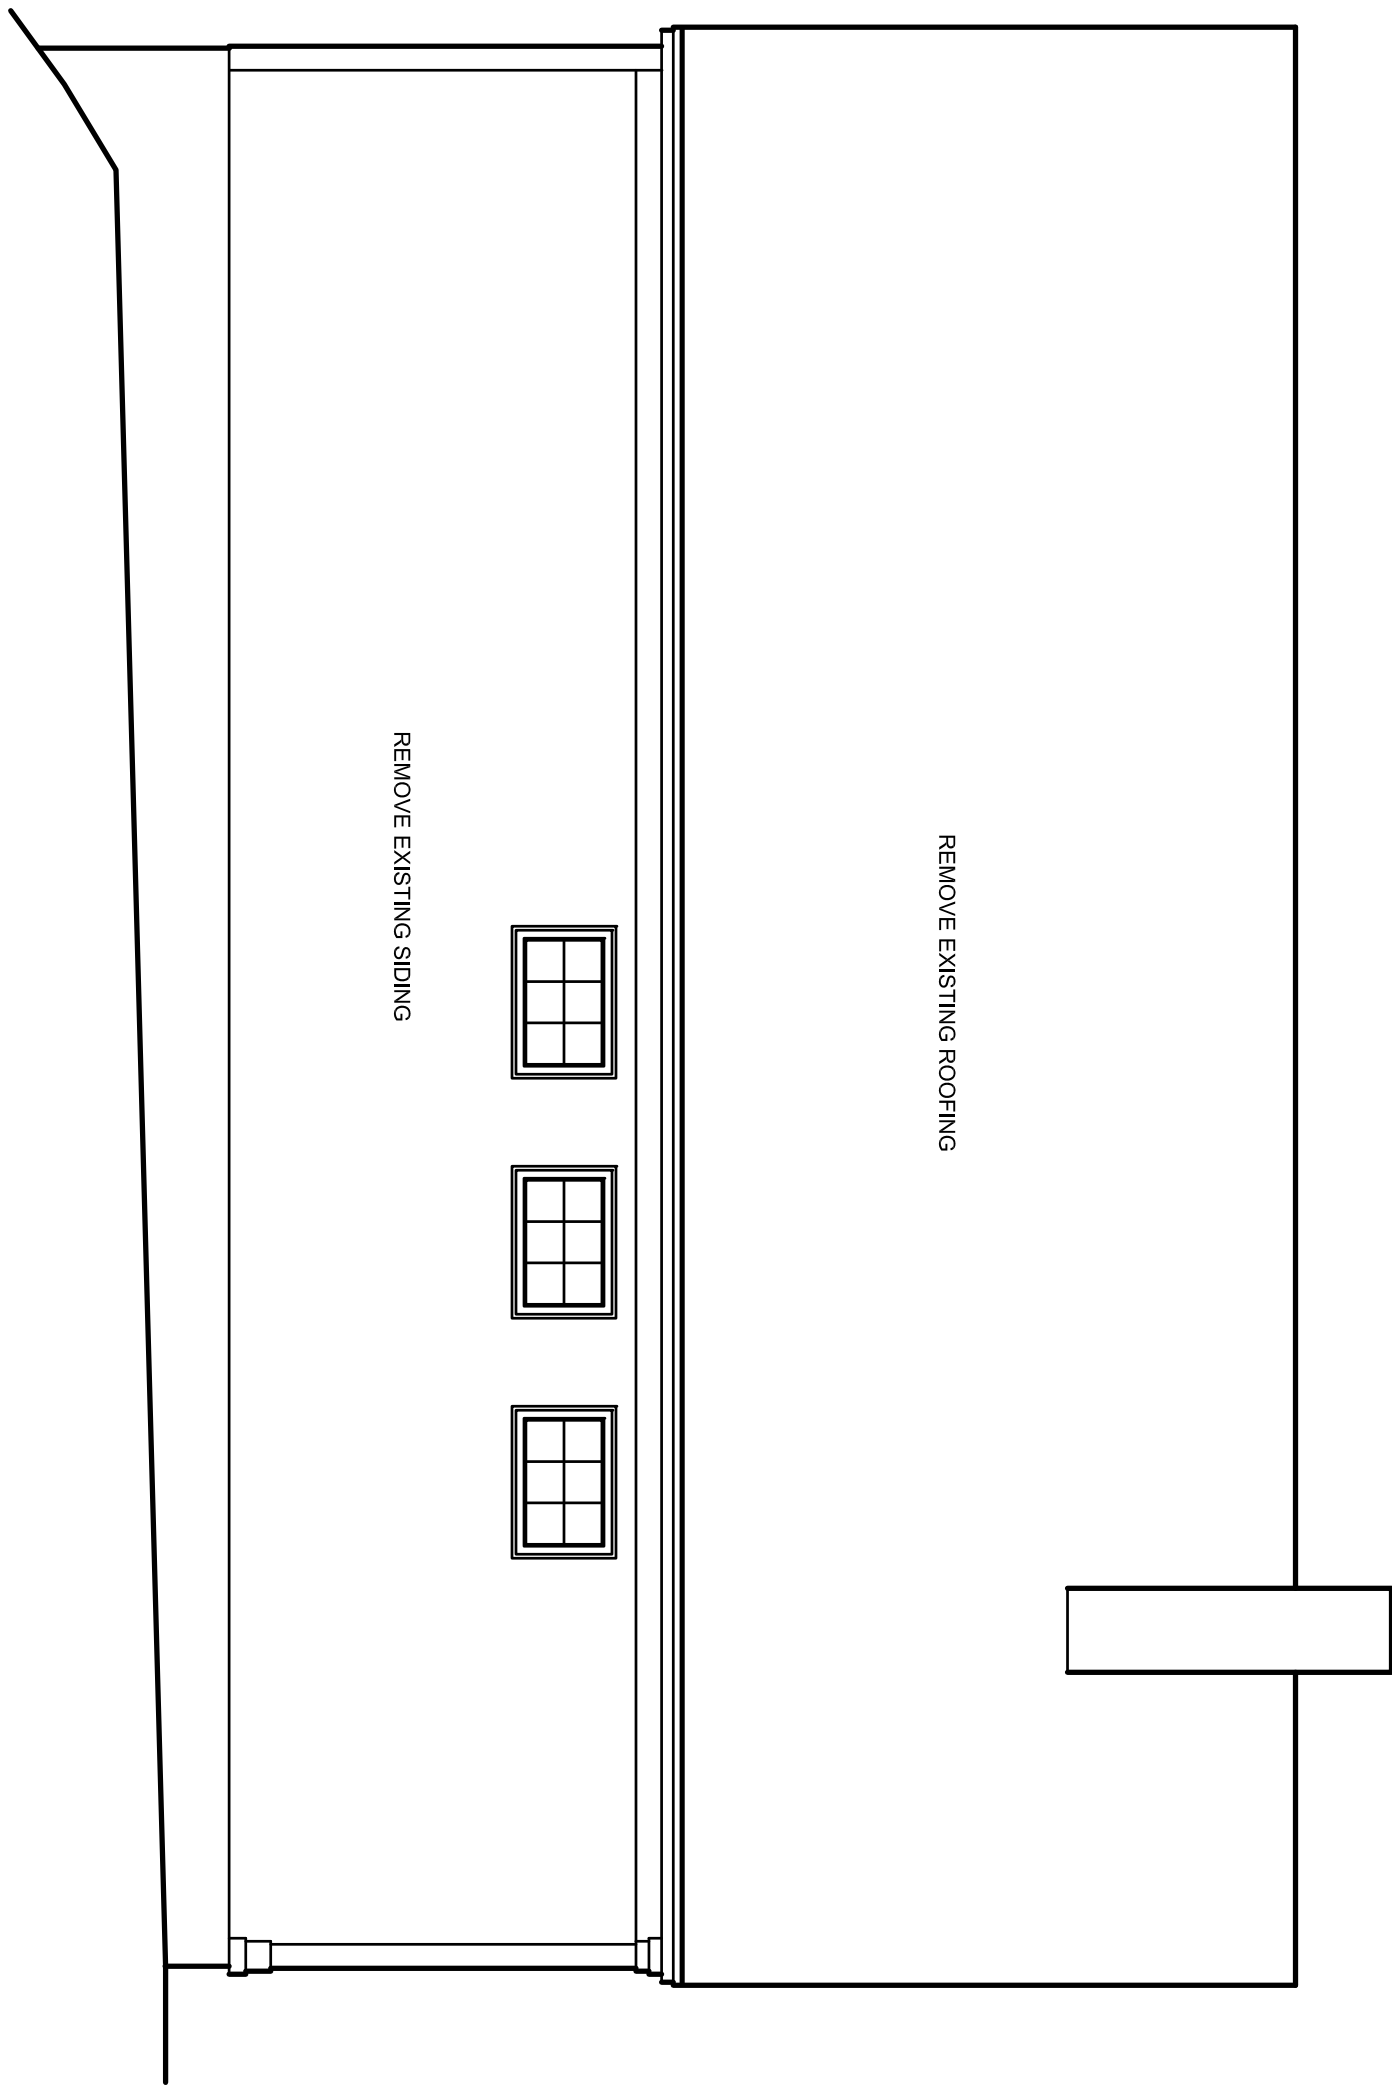

NORTH ELEVATION

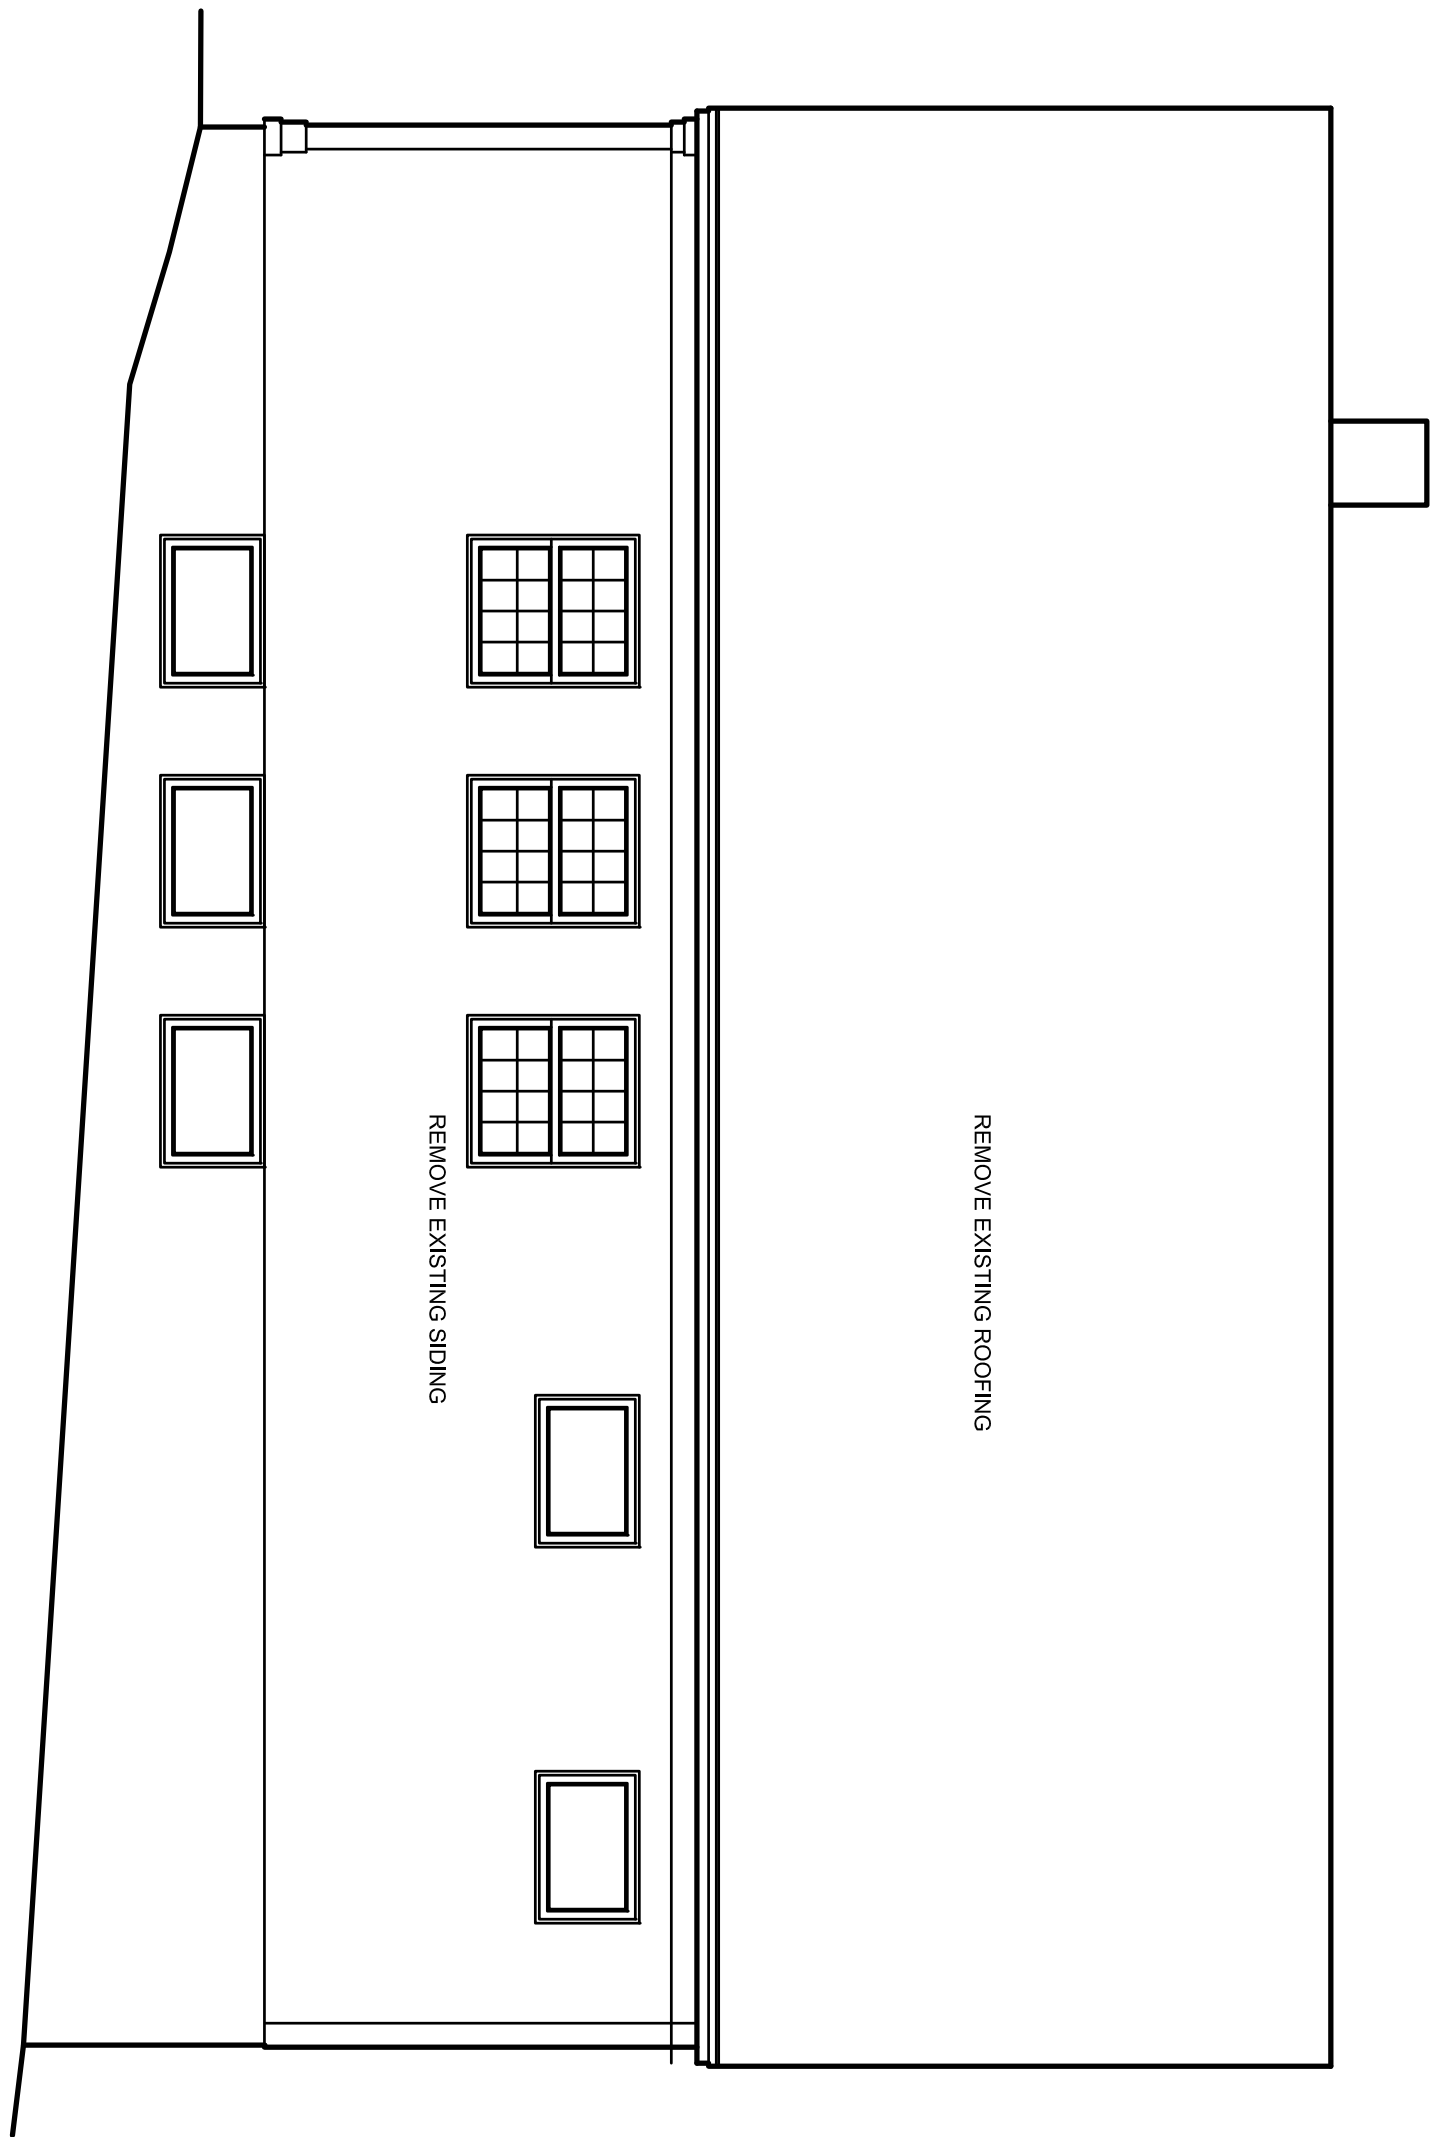


SOUTH ELEVATION

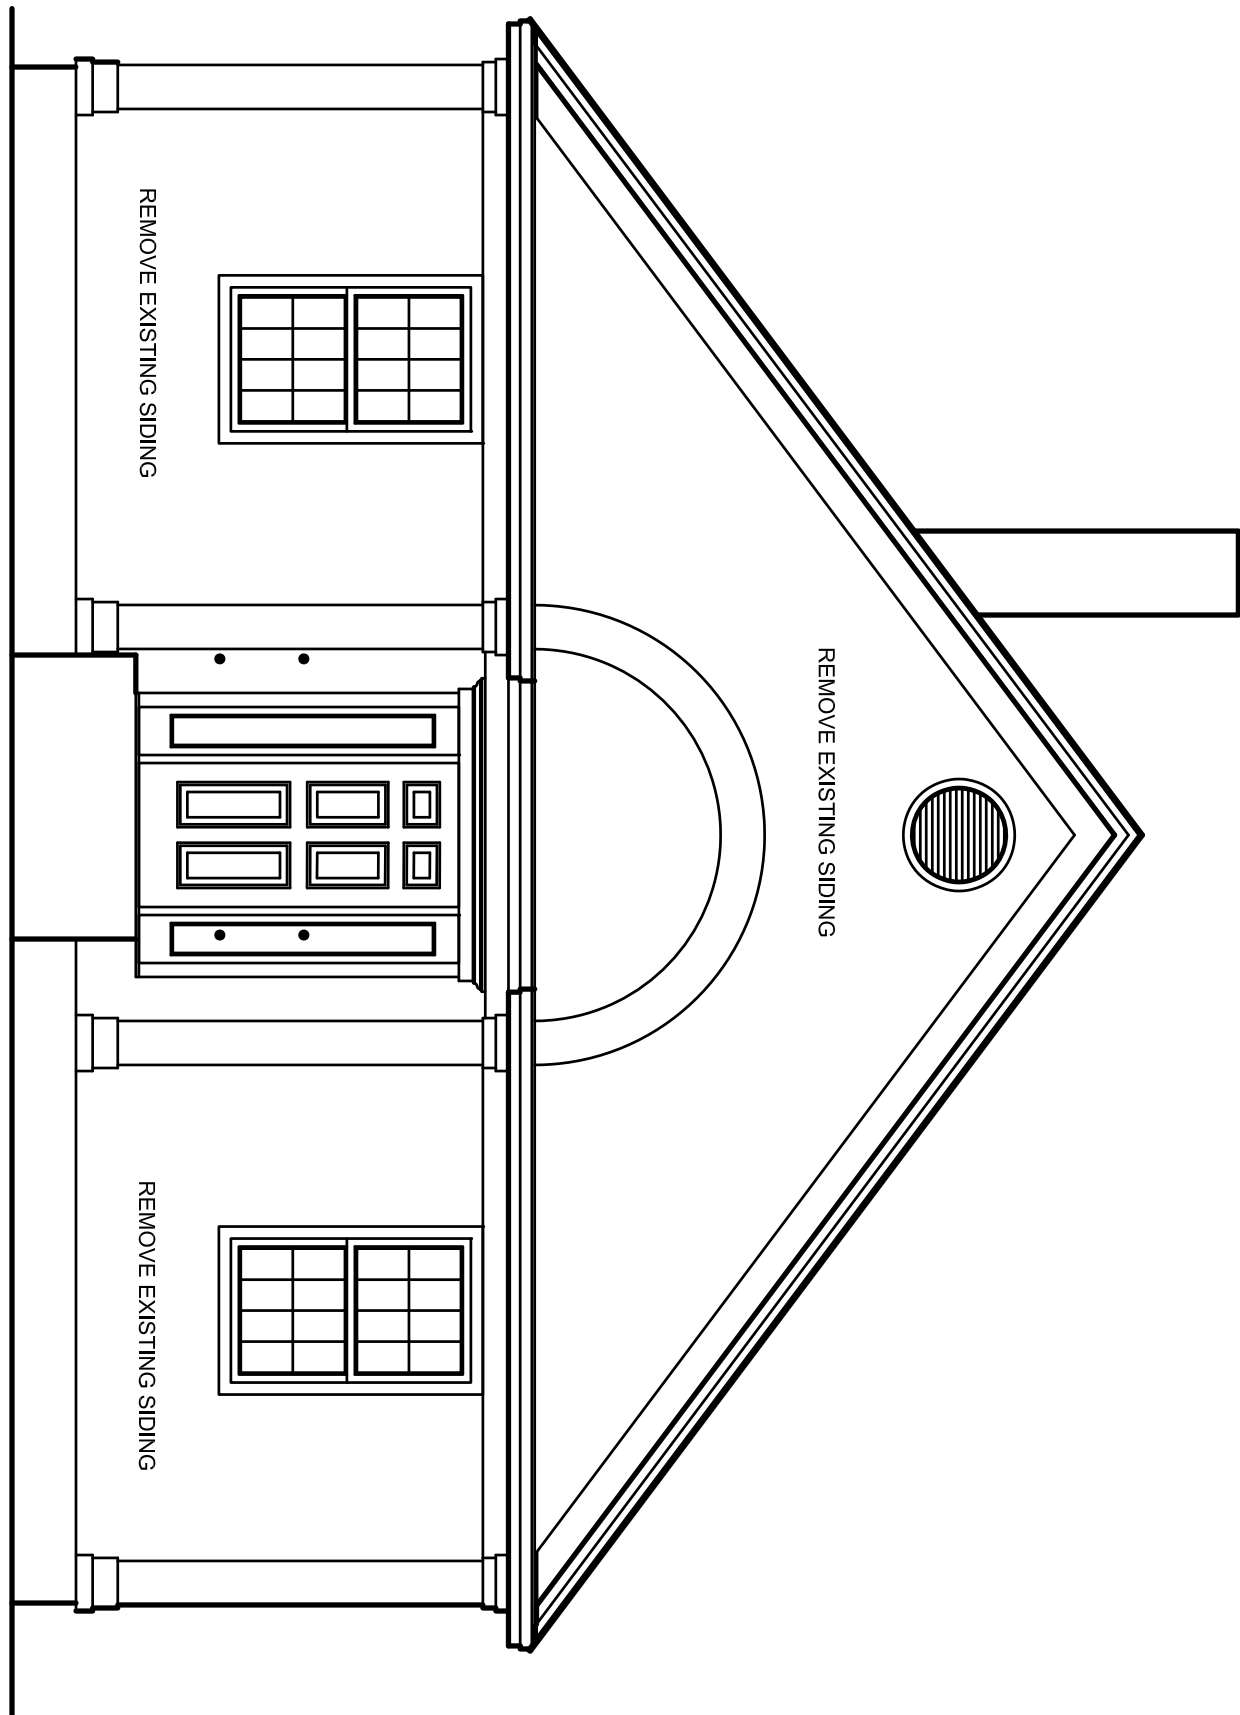

WEST ELEVATION




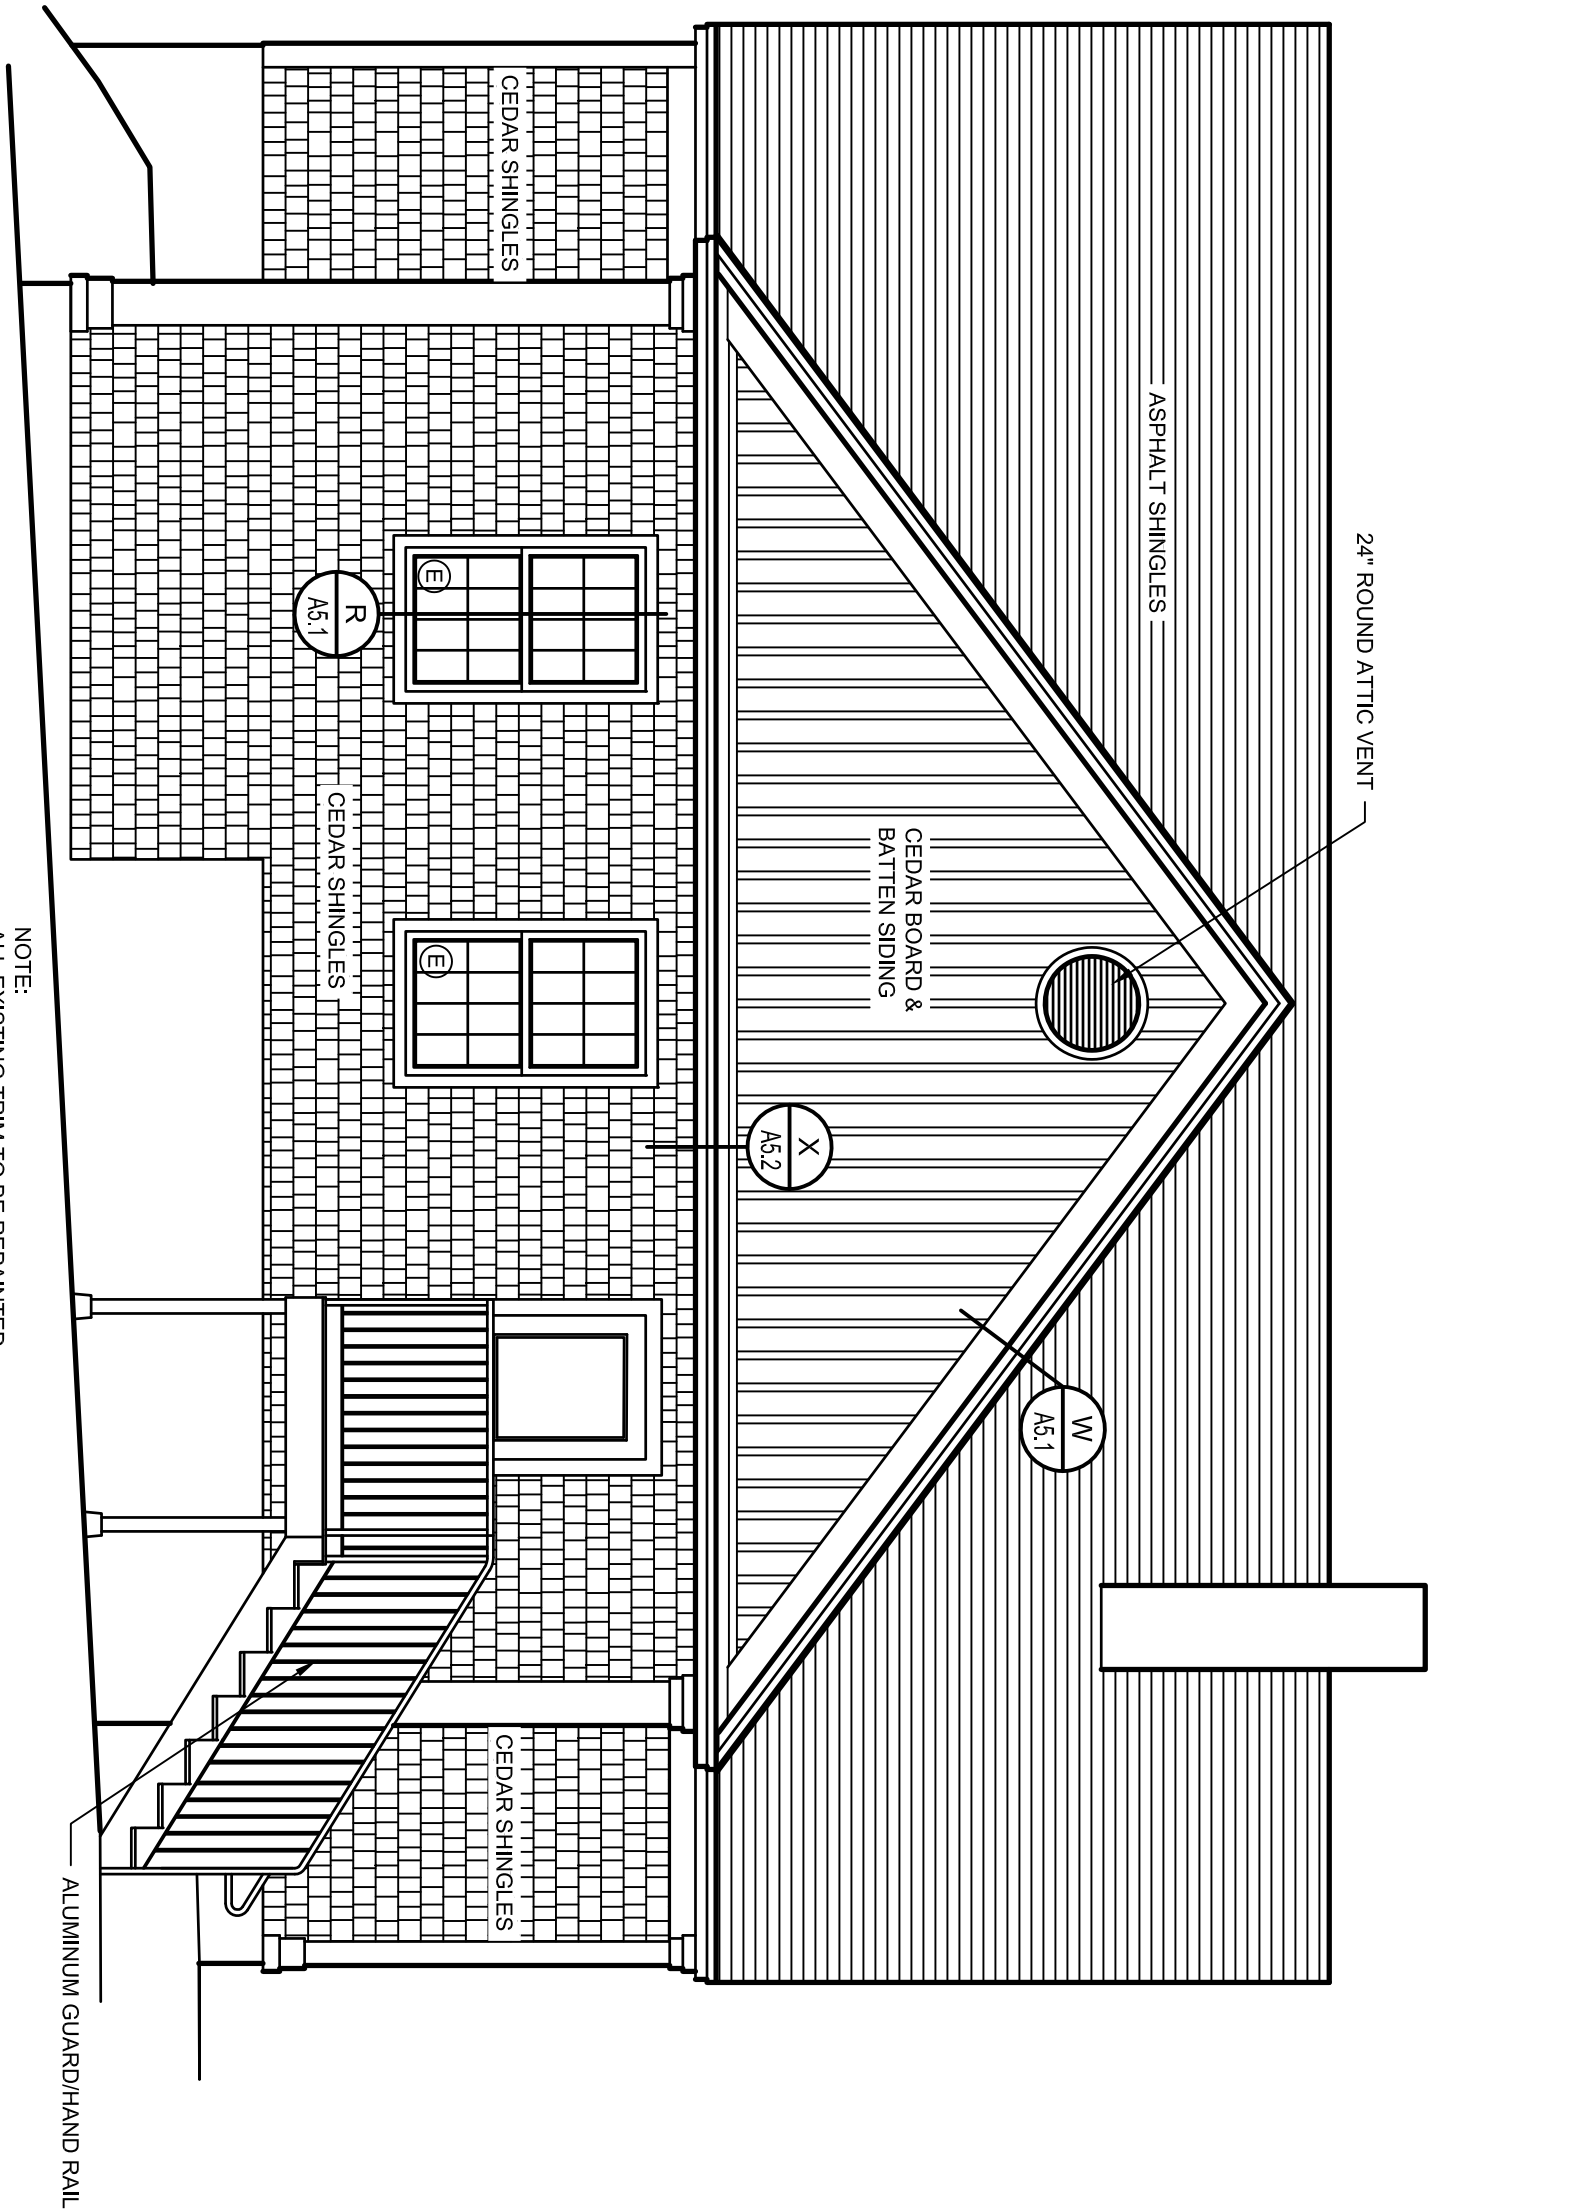


NOTE:
ALL EXISTING TRIM TO BE REPAINTED

NORTH ELEVATION

PROPOSED

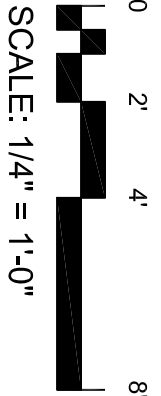


SCALE: 1/4" = 1'-0"

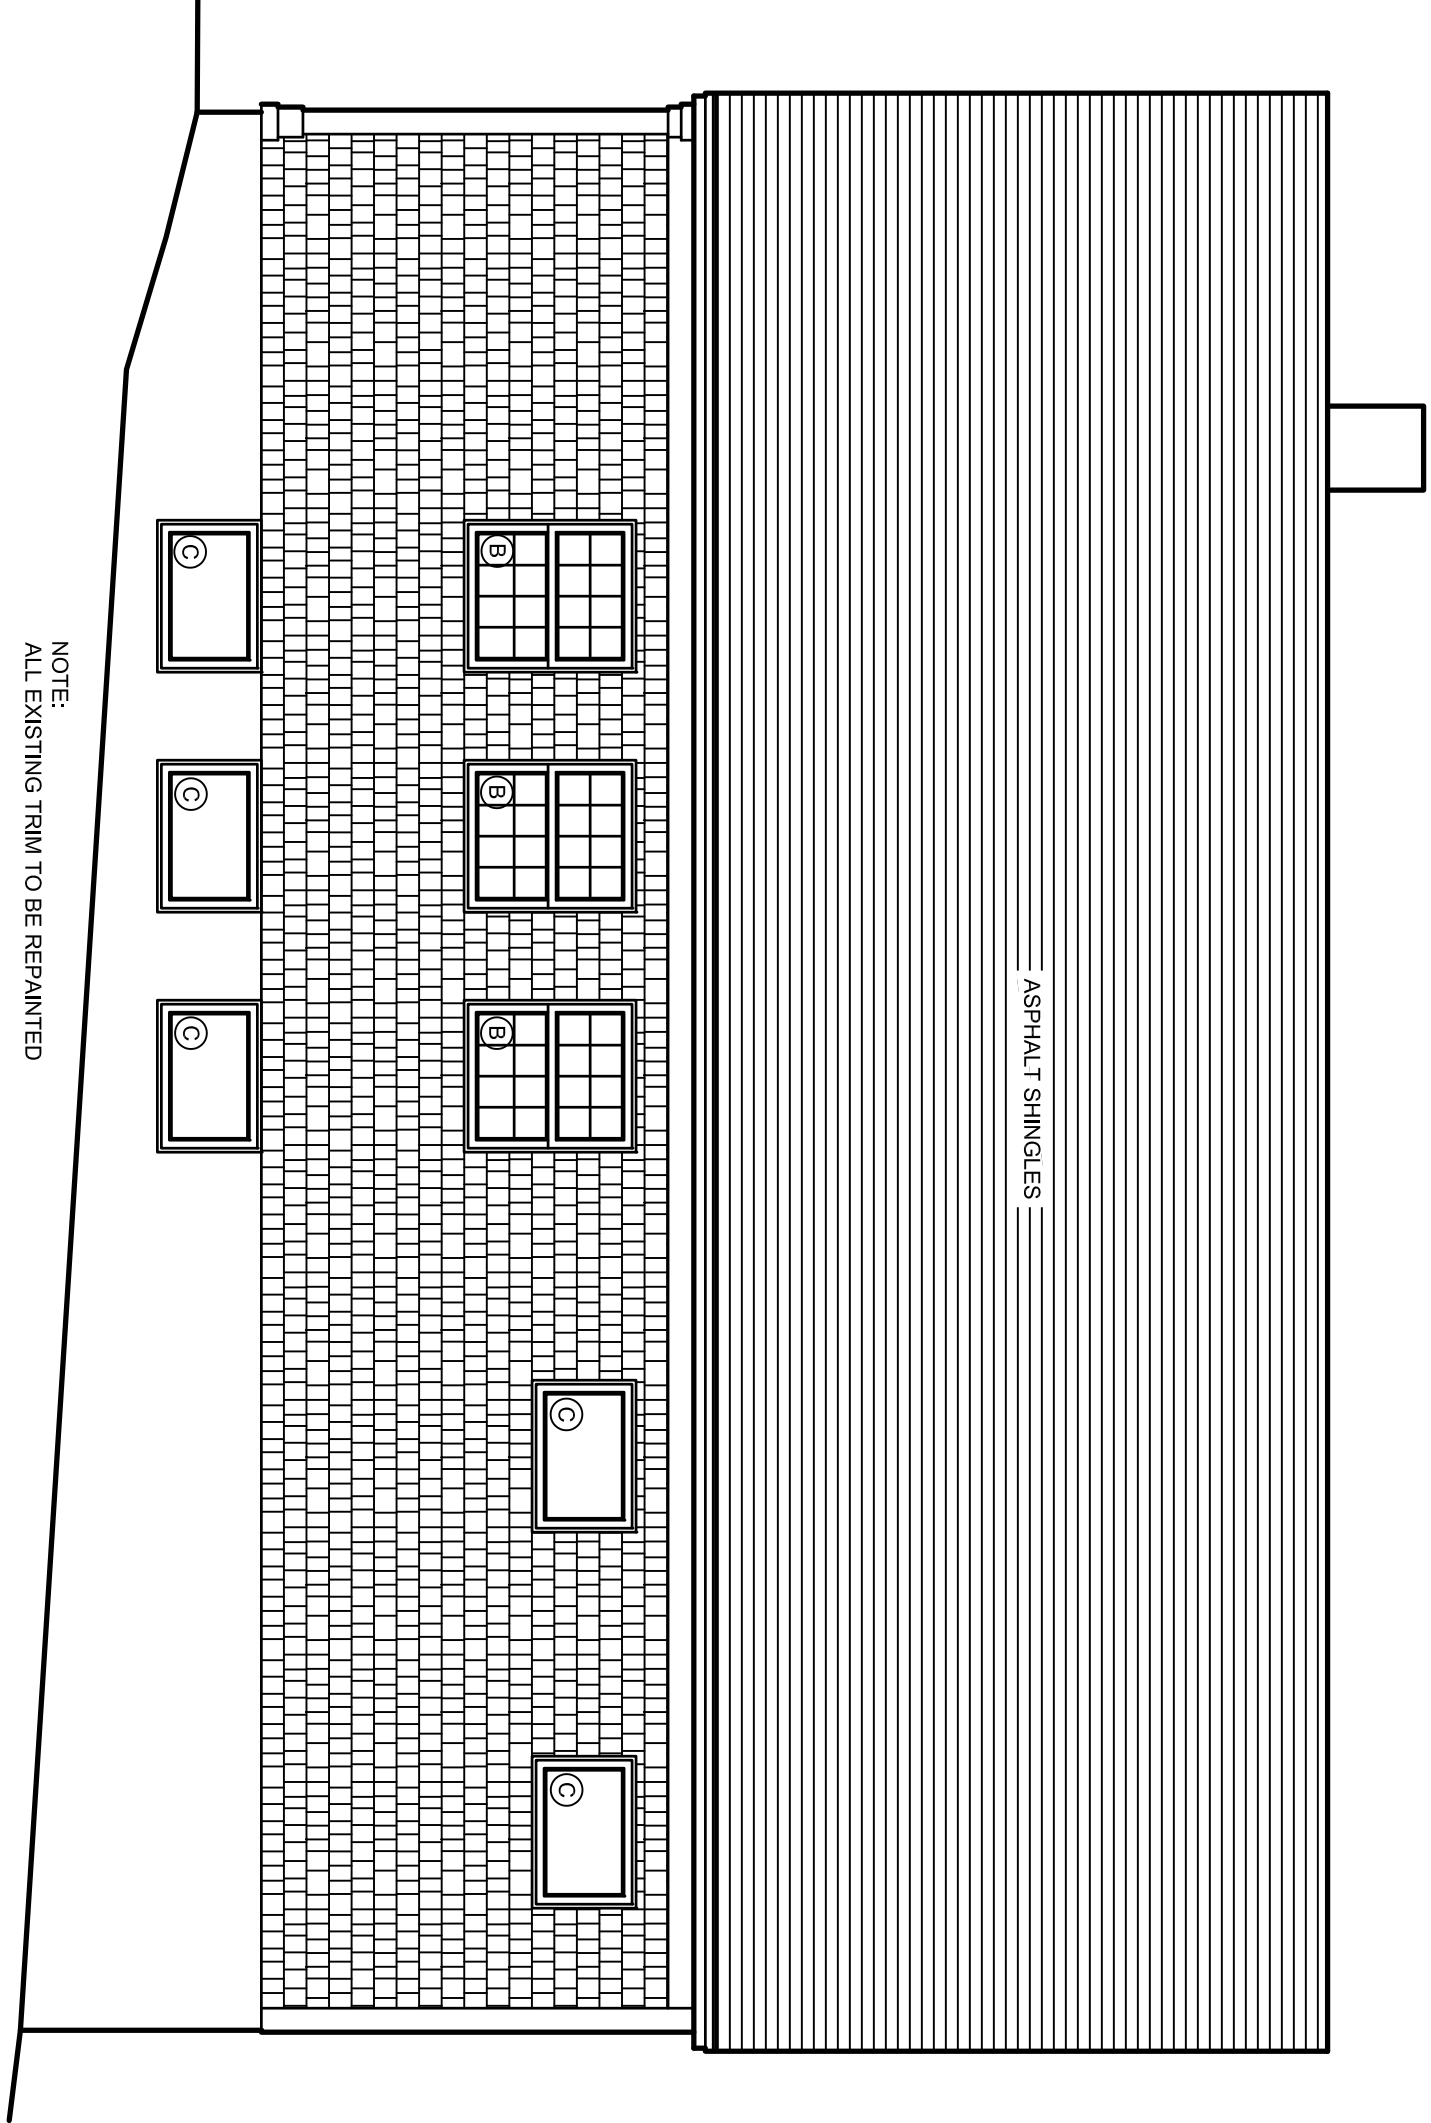


NOTE:
ALL EXISTING TRIM TO BE REPAINTED

SOUTH ELEVATION

 PROPOSED




SCALE: 1/4" = 1'-0"

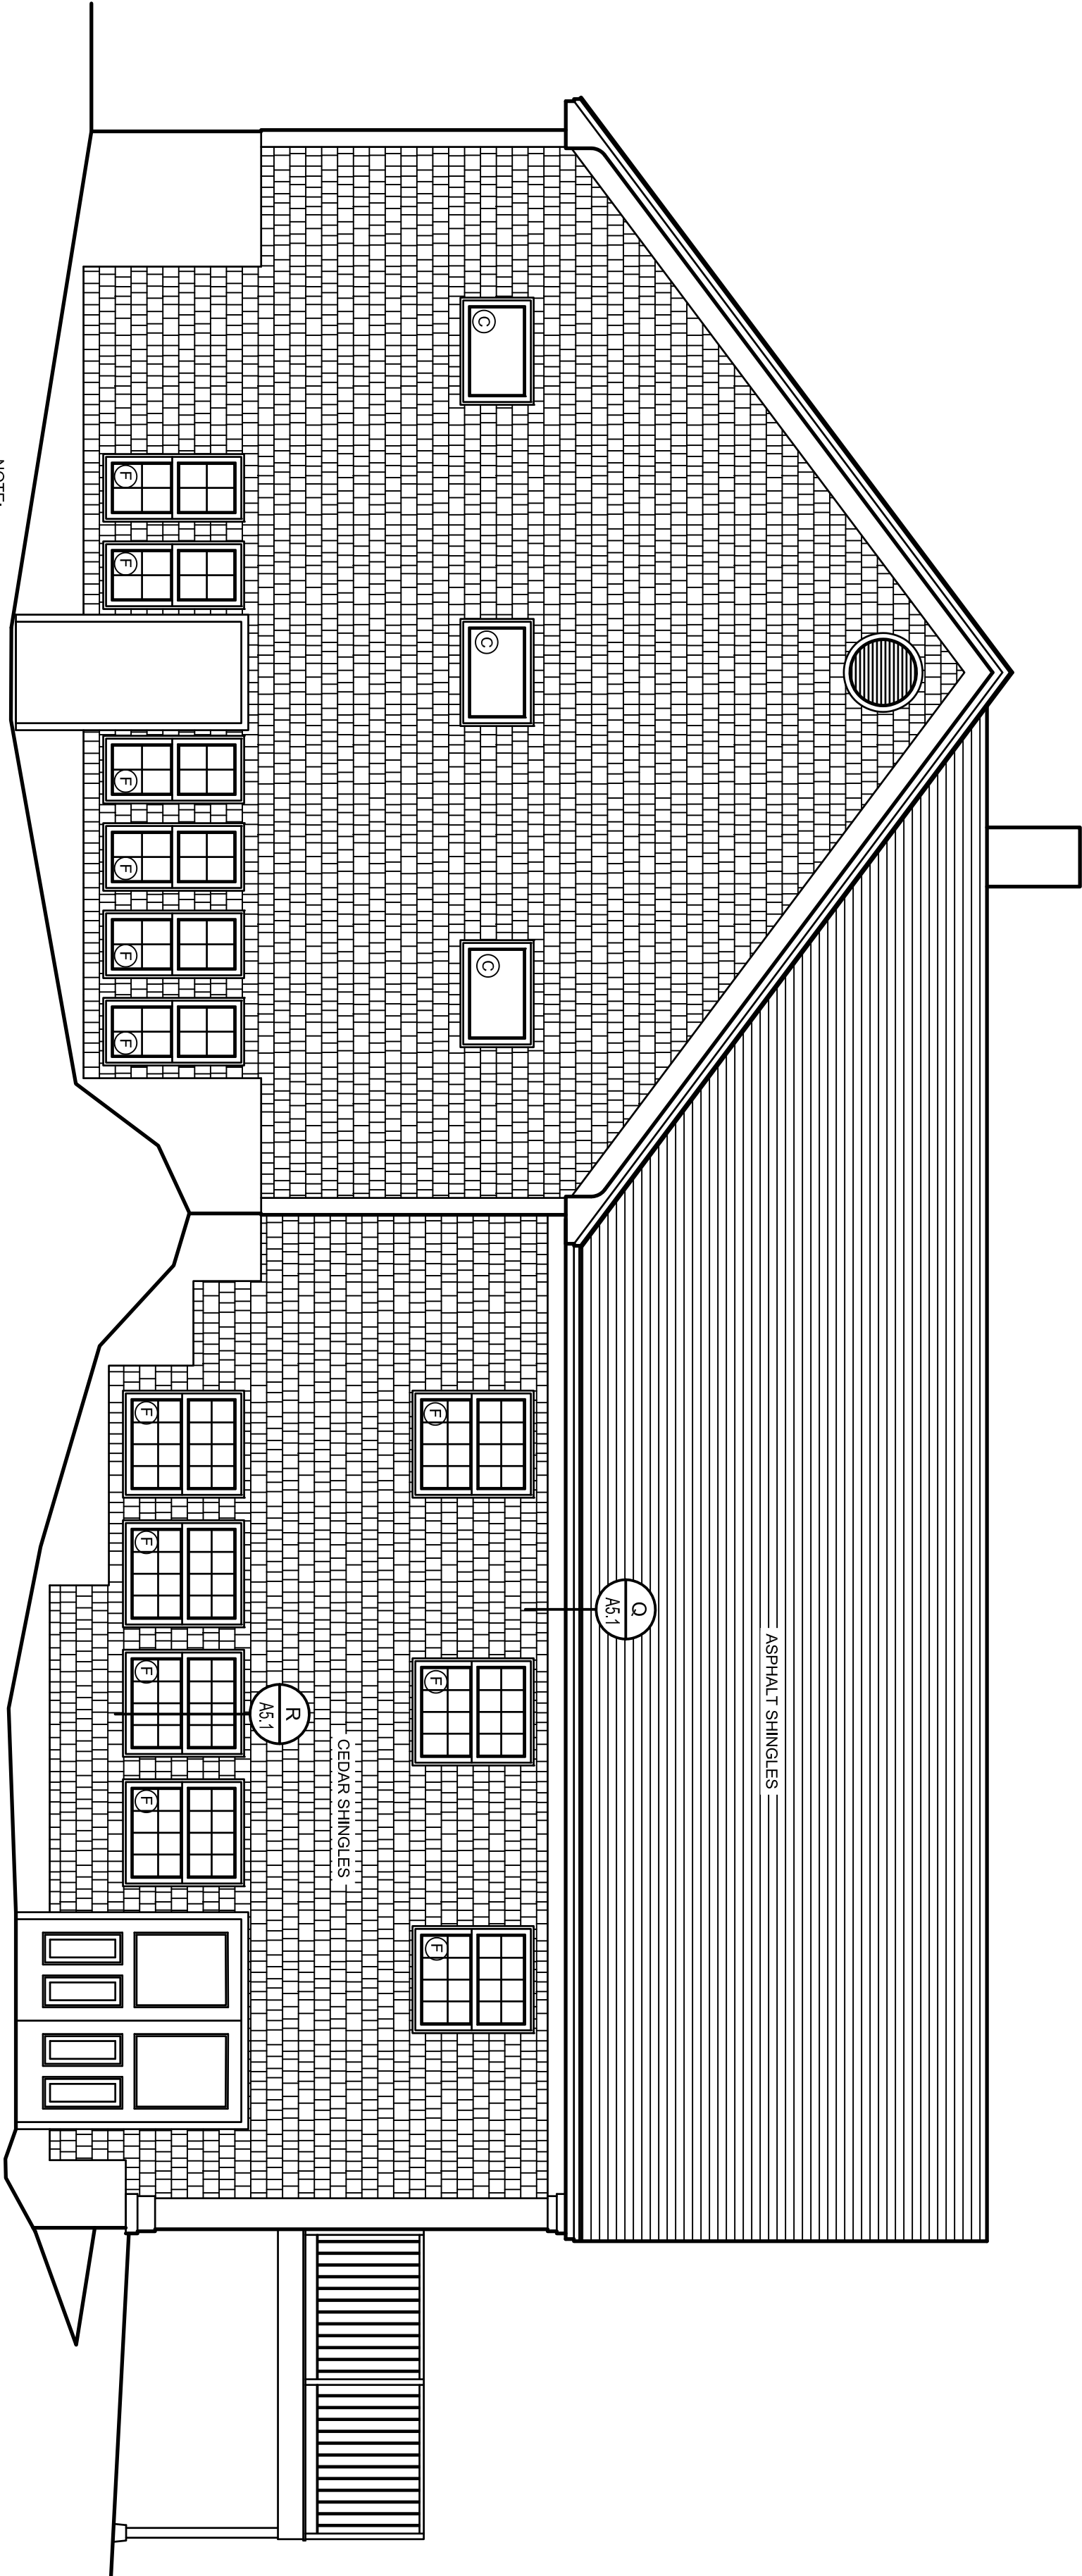


NOTE:
ALL EXISTING TRIM TO BE REPAINTED

EAST ELEVATION

 PROPOSED




SCALE: 1/4" = 1'-0"

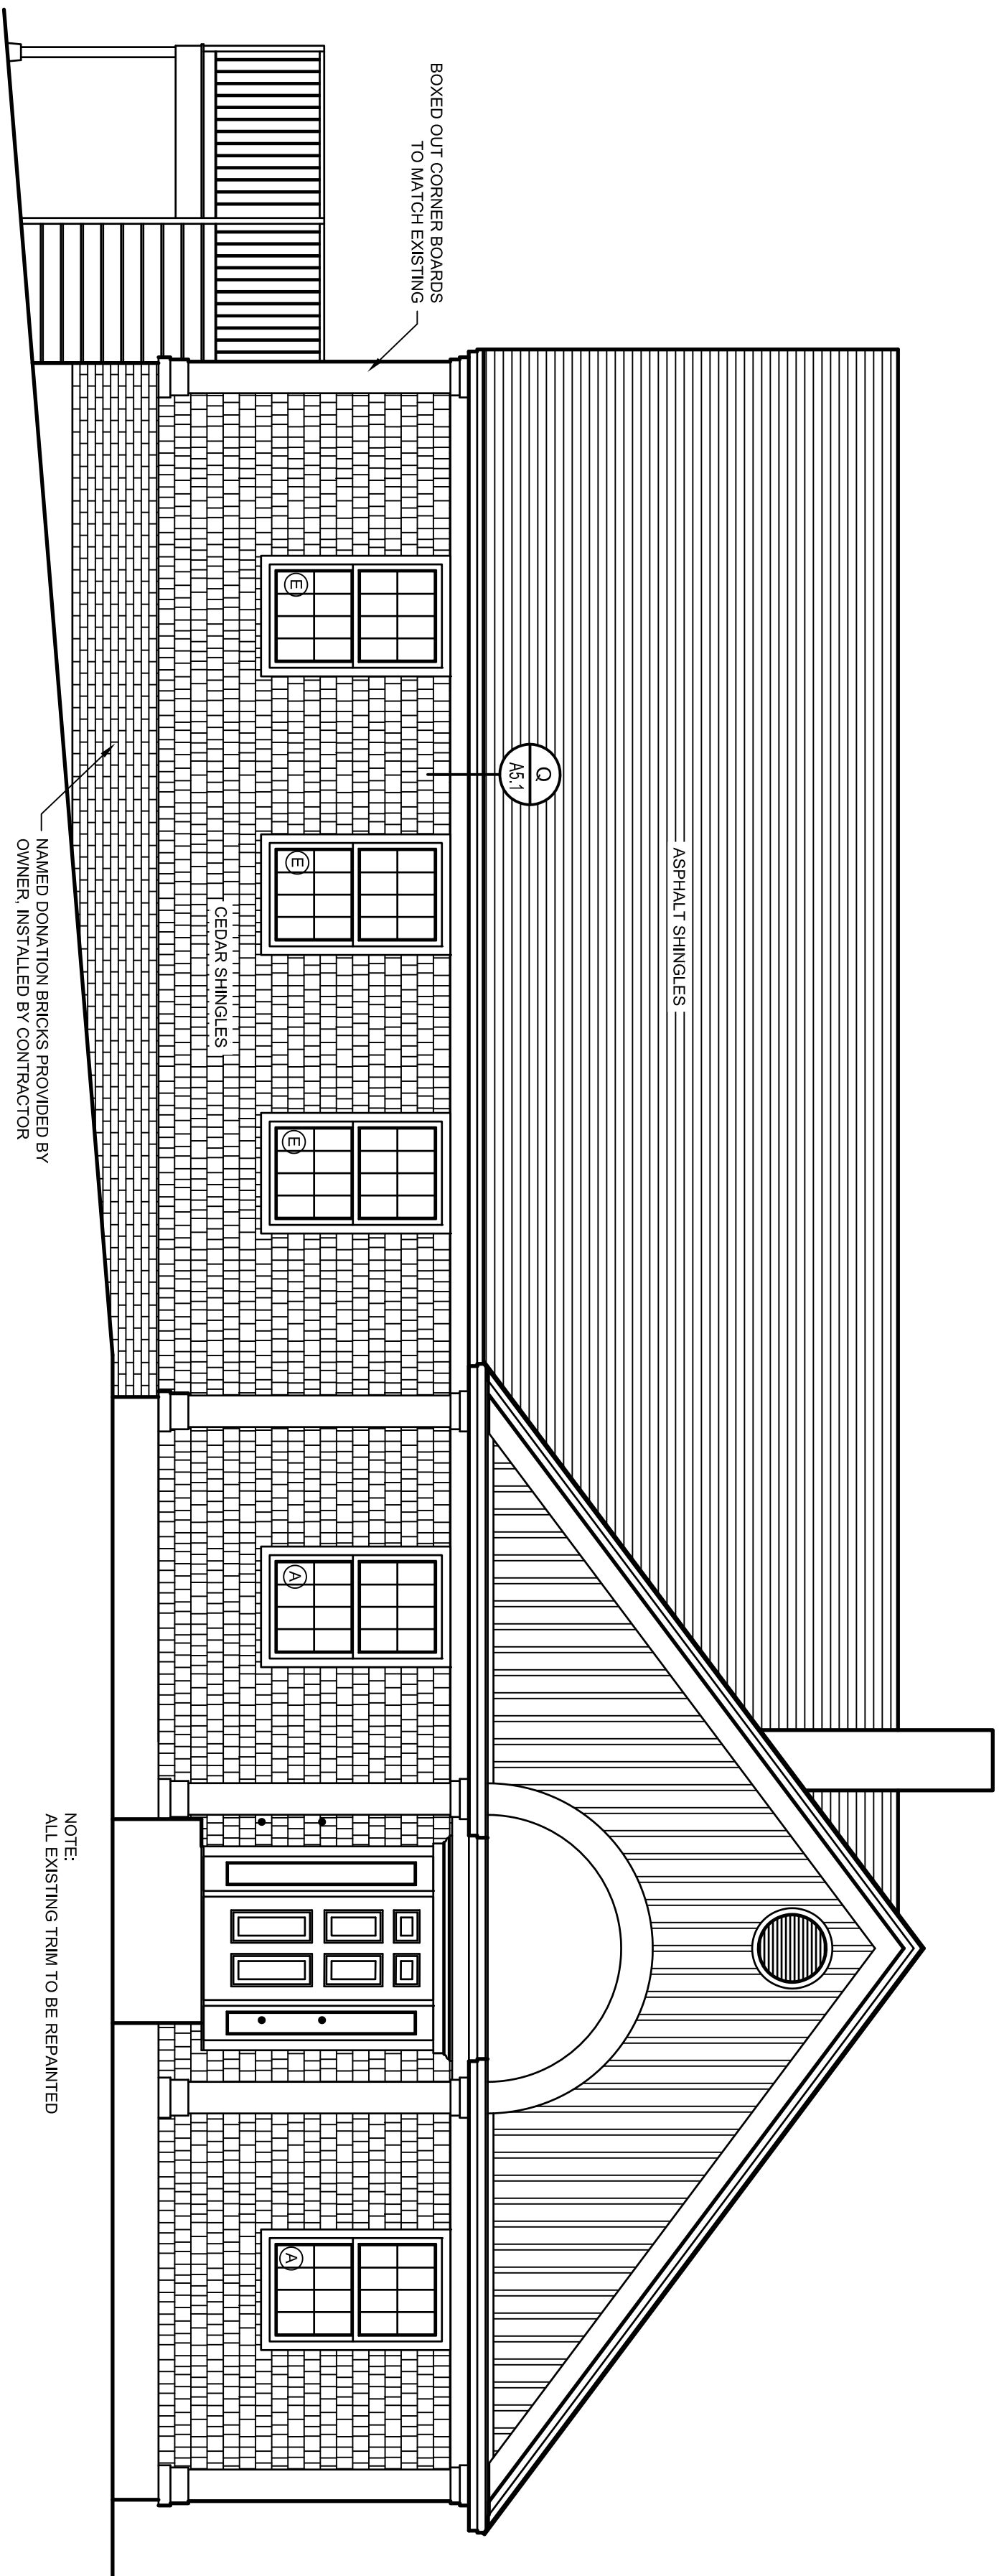

NOTE:
ALL EXISTING TRIM TO BE REPAINTED

WEST ELEVATION

PROPOSED

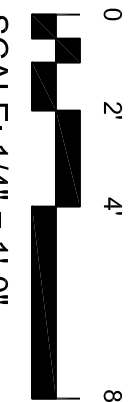

SCALE: 1/4" = 1'-0"


PROJECT:

FRIENDSHIP LIBRARY

ADDRESS:

3 MAINE STREET
FRIENDSHIP, MAINE

Chuck Campbell Architect PLLC
127 UNION ROAD
Waldoboro, Maine 04572
TEL (207)557-0448
e-mail chuck@chuckcampbellarchitect.com

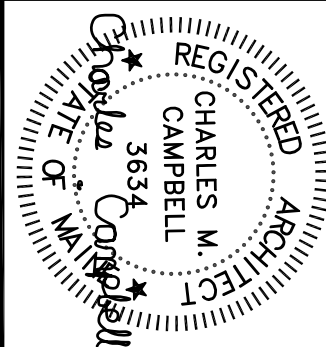

SHEET TITLE:

PROPOSED ELEVATIONS

AS INDICATED
SCALE:
DATE: AUGUST 13, 2026


NO.

REVISIONS


DATE

A4.2


PROJ. ID: FRIENDSHIP

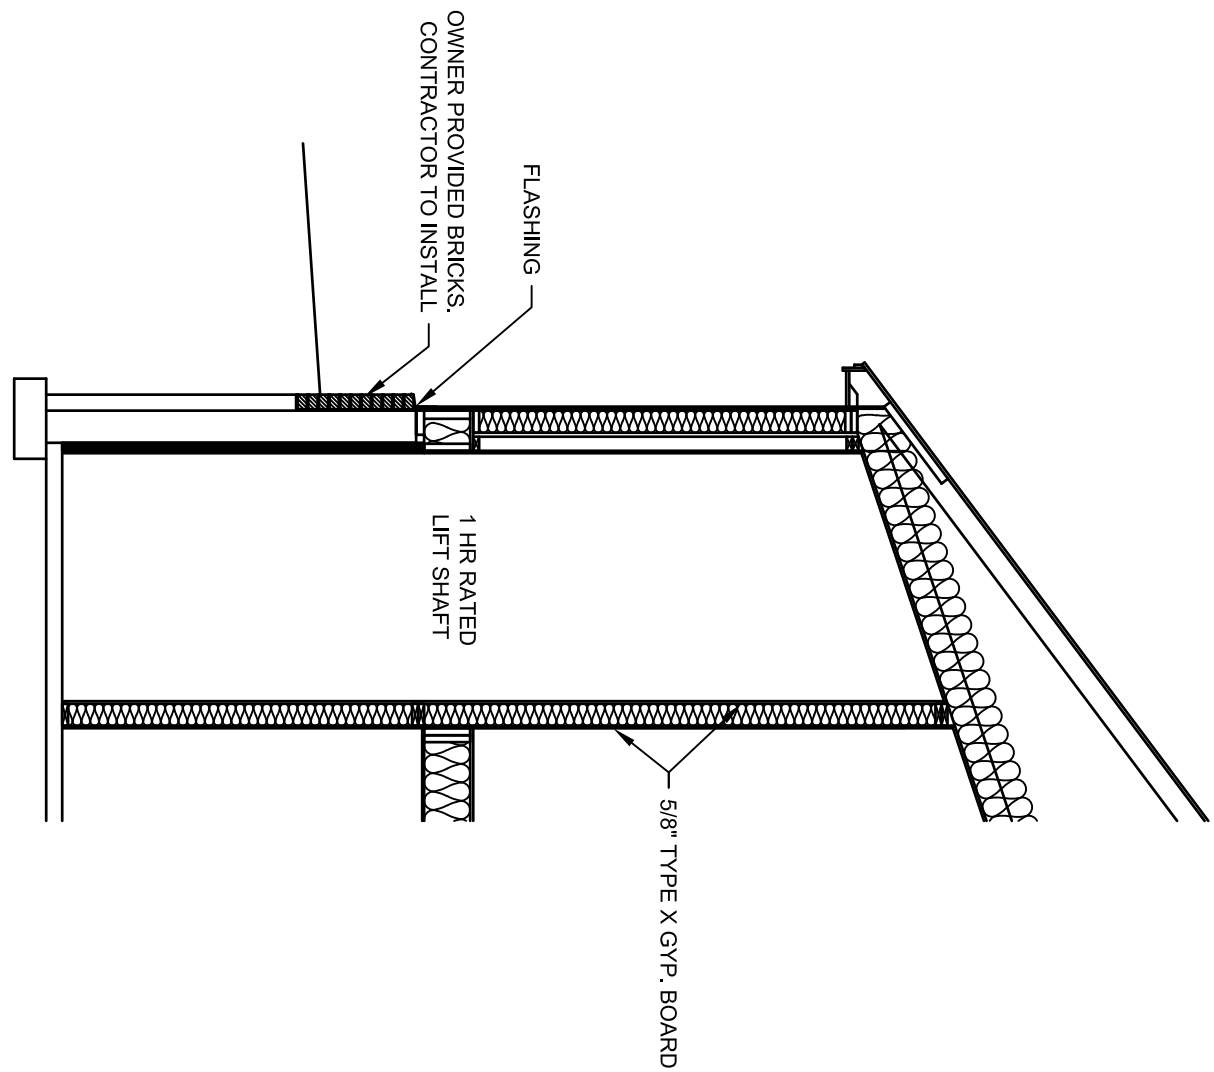


SECTION S
SCALE: 1/4" = 1'-0"

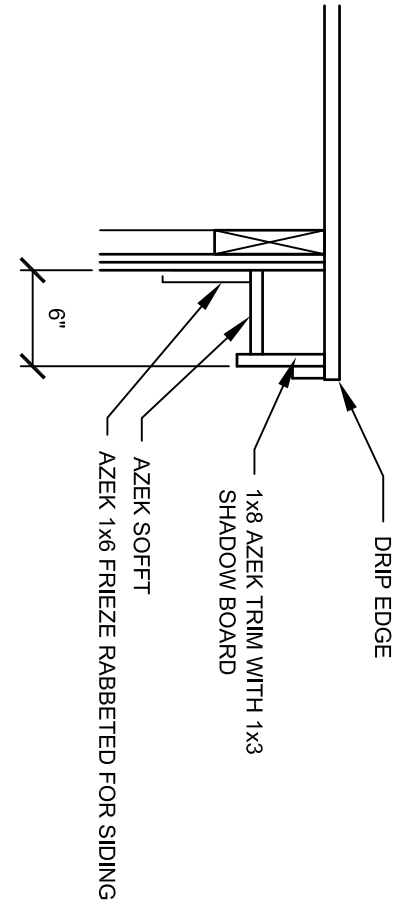


EAVE DETAIL W
SCALE: 1" = 1'-0"

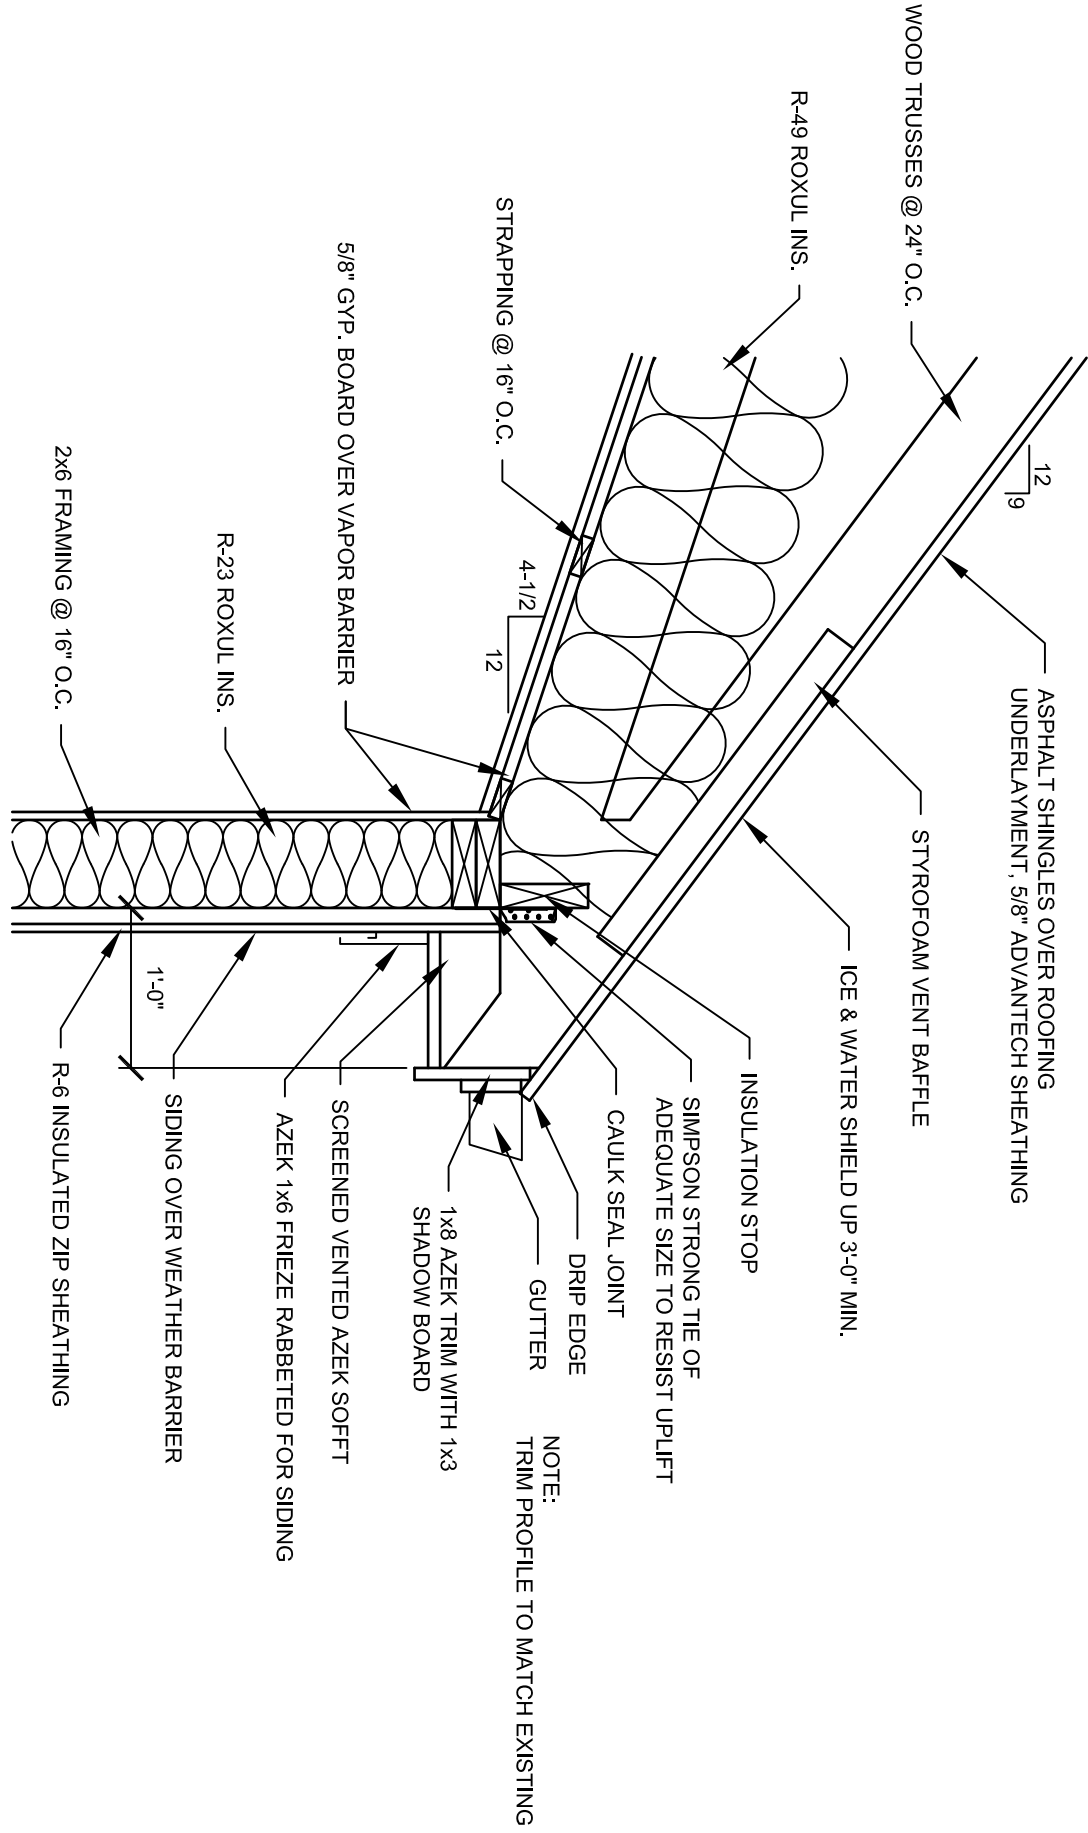


EAVE DETAIL O
SCALE: 1" = 1'-0"

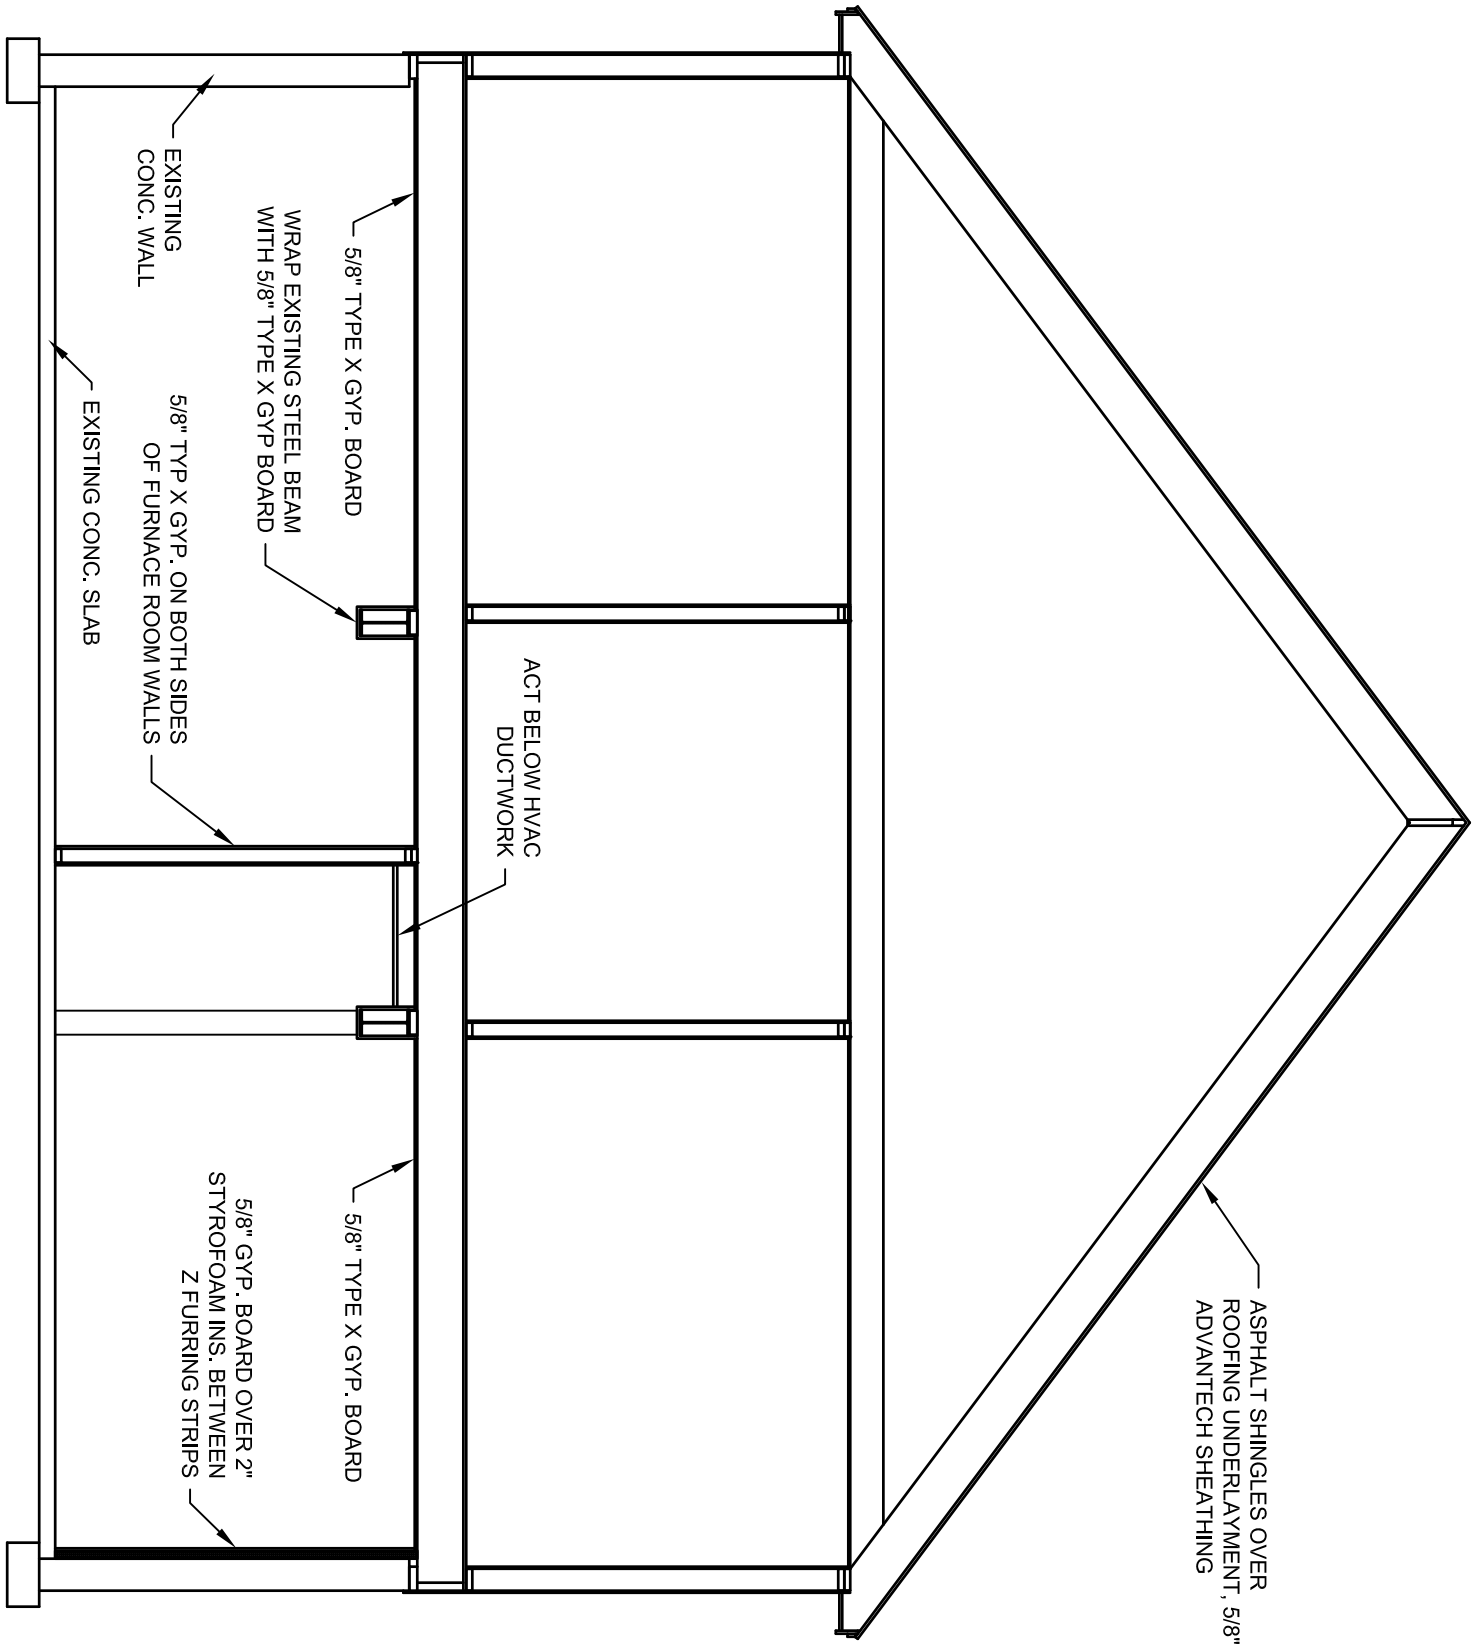

SECTION O
SCALE: 1/4" = 1'-0"

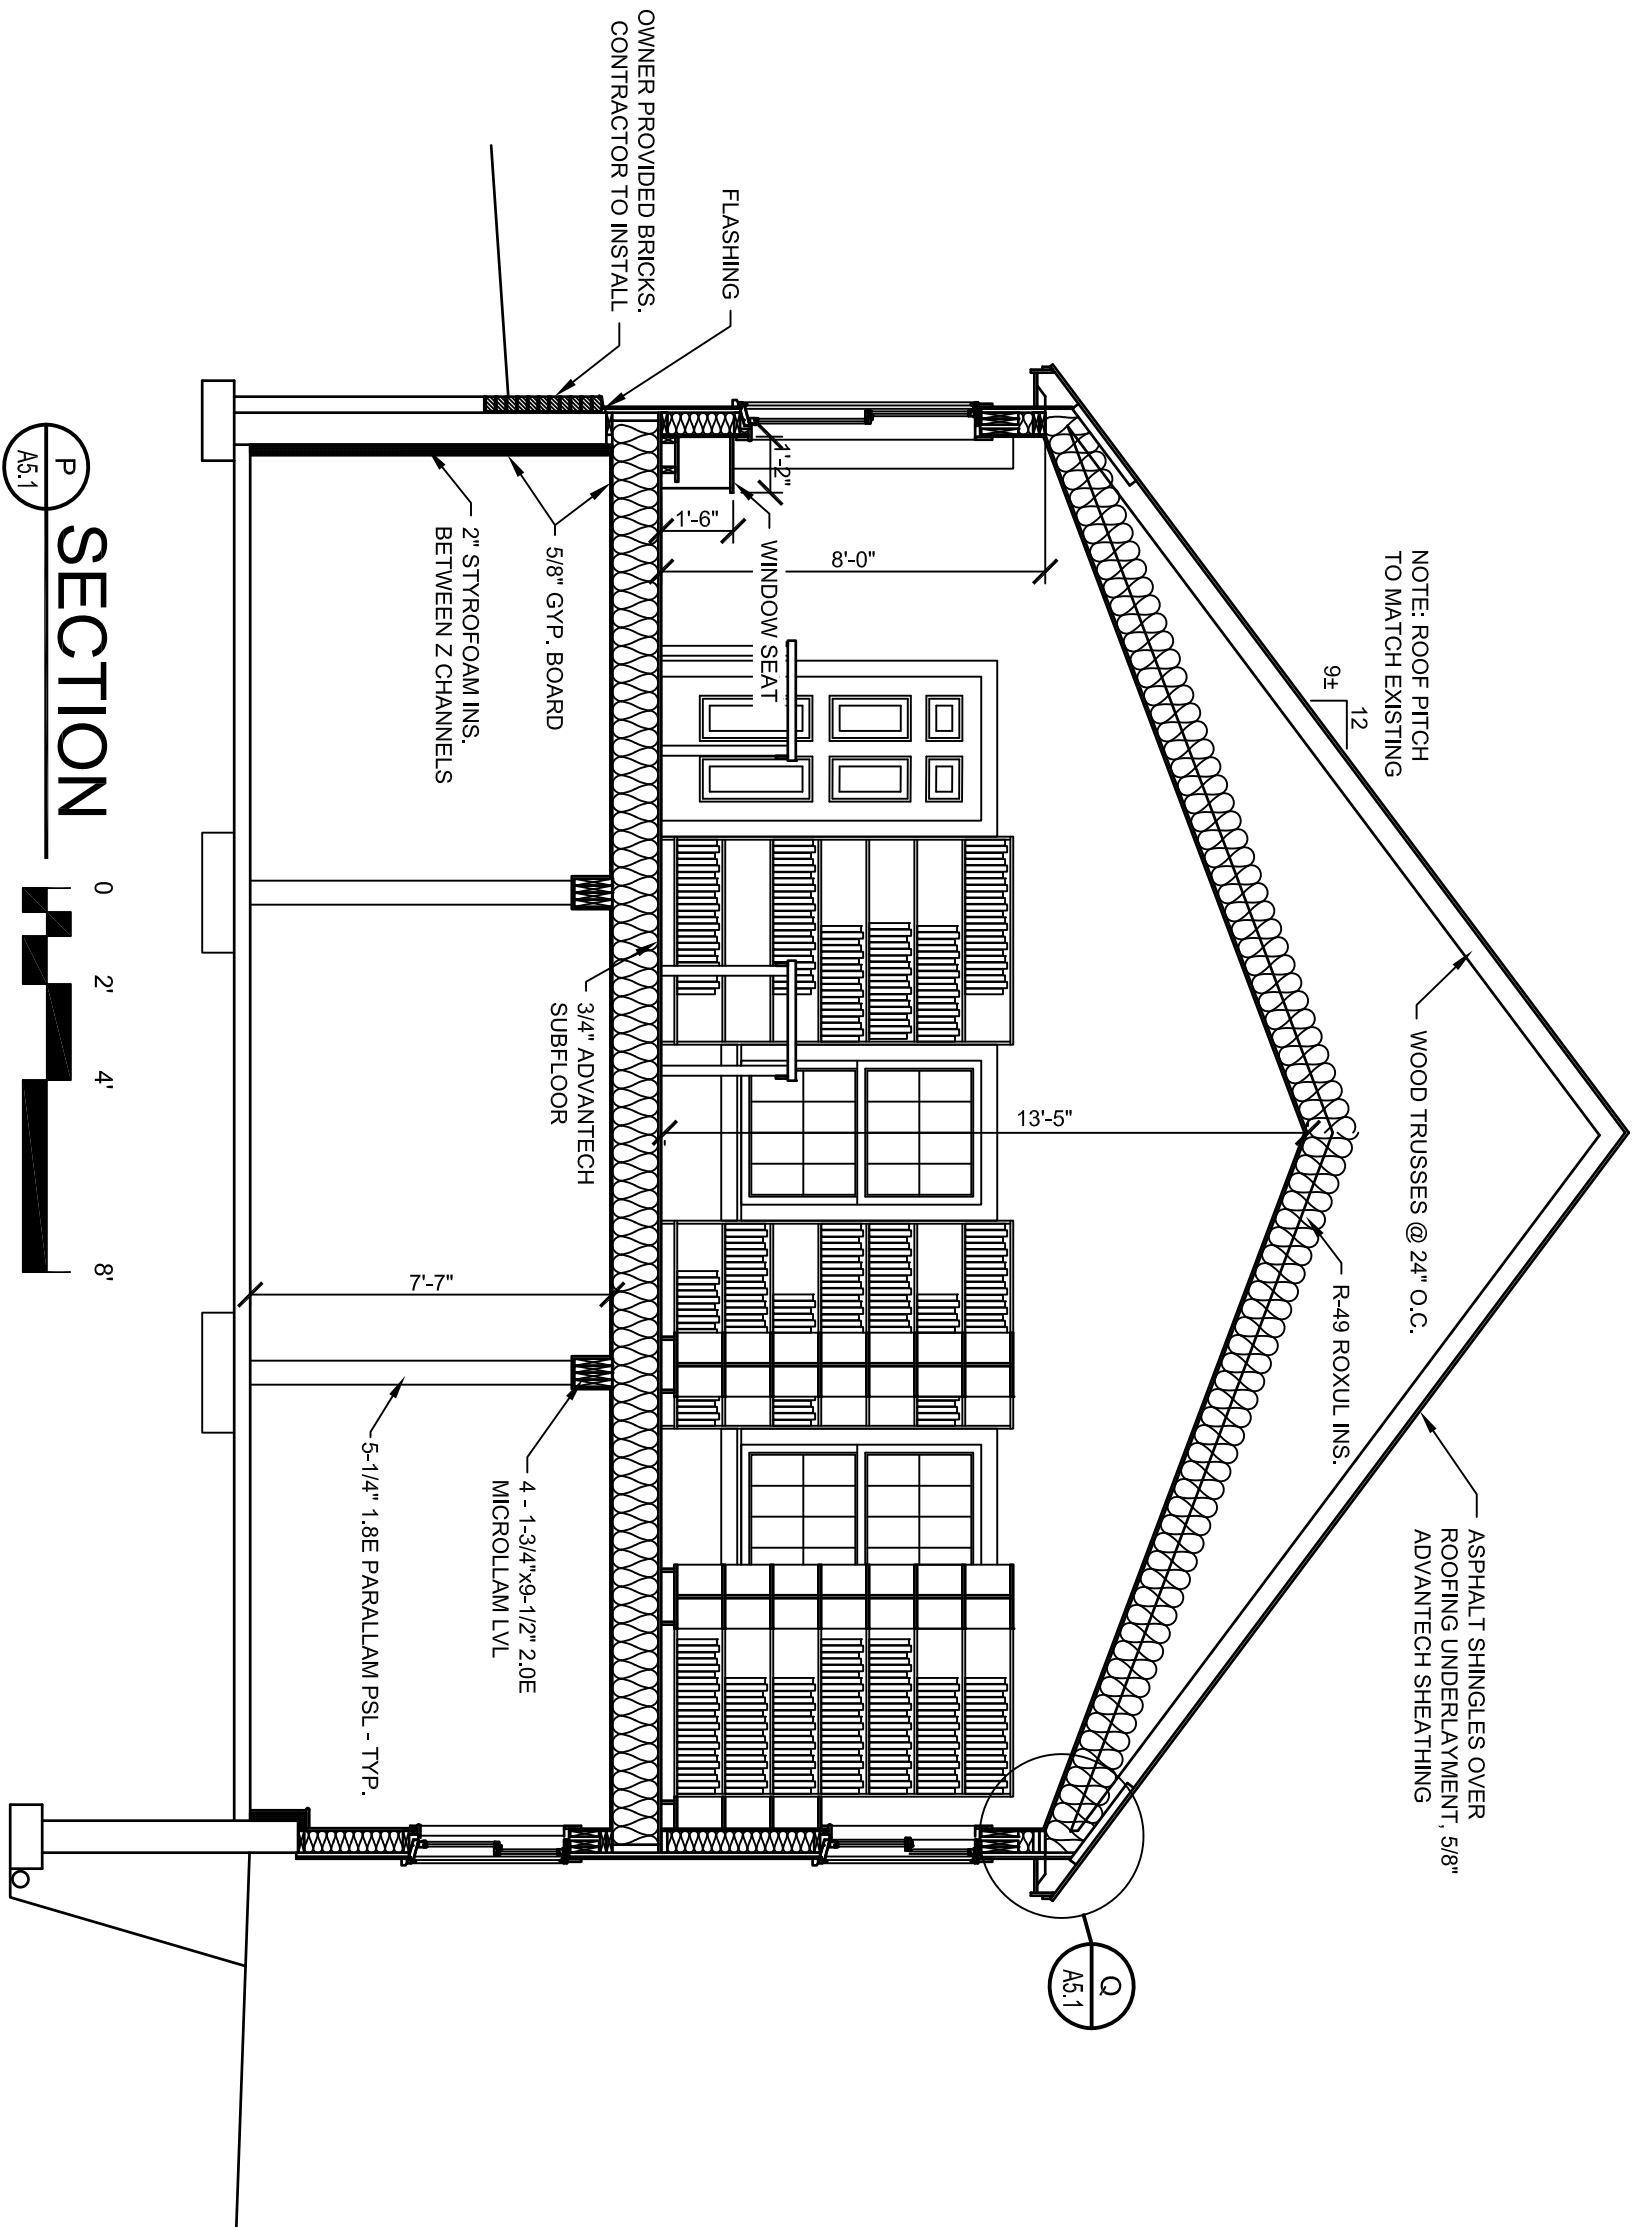

SECTION P
SCALE: 1/4" = 1'-0"

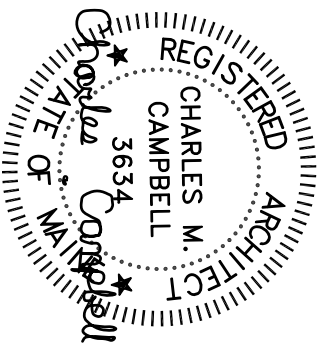

Chuck Campbell Architect PLLC
127 UNION ROAD
Waldoboro, Maine 04572
TEL (207)557-0448
e-mail chuck@chuckcampbellarchitect.com


PROJECT: **FRIENDSHIP LIBRARY**
ADDRESS: **3 MAINE STREET**
FRIENDSHIP, MAINE

NO.	REVISIONS	DATE

SHEET TITLE: **SECTION**
AS INDICATED
SCALE:
DATE: **AUGUST 13, 2026**

PROJ. ID: FRIENDSHIP

A5.1

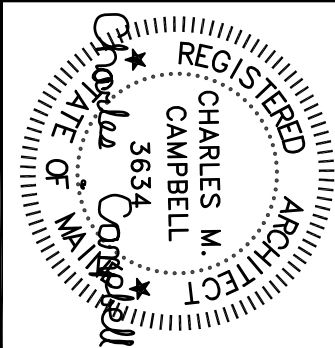

Chuck Campbell Architect PLLC
127 UNION ROAD
Waldoboro, Maine 04572
TEL (207)557-0448
e-mail chuck@chuckcampbellarchitect.com


PROJECT:
FRIENDSHIP LIBRARY
ADDRESS:
**3 MAINE STREET
FRIENDSHIP, MAINE**

NO.	REVISIONS	DATE


SHEET TITLE:
SECTION
SCALE: **AS INDICATED**
DATE: **AUGUST 13, 2026**

PROJ. ID: **FRIENDSHIP**


A5.2

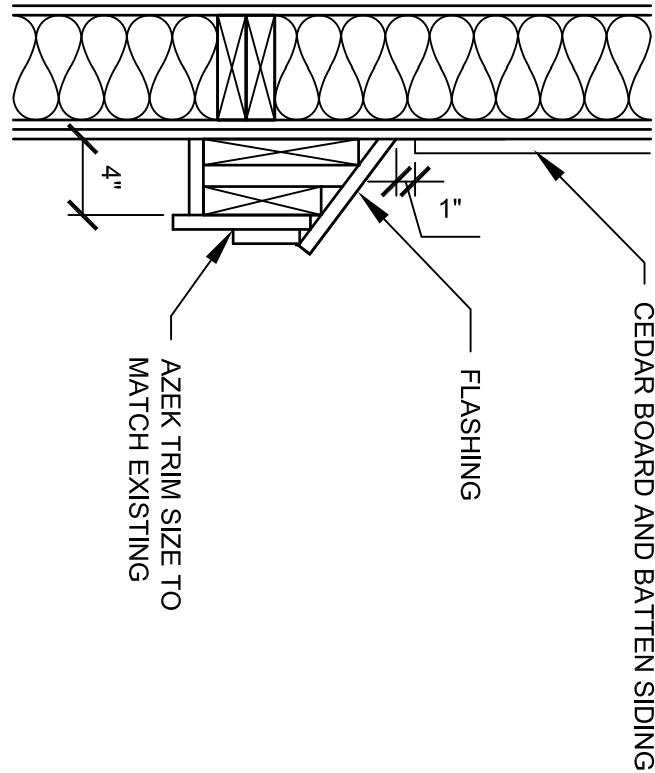


EAVE DETAIL
SCALE: 1" = 1'-0"

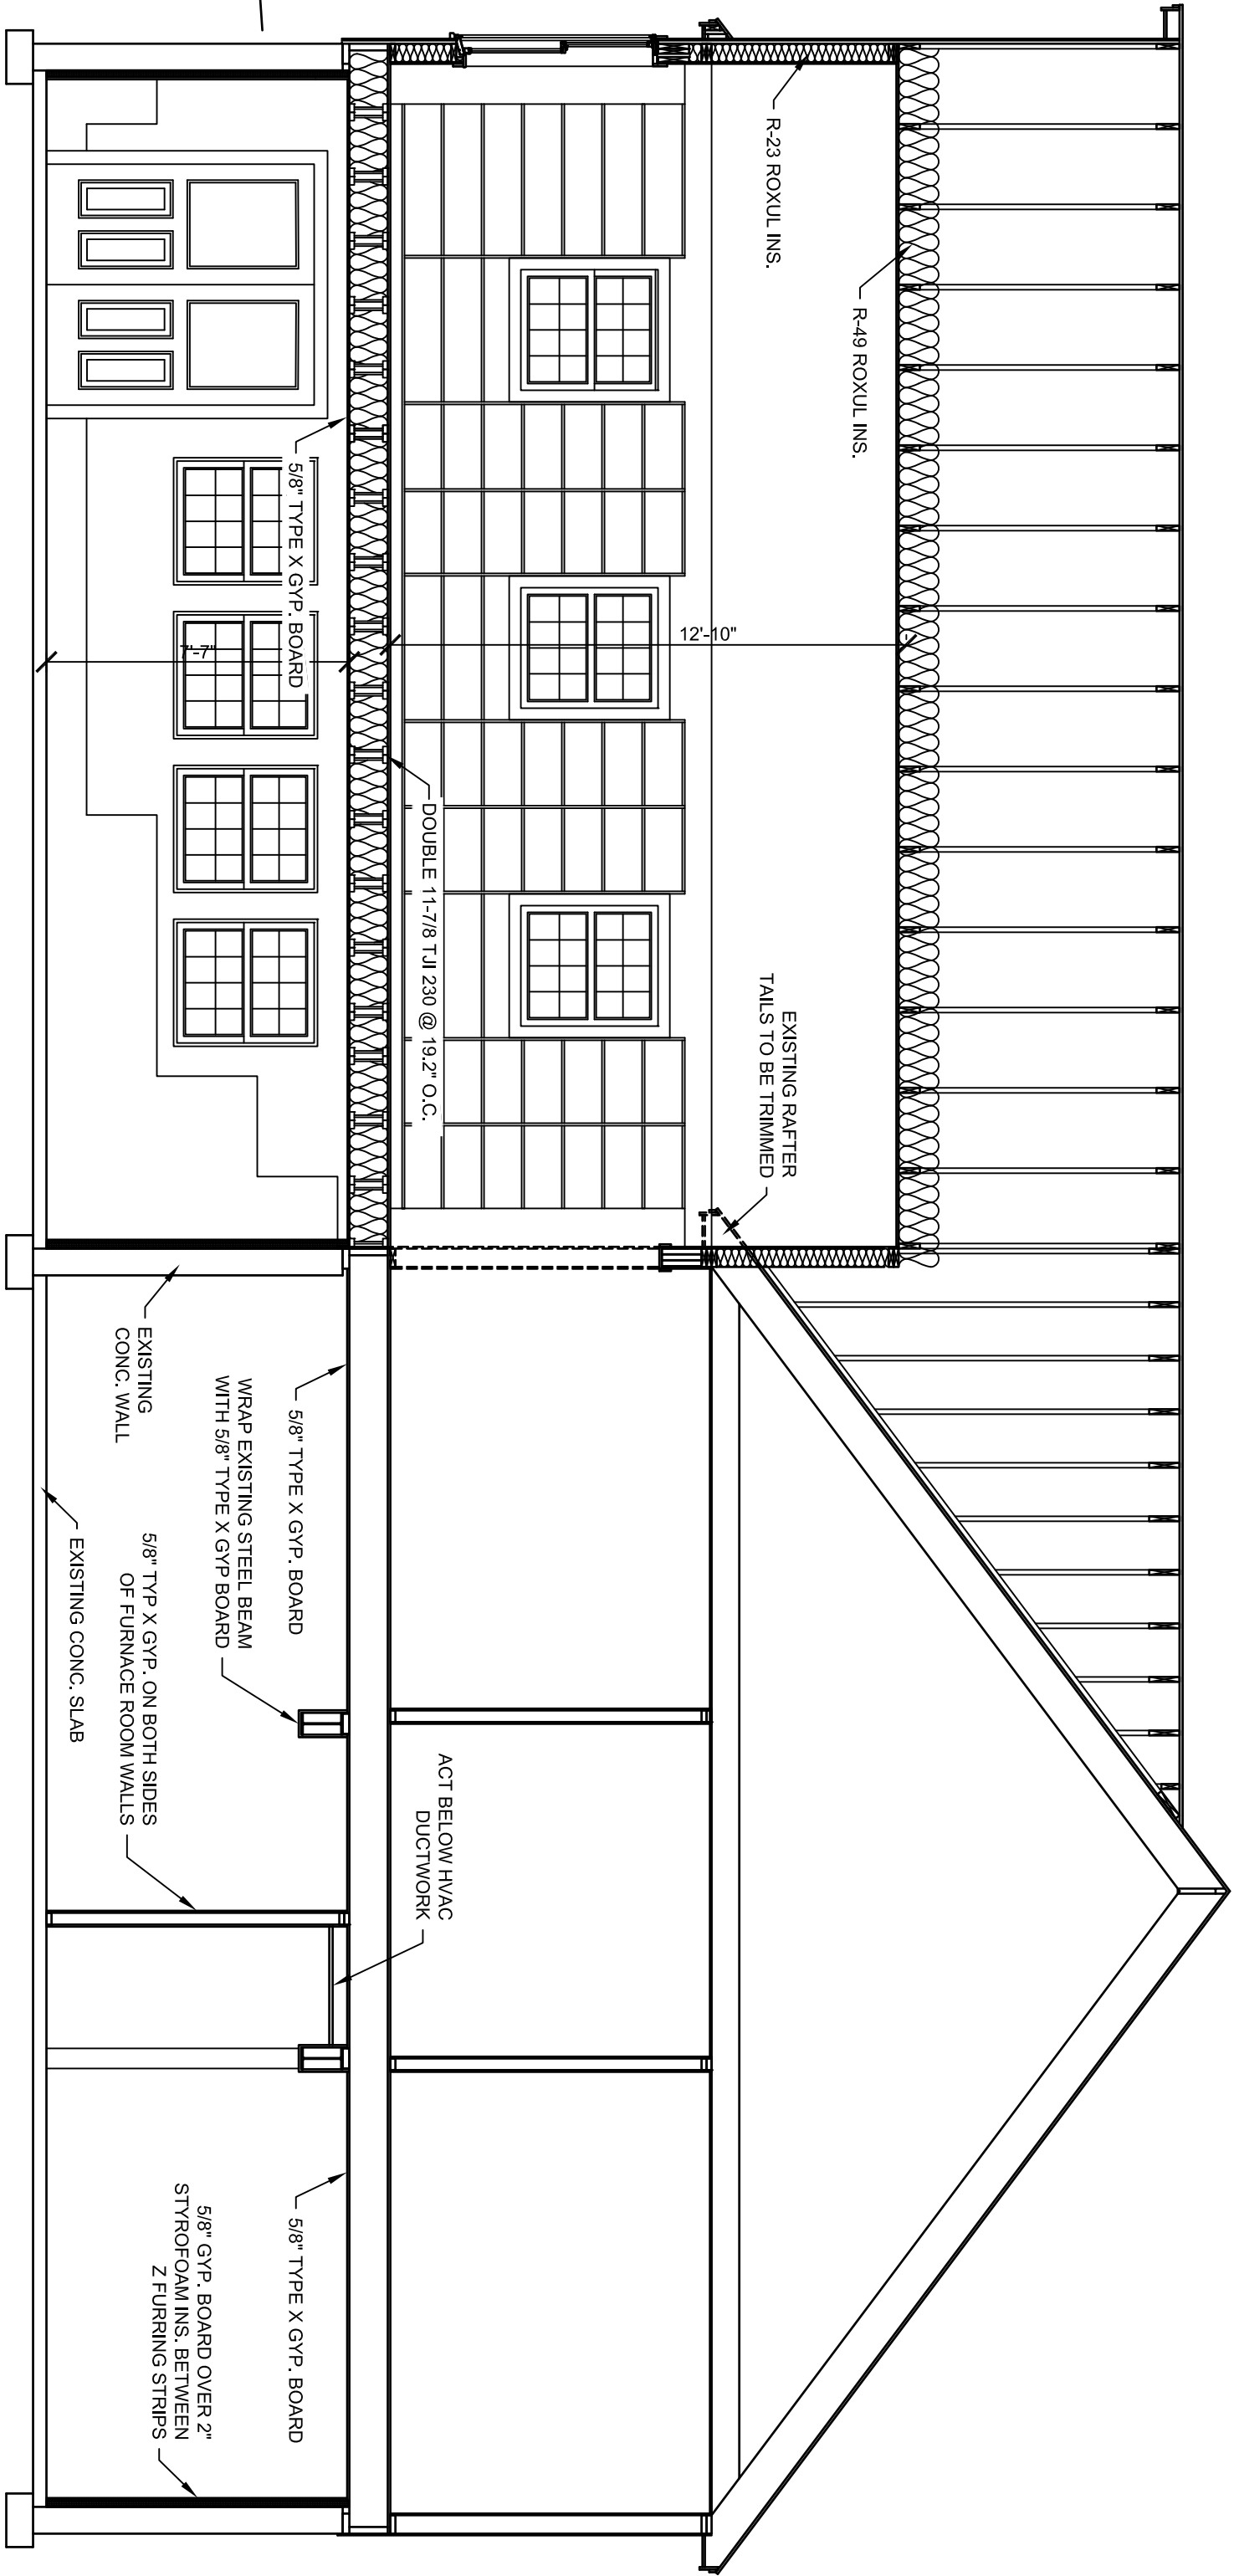

SECTION
SCALE: 1/4" = 1'-0"

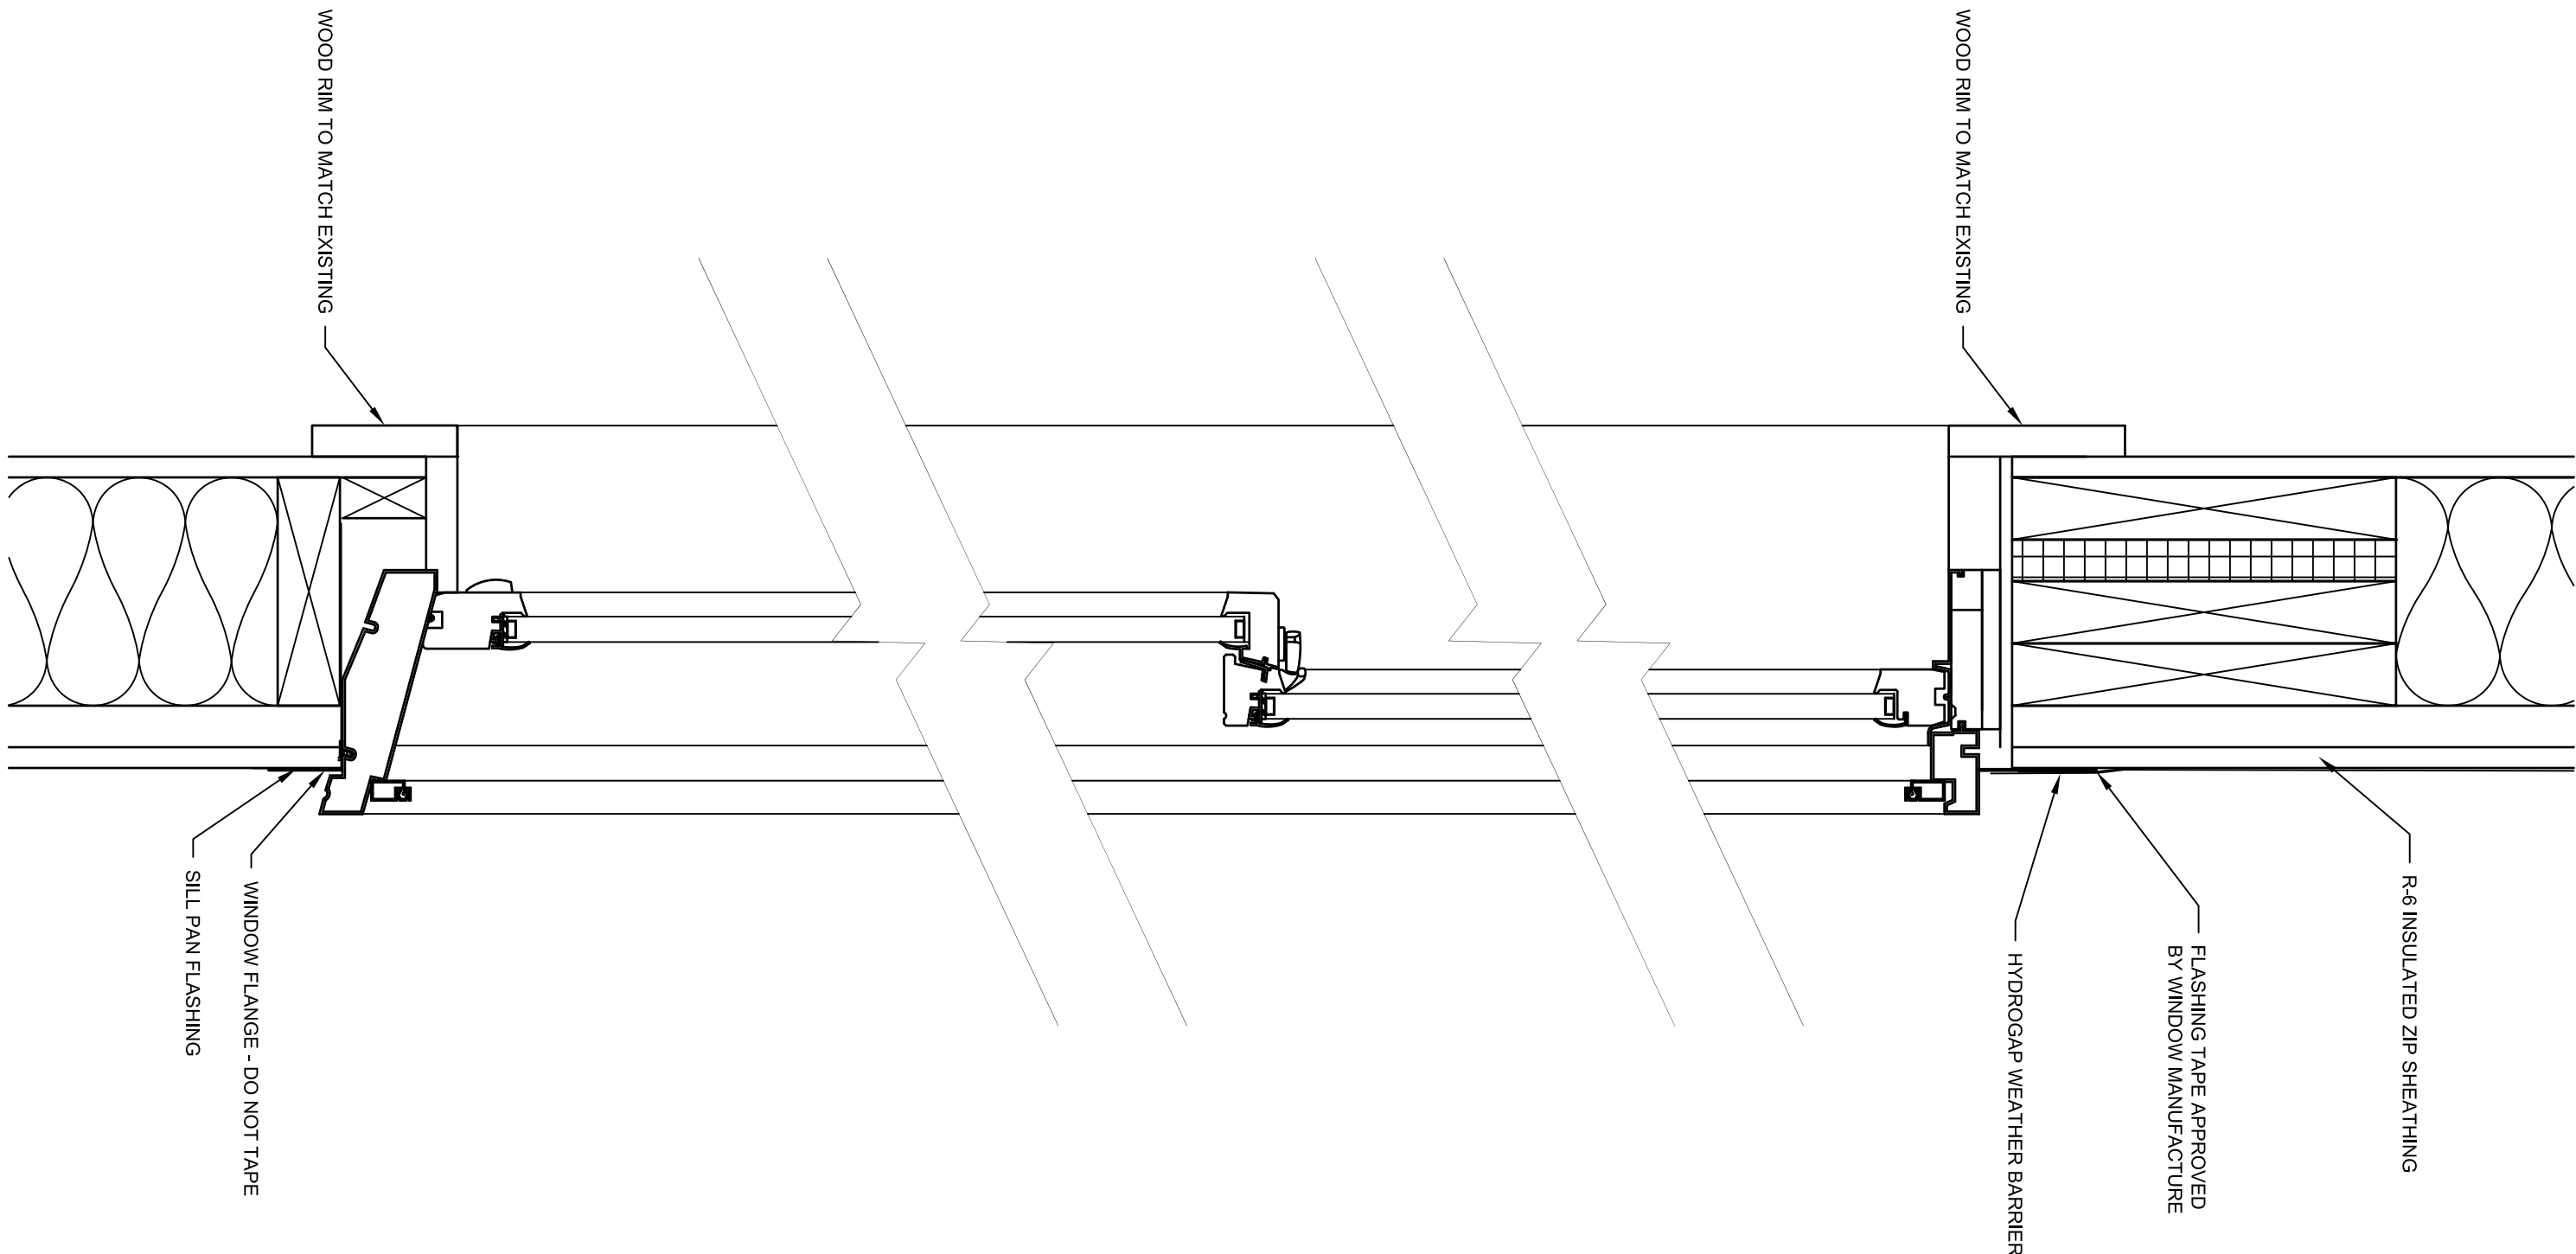

WINDOW DETAIL
SCALE: 3/4" = 1'-0"

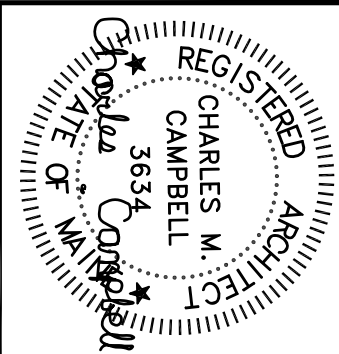

Chuck Campbell Architect PLLC
127 UNION ROAD
Waldoboro, Maine 04572
TEL (207)557-0448
e-mail chuck@chuckcampbellarchitect.com

PROJECT:
FRIENDSHIP LIBRARY


ADDRESS:
**3 MAINE STREET
FRIENDSHIP, MAINE**

NO.	REVISIONS	DATE


SHEET TITLE: DETAILS	
AS INDICATED	
SCALE:	
DATE: AUGUST 13, 2026	

PROJ. ID: FRIENDSHIP


A5.3

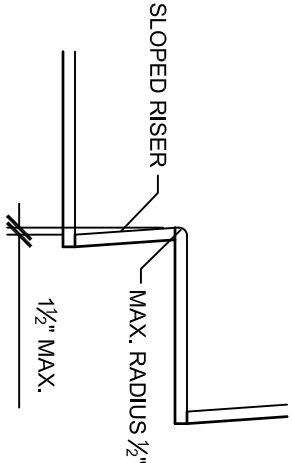


NOSING EXAMPLE
SCALE: 1" = 1'-0"

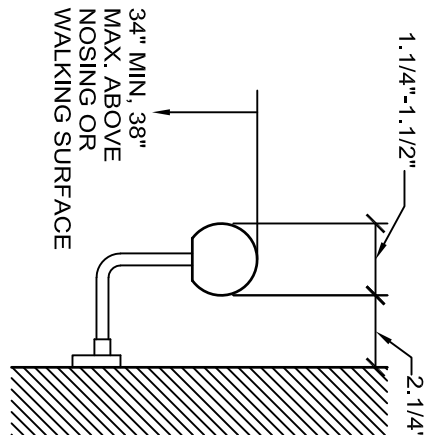


HANDRAIL
SCALE: 3" = 1'-0"

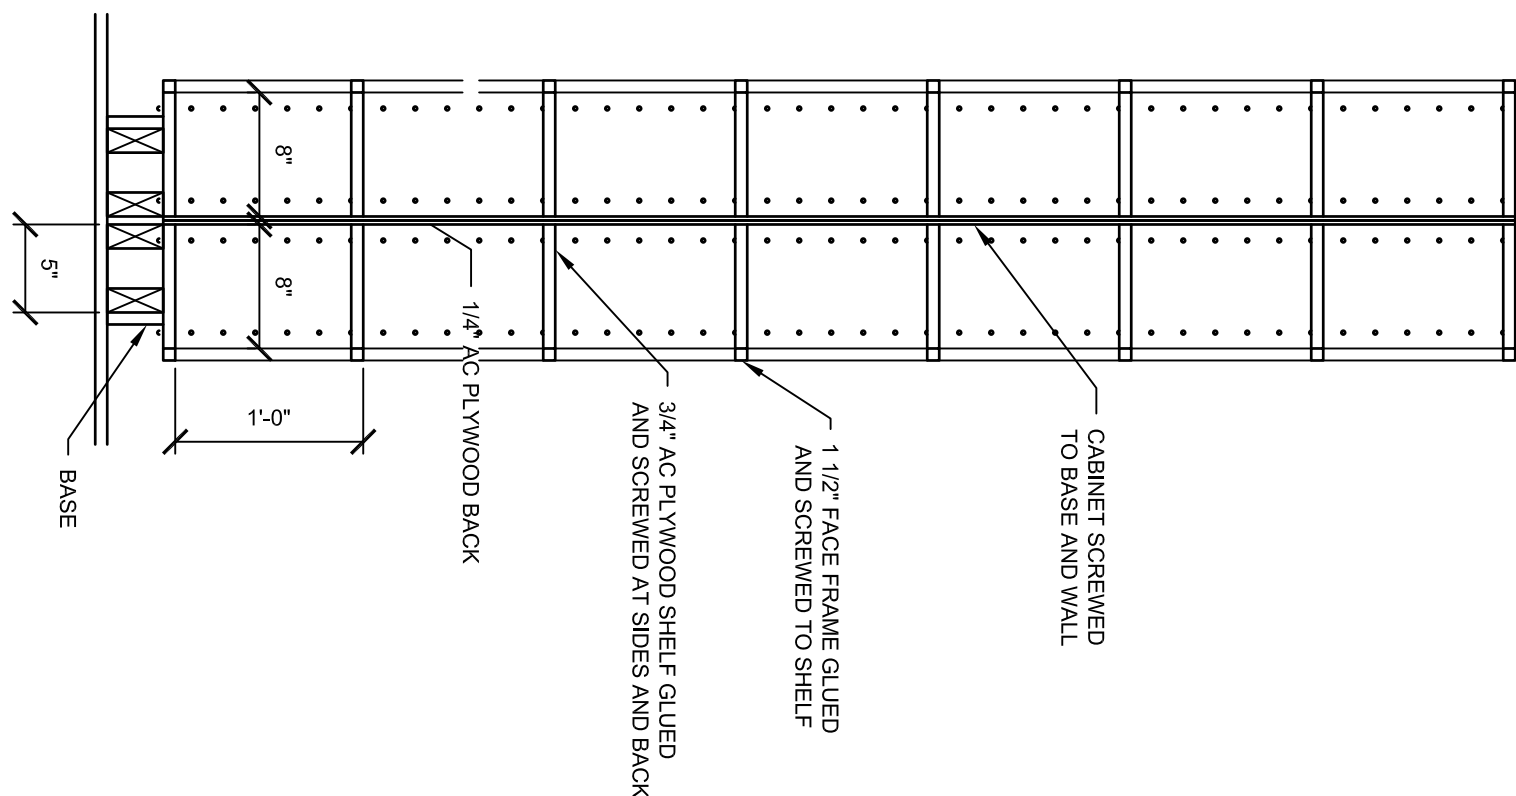

SHELF SECTION
SCALE: 1" = 1'-0"

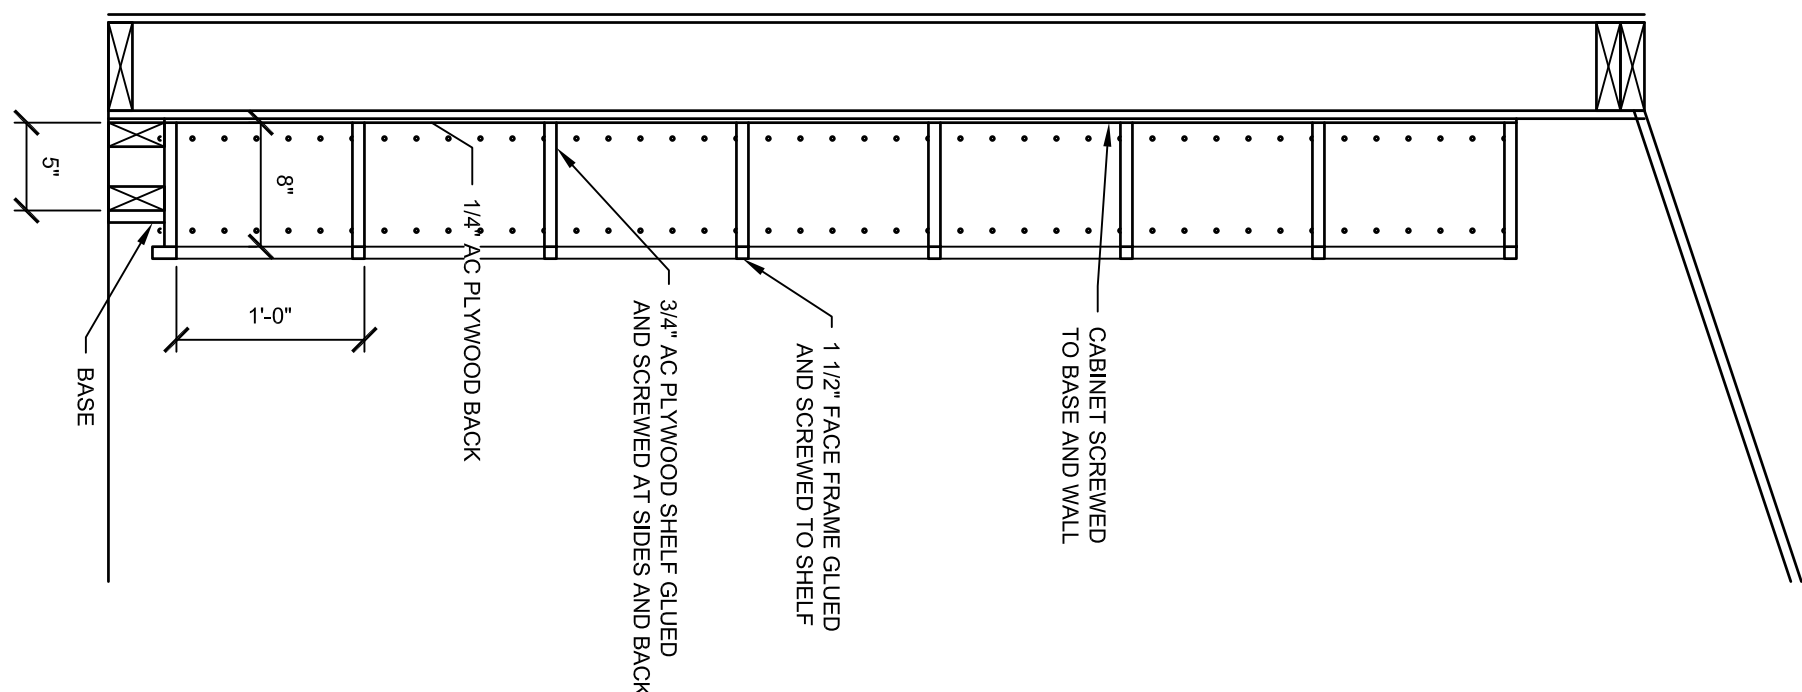


SHELF SECTION
SCALE: 1" = 1'-0"

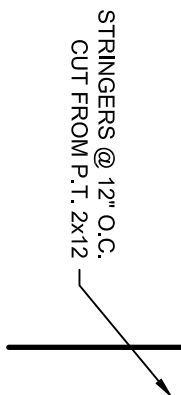


A circular professional seal for Charles M. Campbell, a Registered Architect in the State of Maryland. The seal features the text "REGISTERED ARCHITECT" around the top and "STATE OF MARYLAND" around the bottom, separated by two stars. In the center, the name "CHARLES M. CAMPBELL" is written above the number "3634". A handwritten signature, "Charles Campbell", is written across the seal.


TRUSS LOADING (TYPE F)	(PSF)
DEAD LOAD	15
TOP CHORD DEAD LOAD	15
BOTTOM CHORD LIVE LOAD	00
BOTTOM CHORD DEAD LOAD	10

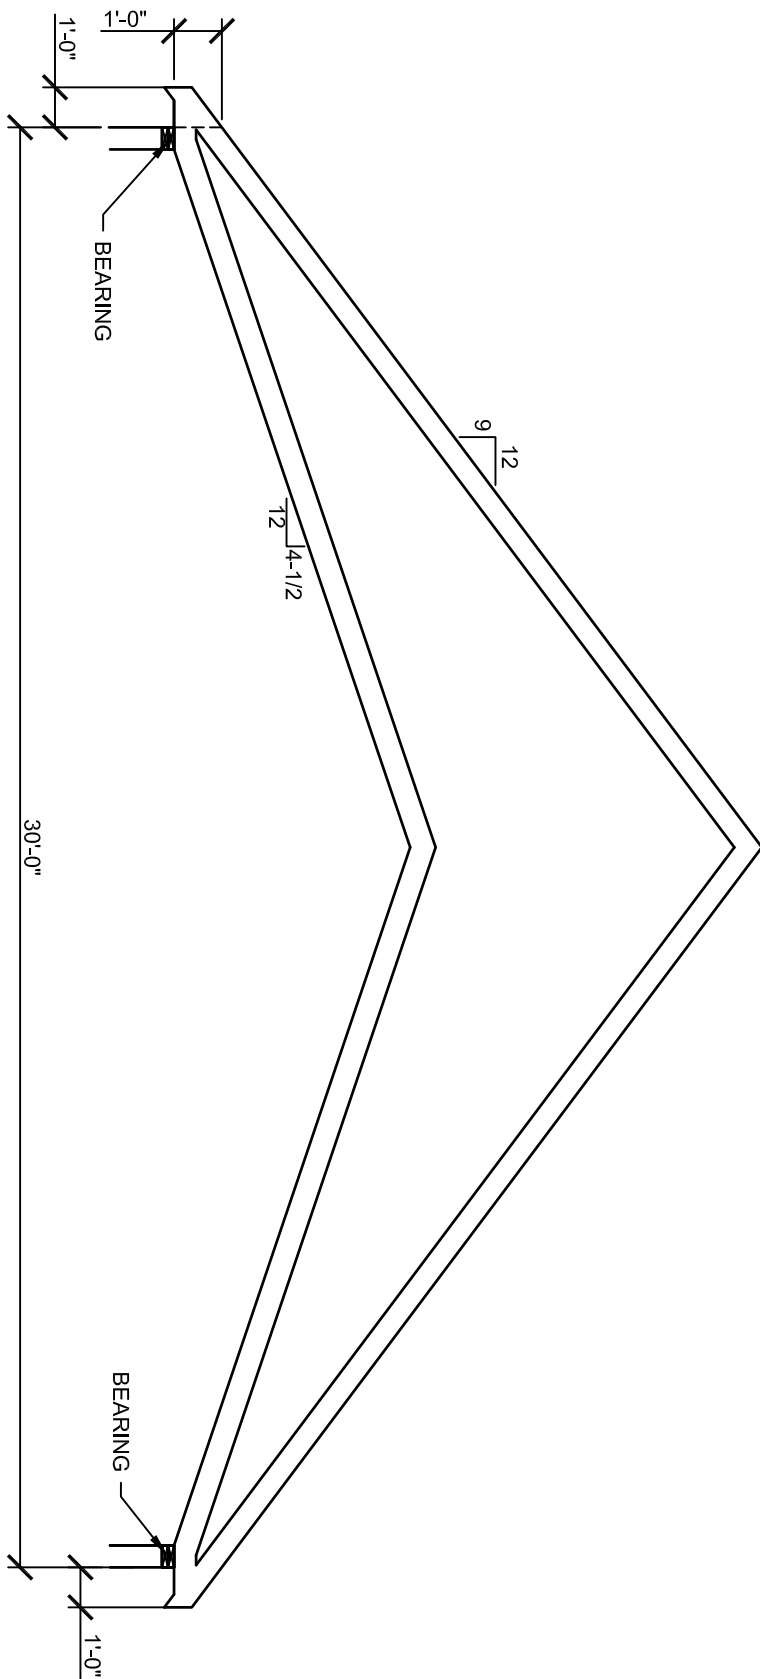


TRUSS DIAGRAM

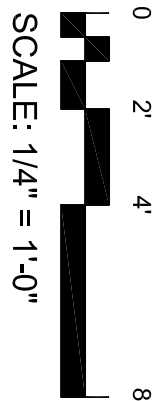


SCALE: 1/4" = 1'-0"

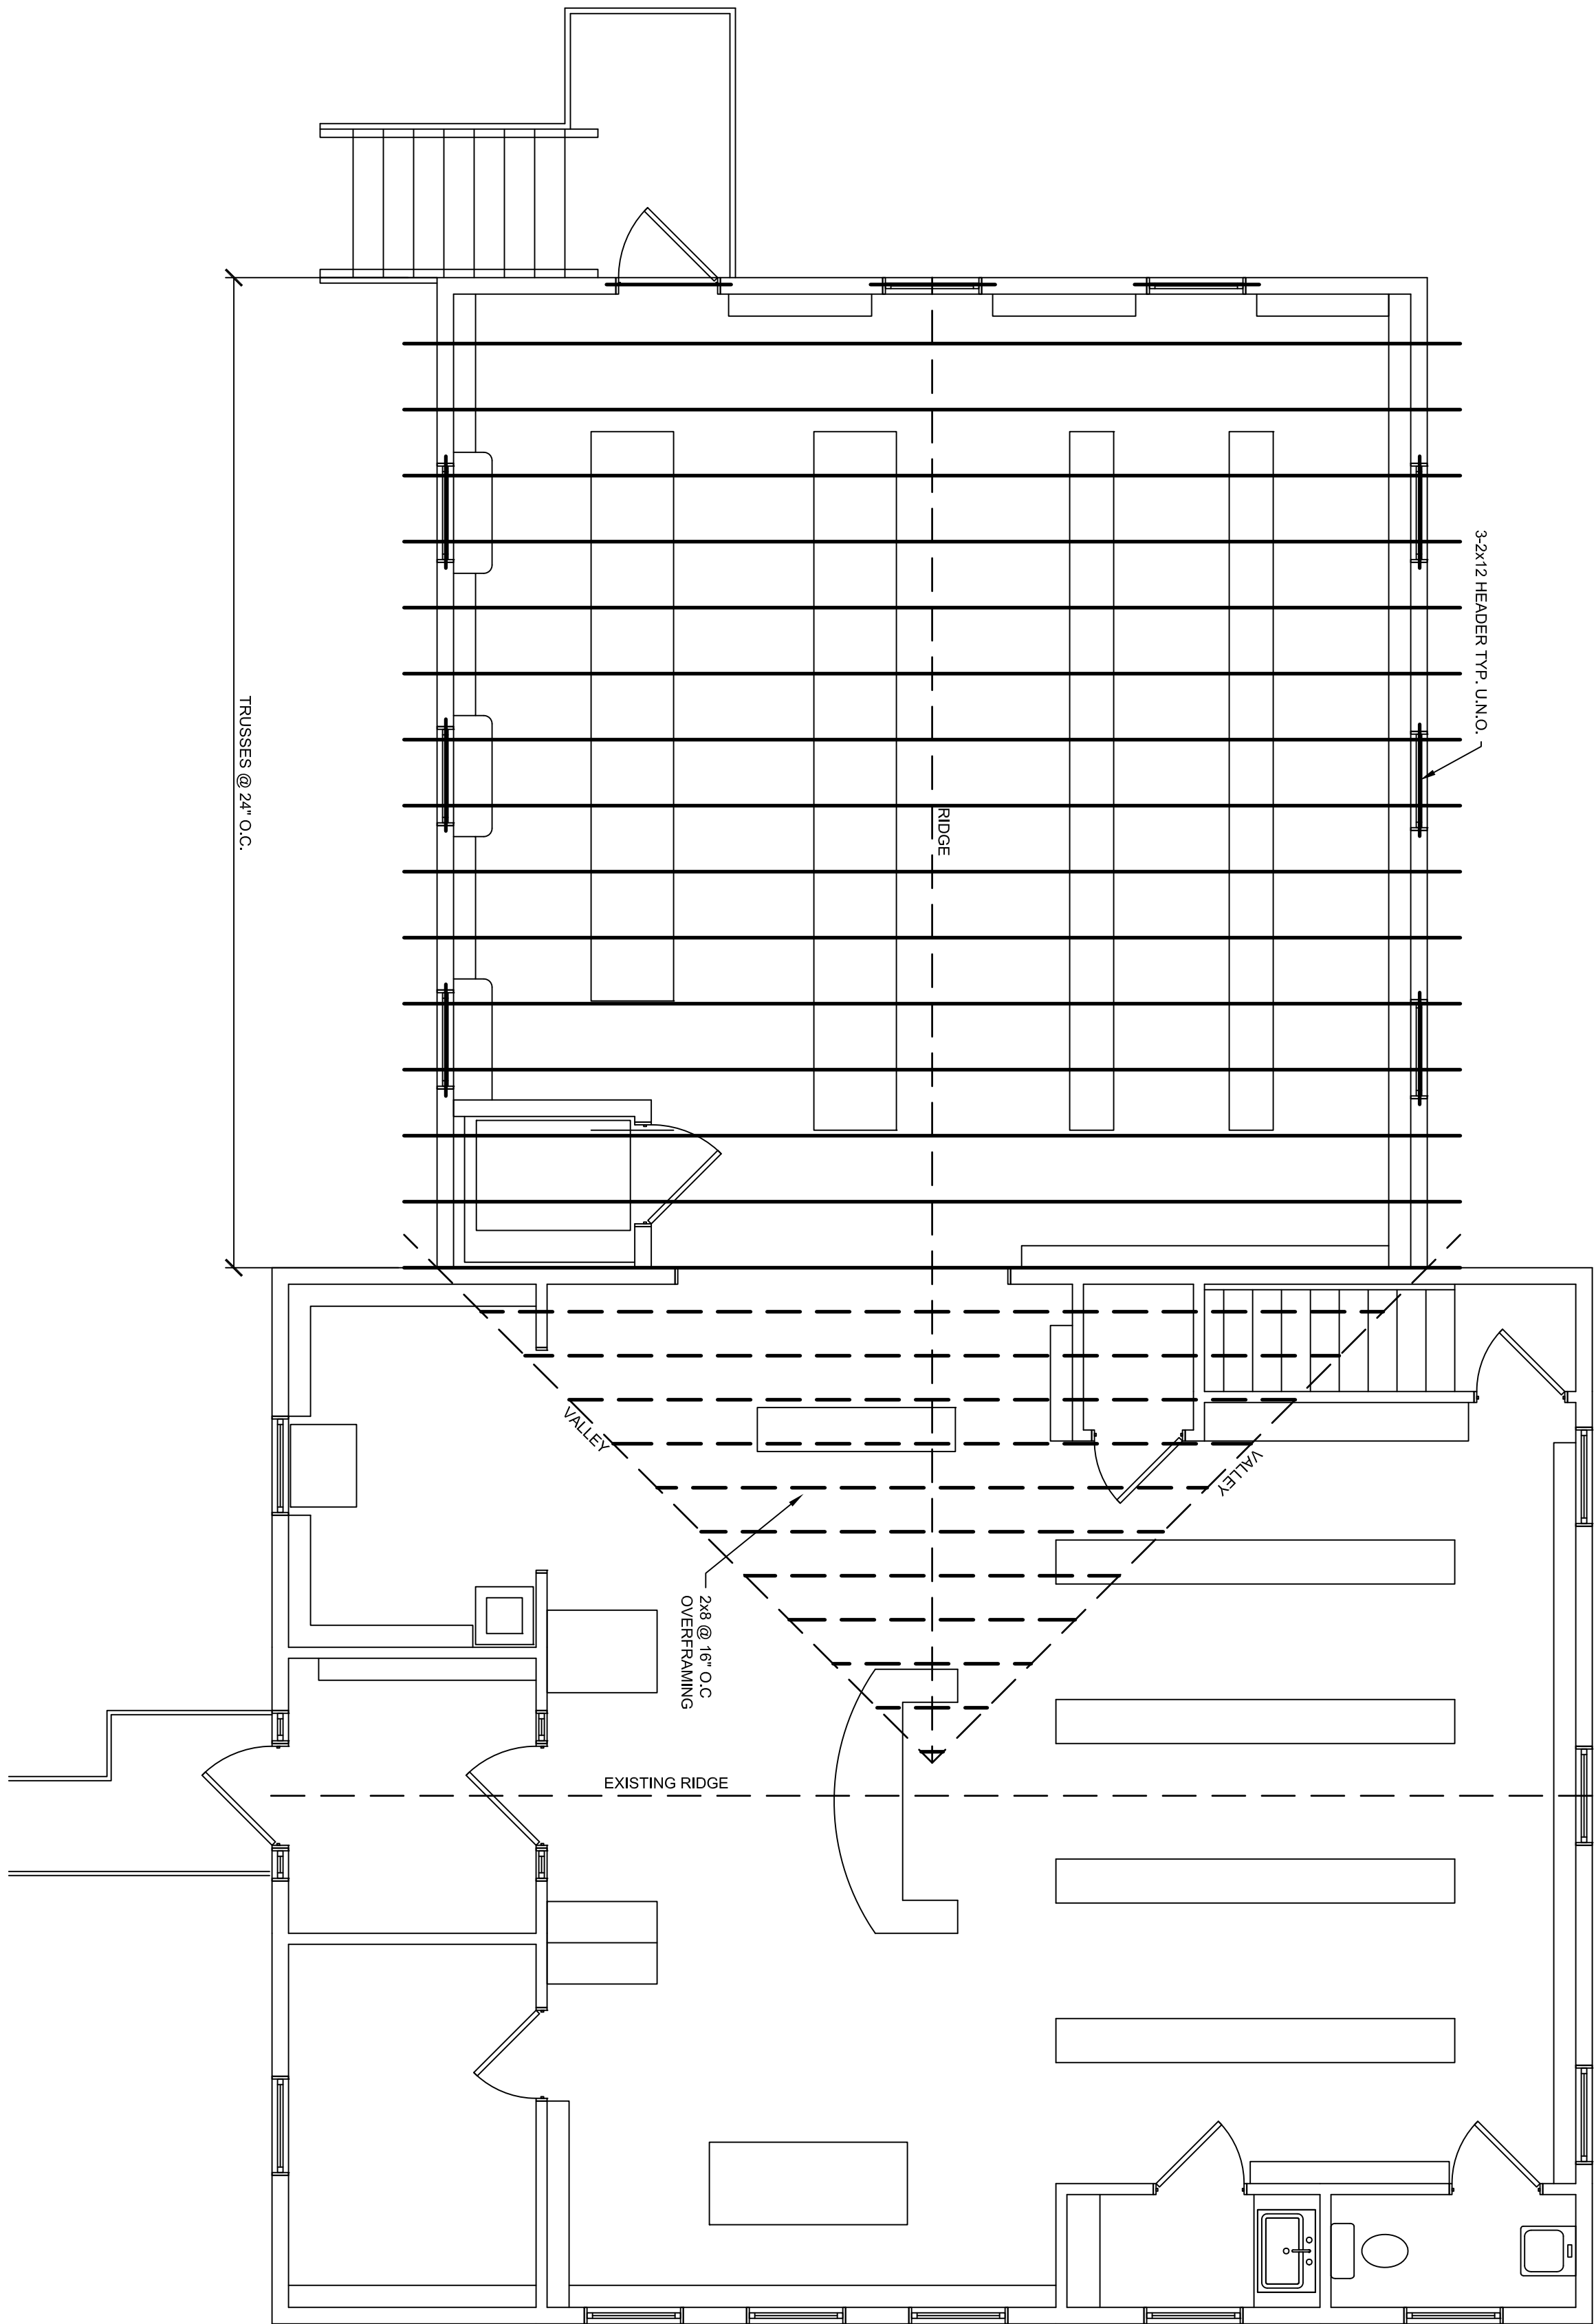

ROOF FRAMING PLAN

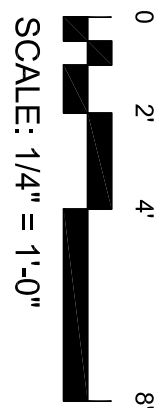

SCALE: 1/4" = 1'-0"

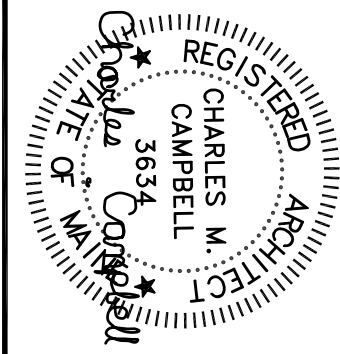

Chuck Campbell Architect PLLC
127 UNION ROAD
Waldoboro, Maine 04572
TEL (207)557-0448
e-mail chuck@chuckcampbellarchitect.com



PROJECT:
FRIENDSHIP LIBRARY
ADDRESS: **3 MAINE STREET**
FRIENDSHIP, MAINE

NO.	REVISIONS	DATE

SHEET TITLE:
ROOF FRAMING PLAN
SCALE: **AS INDICATED**
DATE: **AUGUST 13, 2026**

PROJ. ID: FRIENDSHIP

A6.2

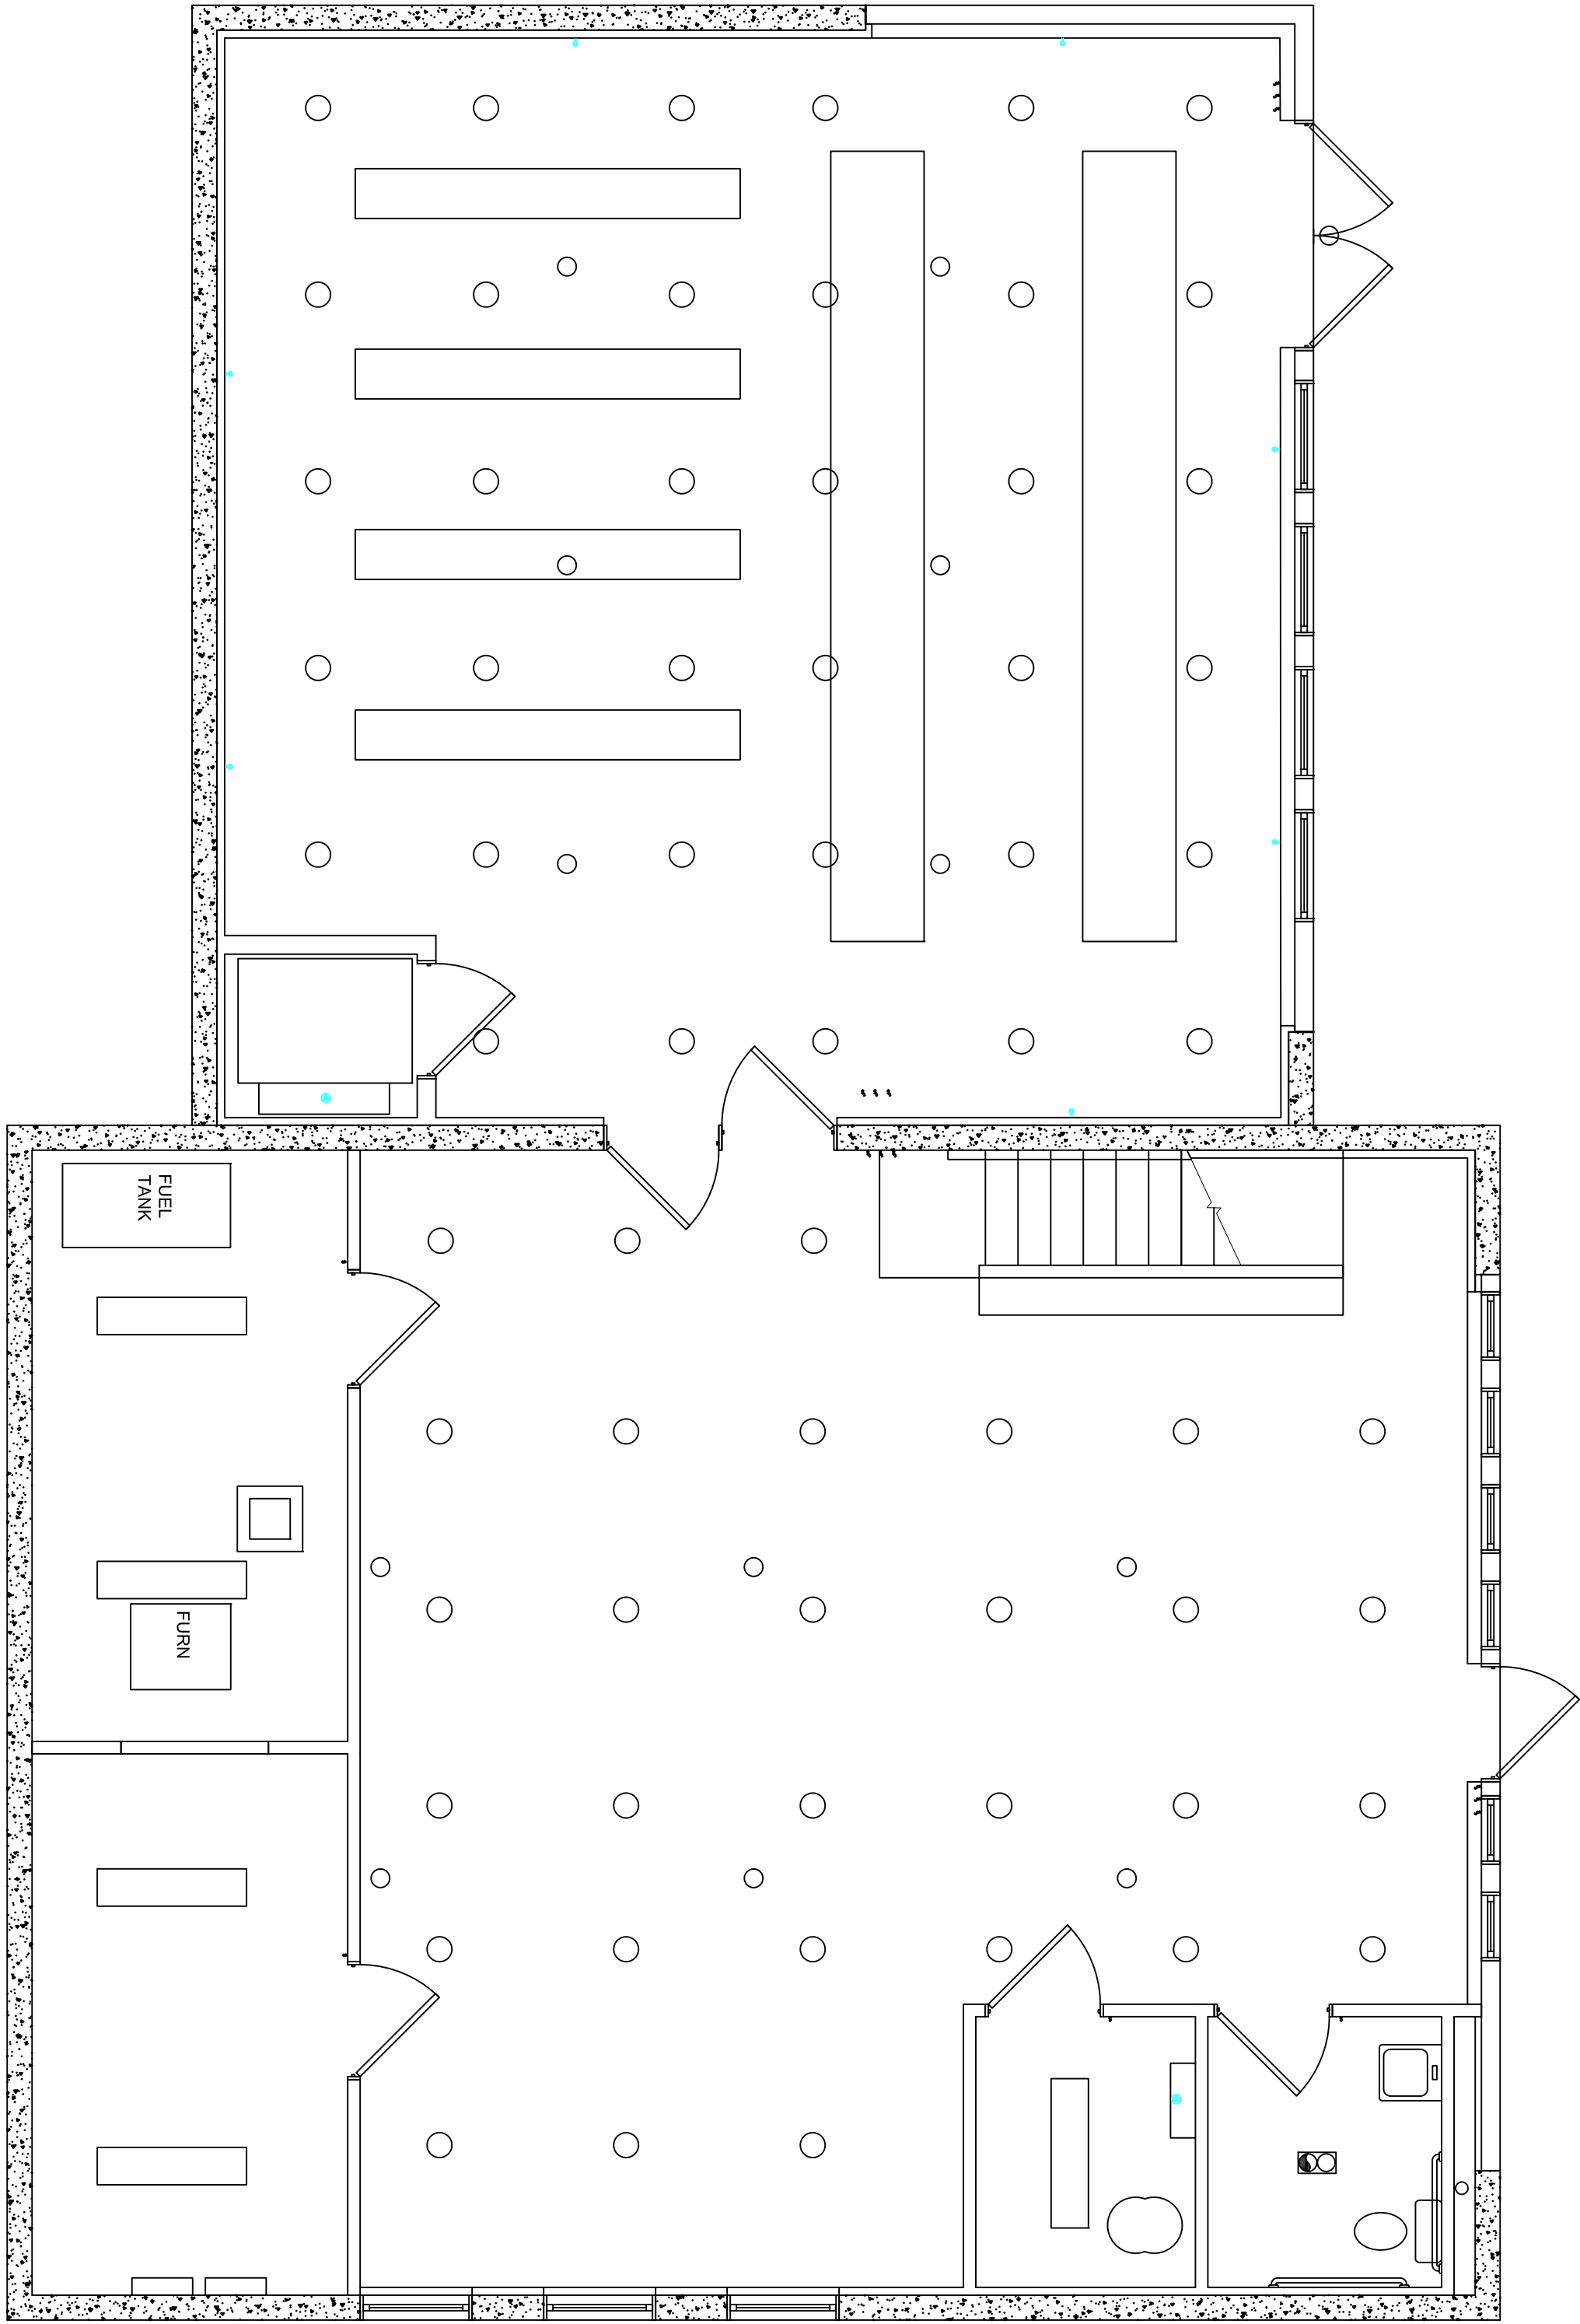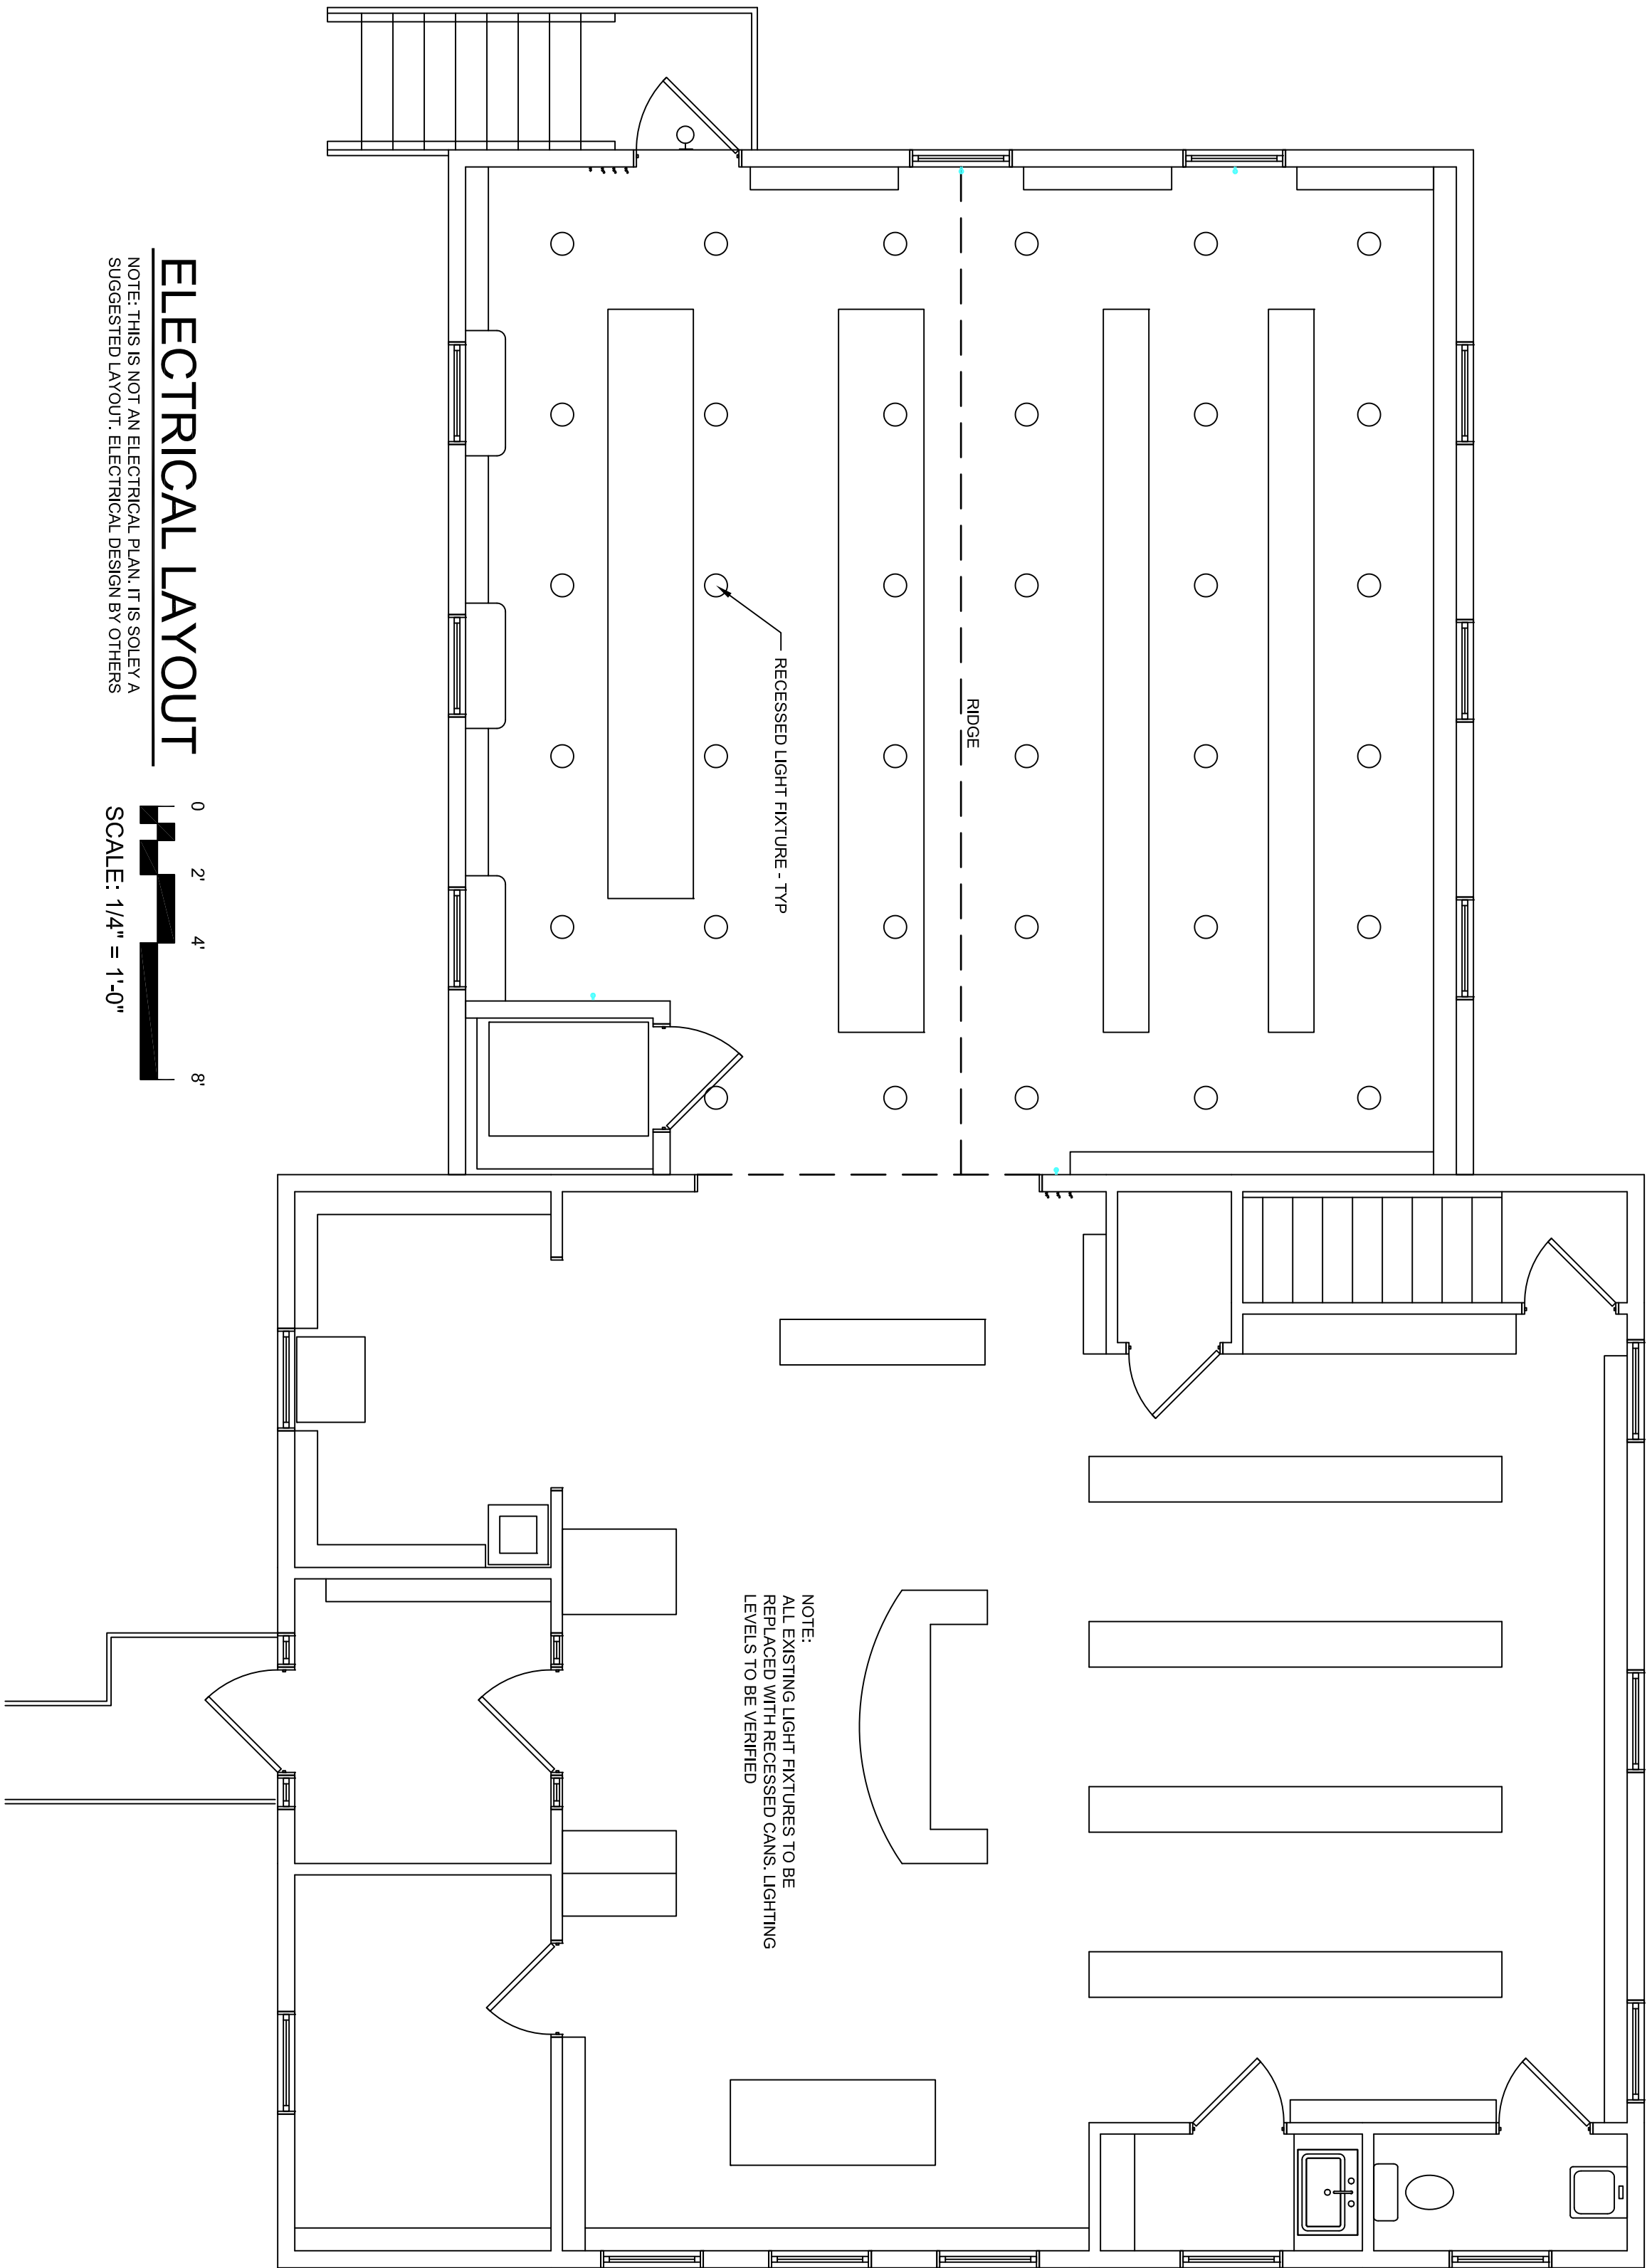

Chuck Campbell Architect PLLC
127 UNION ROAD
Waldoboro, Maine 04572
TEL (207)557-0448
e-mail chuck@chuckcampbellarchitect.com


PROJECT:
FRIENDSHIP LIBRARY
ADDRESS:
**3 MAINE STREET
FRIENDSHIP, MAINE**

SHEET TITLE:
ELECTRICAL LAYOUT
SCALE:
AS INDICATED
DATE:
AUGUST 13, 2026


NO.	REVISIONS	DATE

PROJ. ID: FRIENDSHIP


A7.1

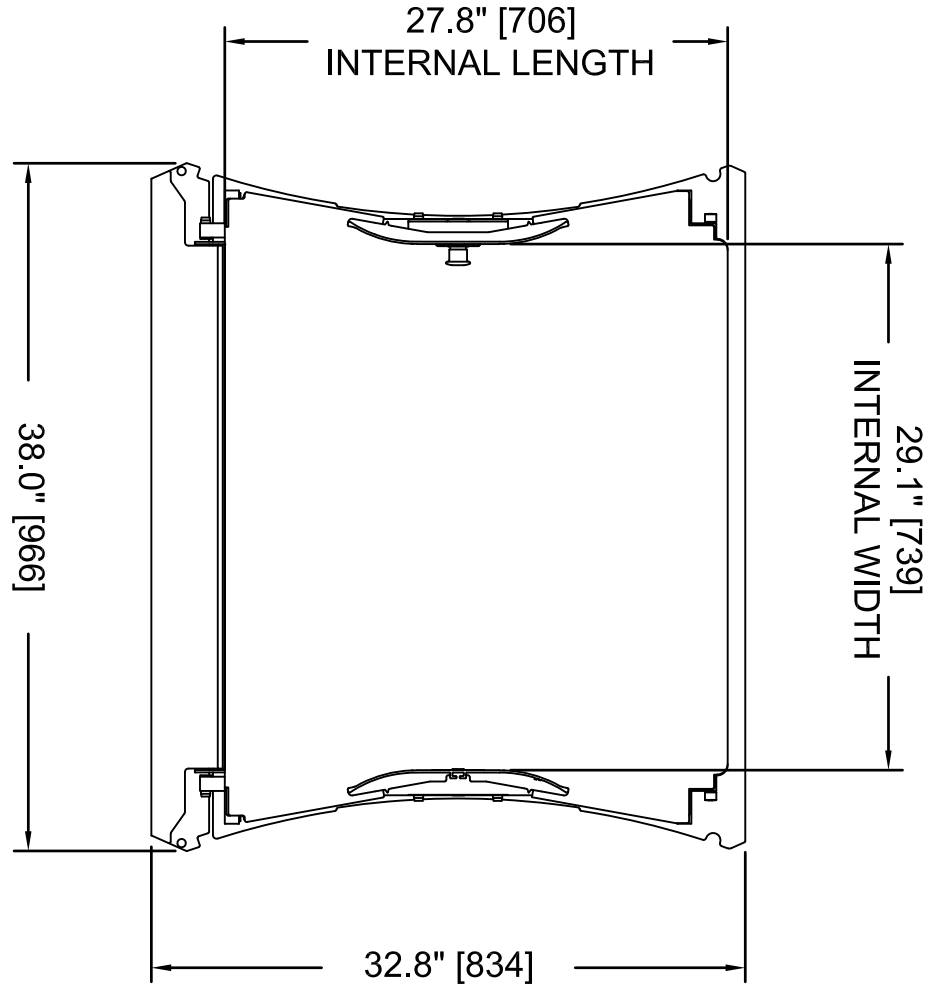


TOP VIEW CAB INTERIOR
SCALE: 3:1

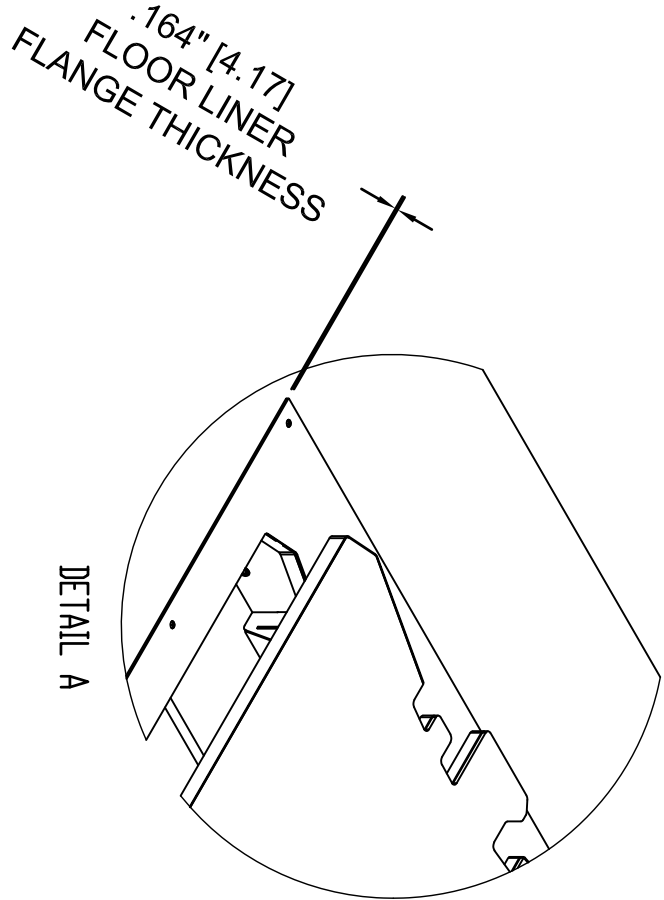


FLOOR PLUG SYSTEM
SCALE: 3:1

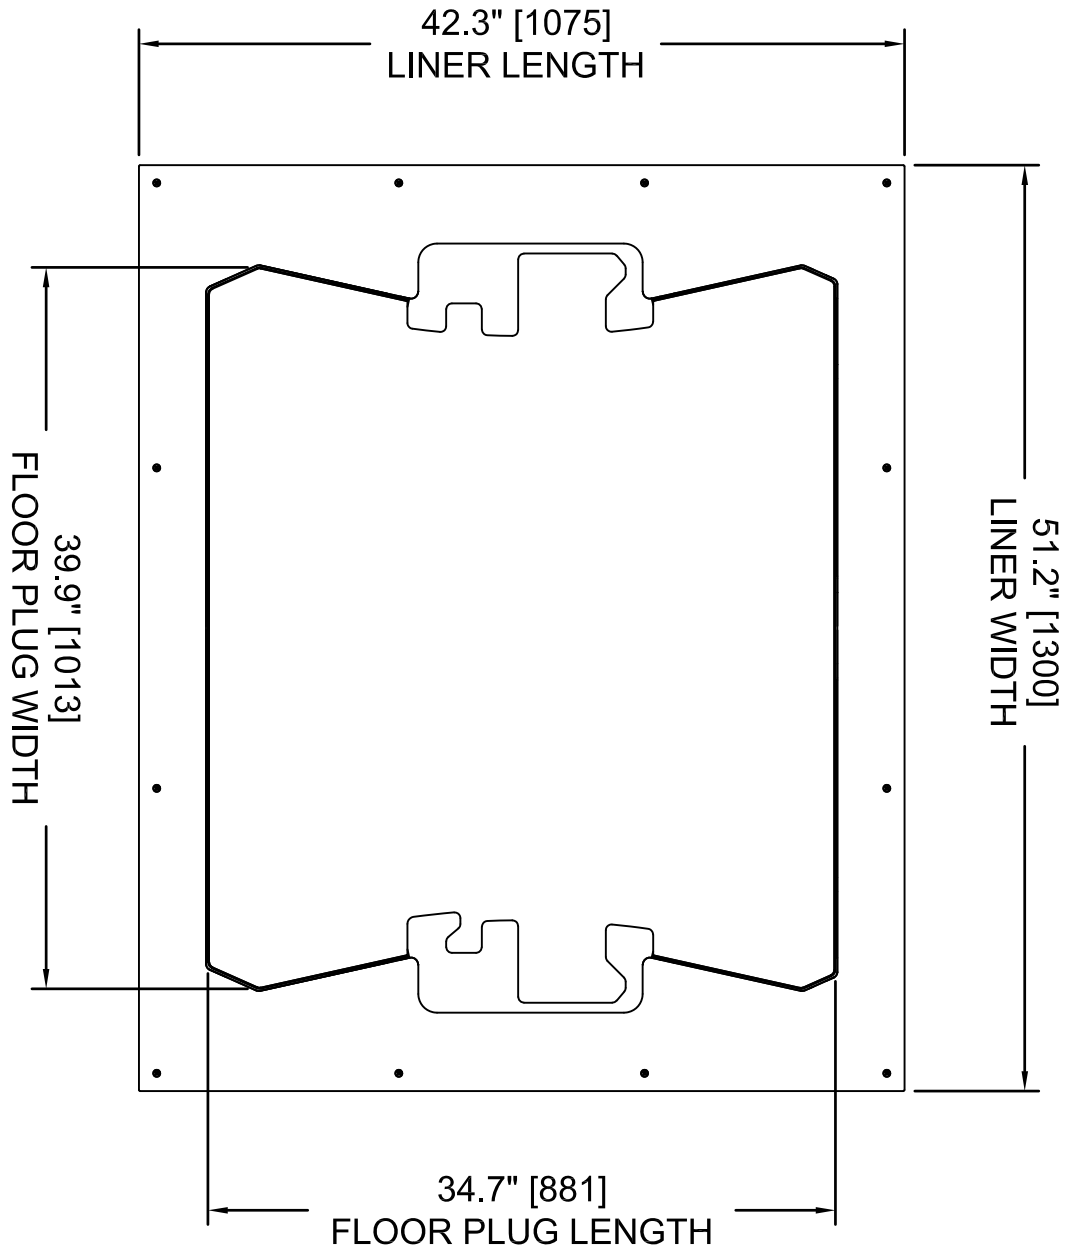


FLOOR PLUG - PLYWOOD 3/4"
20 LBS ACTIVATION LOAD
300 LBS MAX LOAD

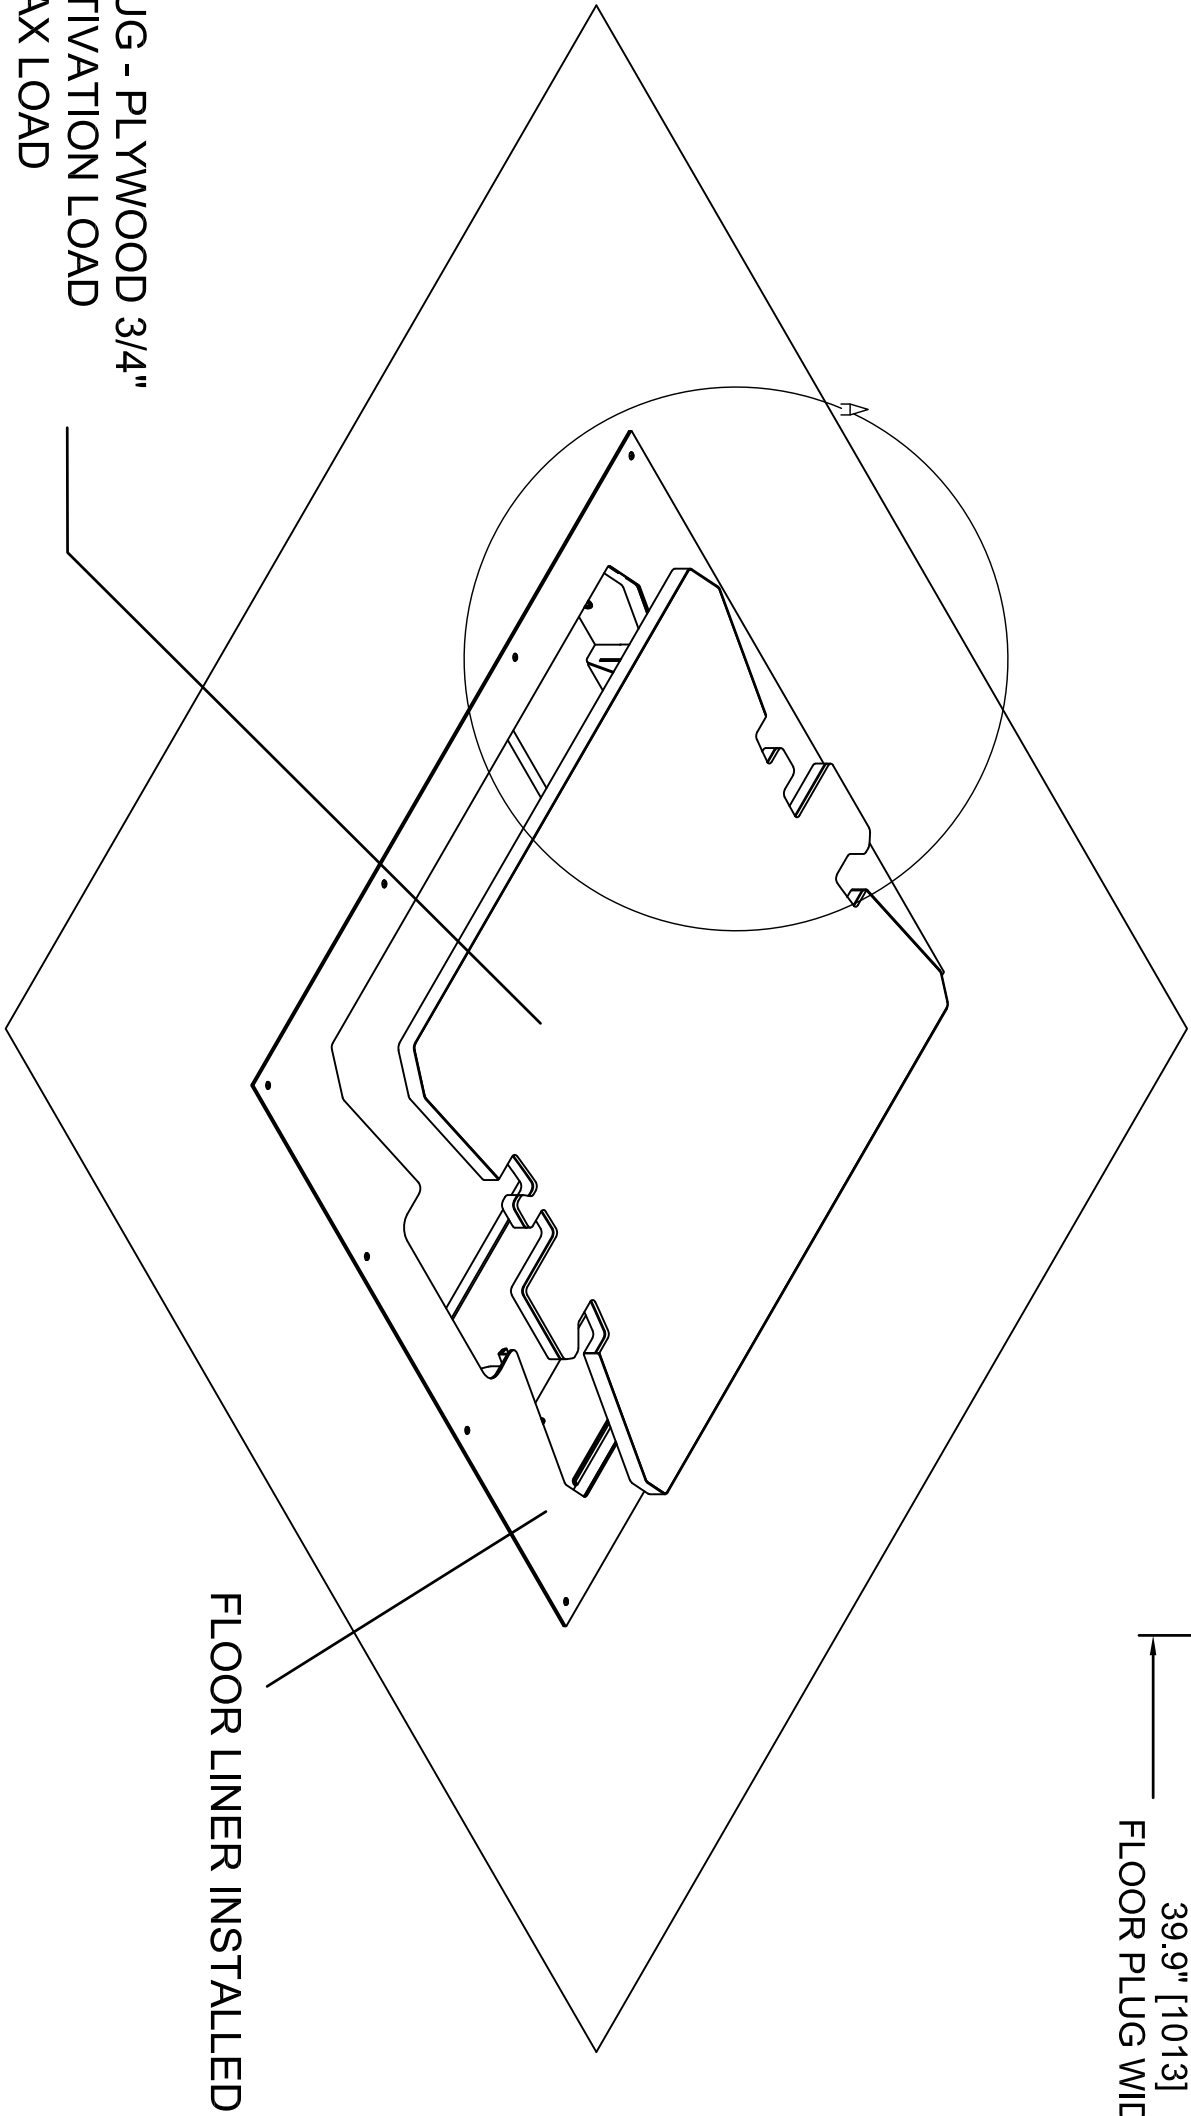

FLOOR LINER INSTALLED

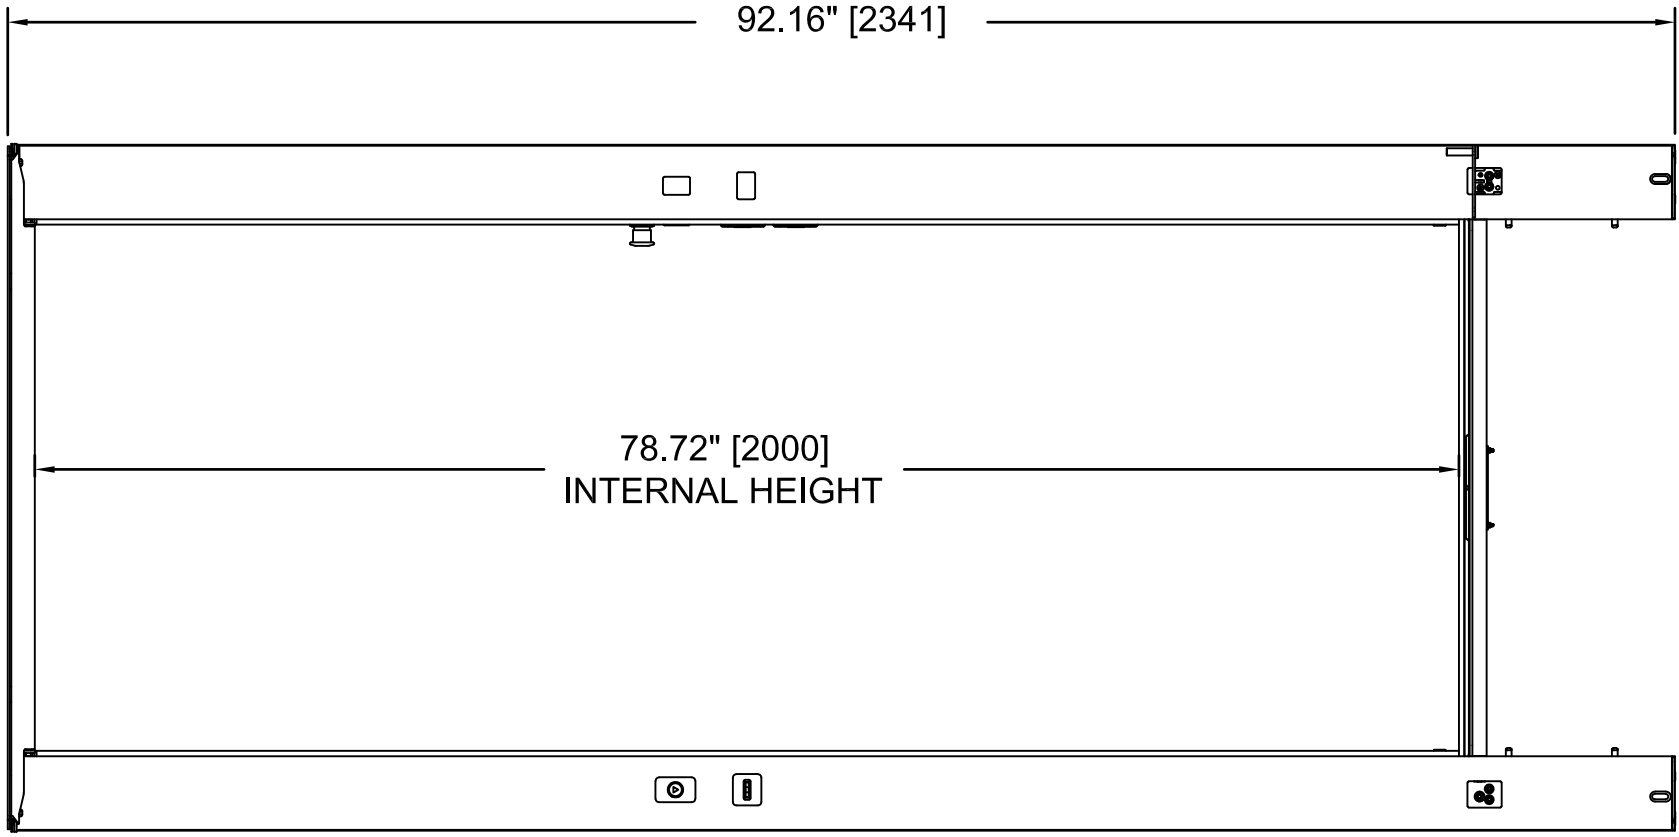

FRONT VIEW CAB INTERIOR
SCALE: 3:1

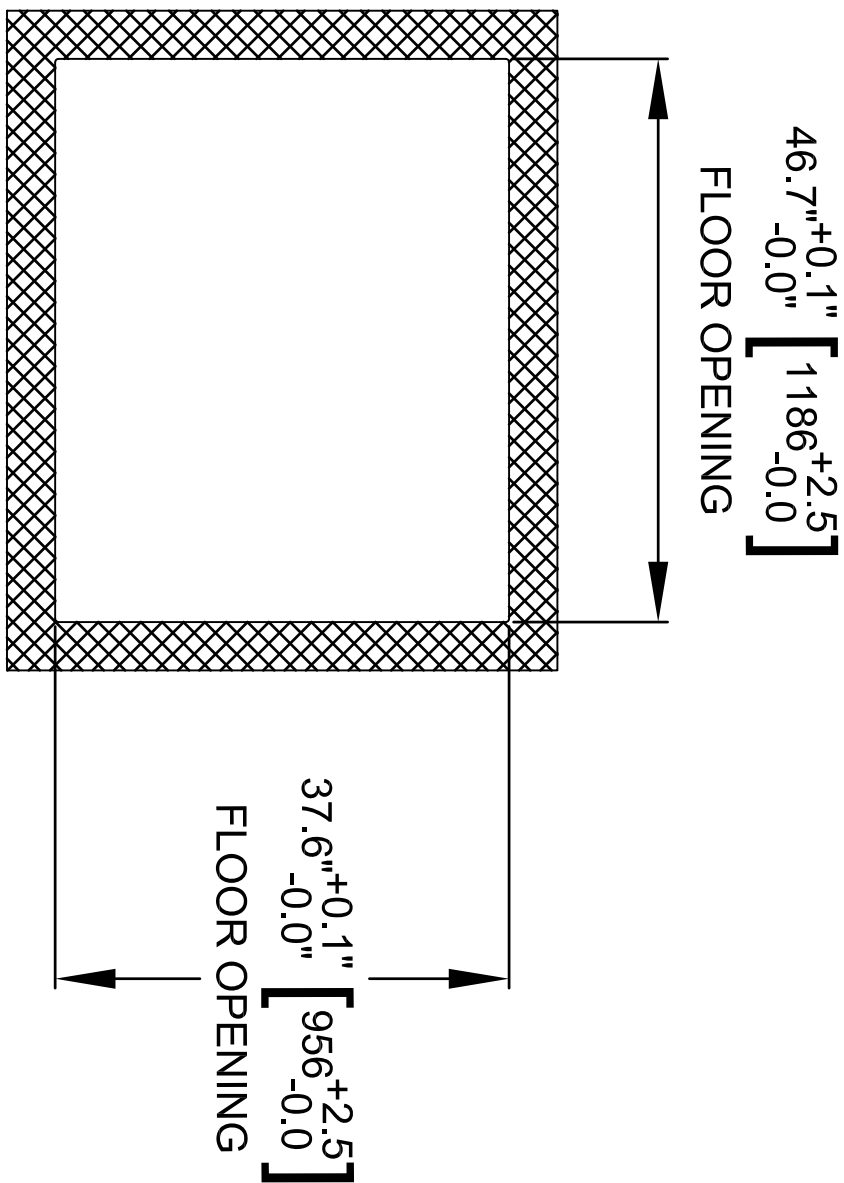

2"x6" OR 2"x8" WOOD BEAM TO BE FIRMLY CONNECTED THROUGH
COUNTER BORE HOLES TO HAVE FLUSH END

2ND FLOOR CUTOUT - LUMA TYPE 1
SCALE: 2:1

LUMA SPECIFICATIONS

Capacity	180 kg / 400 lb
Nominal Speed	0.076 m/s — 15 ft/min
Power Supply	100 — 240 VAC, single phase, 15A
Drive System	Winding drum
Operating Temperature	10 C to +35 C
Cab Size	Type1: 739mm x 706 mm (29.1" x 27.8") Type 2: 739mm x 655 mm (29.1" x 25.8")
Cab walls	Clear Acrylic
Cab interior height	2000mm (78.74 in) / 1905 mm (75 in)
Cab floor area	0.57 m ² 2 (890 in ² 2)
Maximum Travel	4200 mm (165.35")
Distance between 2 Landings (minimum)	300 mm (11.8 in)
Noise Level (Typical Installation)	55 db
Daily Cycle	40
Levels Serviced	2
Overhead Clearance (Minimum) for 2000 mm cab	2402 mm (94.5 in)
Overhead Clearance (Minimum) for 1905 mm cab	2307 mm (90.8 in)
Minimum Lower ceiling height (2000mm cab)	2089 mm (82.64 in)
Minimum Lower ceiling height (1905mm cab)	2004 mm (78.9 in)
Max distance from lower landing to top ceiling(2000 mm Cab)	6601 mm (259.9 in)
Max distance from lower landing to top ceiling (1905 mm Cab)	6505 mm (256.14 in)
FLOOR THICKNESS	MIN— 200 mm (7.88 in) MAX — 360 mm (14.17 in)
Control System	Universal Vertical Controller
Compliance	ASME 17.1, EN 81—41
Safety feature	Overspeed, slack rope, manual lowering, e—stop, Top & Bottom safety pons.
Phone System	One Touch Alert
Options	Type 1&2 Standard Height Lower height

SAFETY FEATURES

- 1) CSA CERTIFIED WR500 LOCK
- 2) UNDER PANEL SAFETY SENSOR
- 3) EMERGENCY STOP AND ALARM
- 4) EMERGENCY BATTERY
- 5) ENCLOSED DRIVE BOX
- 6) SLACK ROPE SAFETY DEVICE
- 7) OVER SPEED SAFETY DEVICE
- 8) TELEPHONE PUSH BUTTON IN CAB
- 9) LED LIGHT IN CAB

CUSTOMER :		
PROJECT :		
DATE :		
PROJECTION	TOLERANCES IF NOT SPECIFIED	
	FRAC: ±1/8" [3]	
SCALE:	DRAWN BY:	
NOT TO SCALE	DS	
DATE:	MARCH 12, 2025	
DRAWING #	REV#	PAGE:
600496	1	2
		TITRE:
		LUMA LAYOUT

Chuck Campbell Architect PLLC
127 UNION ROAD
Waldoboro, Maine 04572
TEL (207)557-0448
e-mail chuck@chuckcampbellarchitect.com

PROJECT:
FRIENDSHIP LIBRARY
ADDRESS:
3 MAINE STREET
FRIENDSHIP, MAINE

SHEET TITLE:
ELEVATOR
SCALE:
AS INDICATED
DATE:
AUGUST 13, 2026

PROJ. ID: FRIENDSHIP

A8.1

